






ARCHITECTURAL DRAWINGS


DESIGN OF STAFF QUARTER (G+2) AT TSHENKHARI, NANGLAM

SCHEDULE OF DRAWINGS	
DRAWING NAME	PAGE NUMBER
SITE PLAN	01
TENTATIVE FURNITURE & FLOORING LAYOUT PLAN	02
GROUND FLOOR PLAN	03
FIRST FLOOR PLAN	04
SECOND FLOOR PLAN	05
JAMTHOG PLAN	06
ROOF PLAN	07
ELEVATION 1 & ELEVATION 2	08
ELEVATION 3 & ELEVATION 4	09
SECTION AA' & SECTION BB'	10
STAIRCASE DETAILS	11
TOILET PART PLANS	12
KITCHEN PART PLANS	13
SCHEDULE OF OPENINGS	14
WINDOW W1	15
KITCHEN WINDOW KW1	16
DOOR WINDOW DW1	17
VENTILATORS V1 & V2	18
RABSEY WINDOW RW1	19
DOOR DETAILS D1 & D2	20
DOOR DETAILS D3 & D4	21
WINDOW DETAILS (BLOW UPS)	22
RABSEY CORNICE DETAILS	23
FLOORING DETAILS	24
RAILING DETAILS	25
GF BALCONY GRILL DETAILS	26
SHELVE DETAILS	27-29
EAVE CEILING DETAILS	30
PLINTH PROTECTION DETAILS	31

 <div><div>BHUTAN POWER CORPORATION LIMITED</div><div>TRANSMISSION DEPARTMENT</div></div>	PROJECT TITLE		REFERENCE NOTES		APPROVED BY	DESIGNED BY	DRAWING TITLE		DRAWING NO.
	DESIGN OF STAFF QUARTER (G+2) AT TSHENKHARI, NANGLAM		1. ALL MEASUREMENTS IN THE DRAWING ARE IN mm UNLESS AND OTHERWISE MENTIONED			 SAINESH HUMAGAI ARCHITECT BA-141 (P)	COVER PAGE		BPC/TD/TMD/NANGKOR/ARCH
			2. THE MEASUREMENTS IN THE DRAWING ARE TO BE READ AND NOT MEASURED				SCALE	DATE	DWG # 00
	DRAWING STATUS	APPROVAL <div><div></div></div>	APPROVED <div><div></div></div>	3. ANY DISCREPANCY IN THE DRAWING SHALL BE IMMEDIATELY BROUGHT TO THE NOTICE OF THE DESIGNER		KUNZANG TOBGYE GENERAL MANAGER TD, BPC		-	

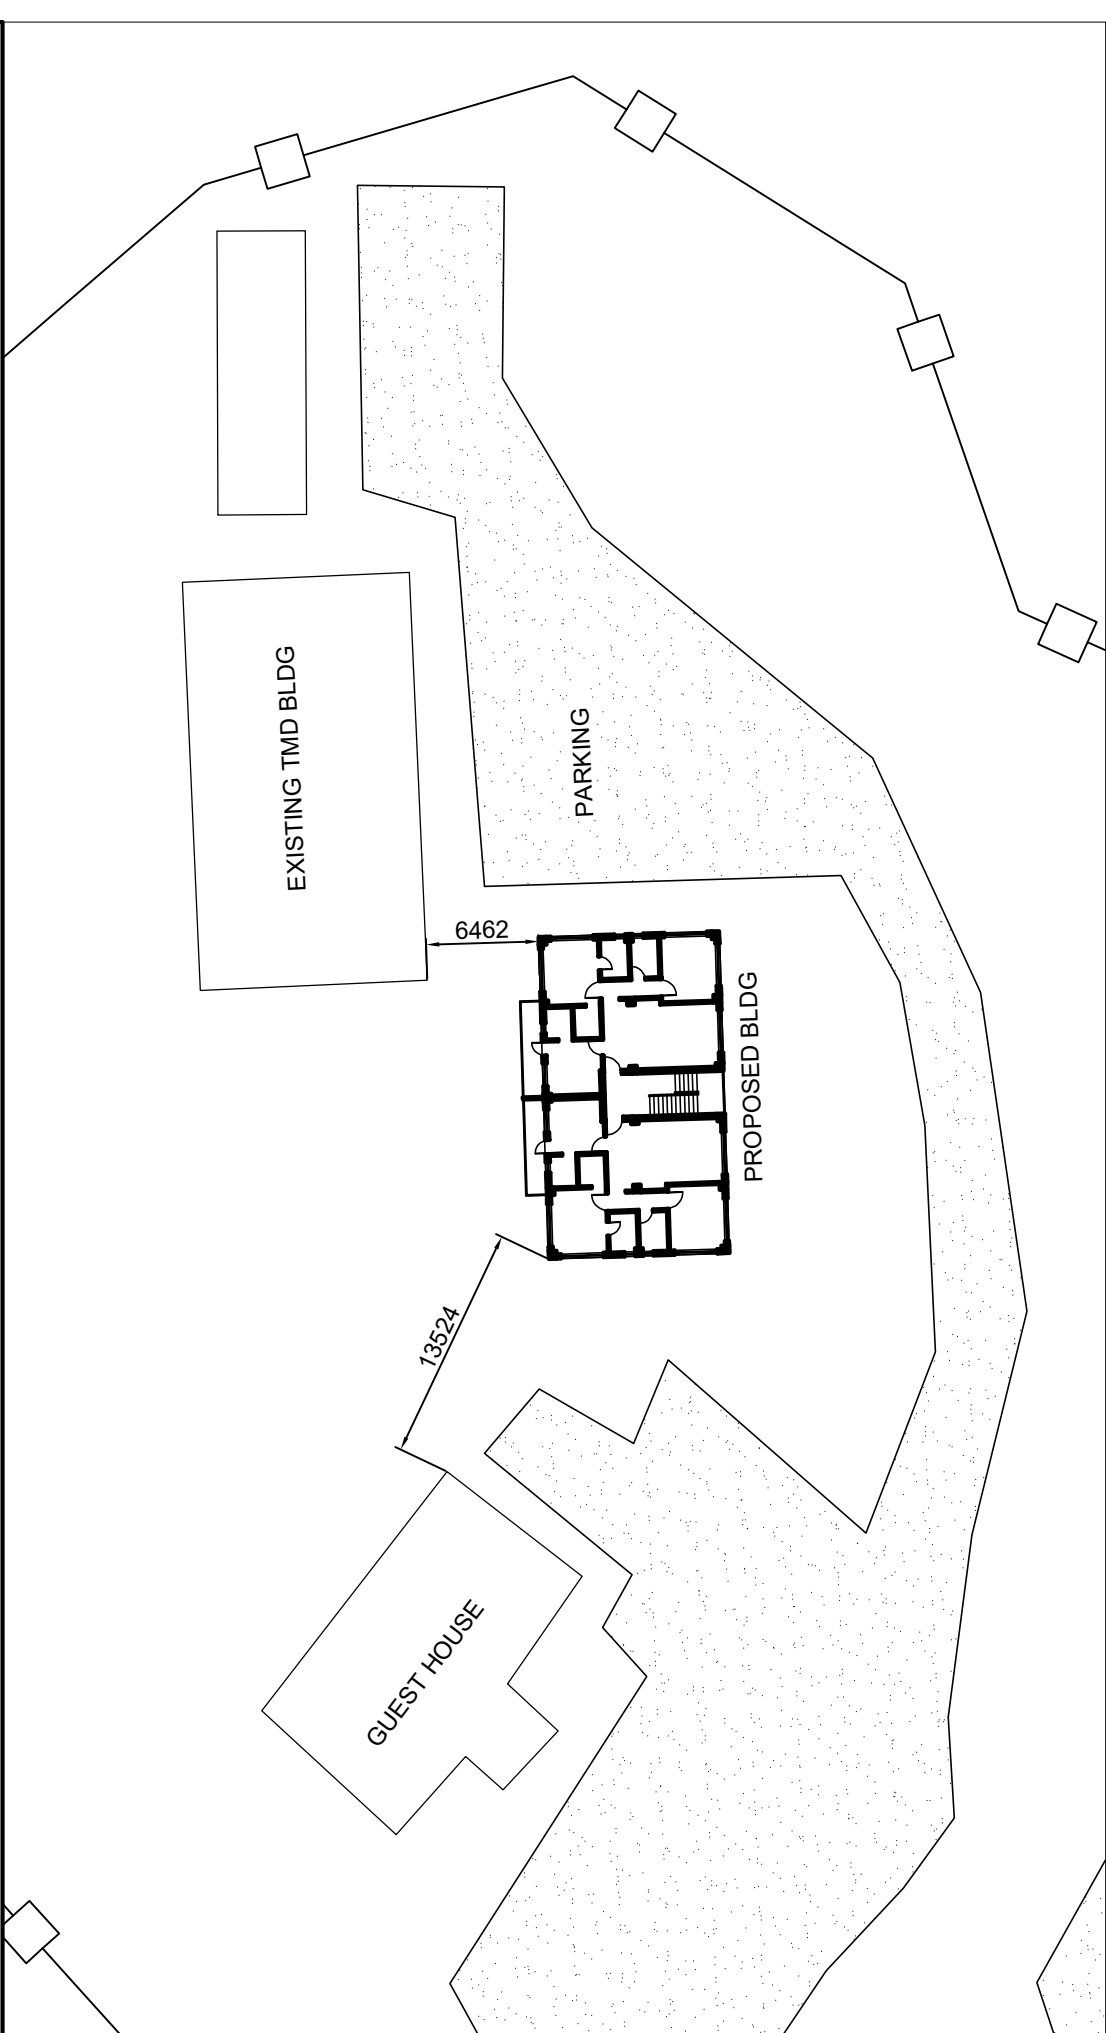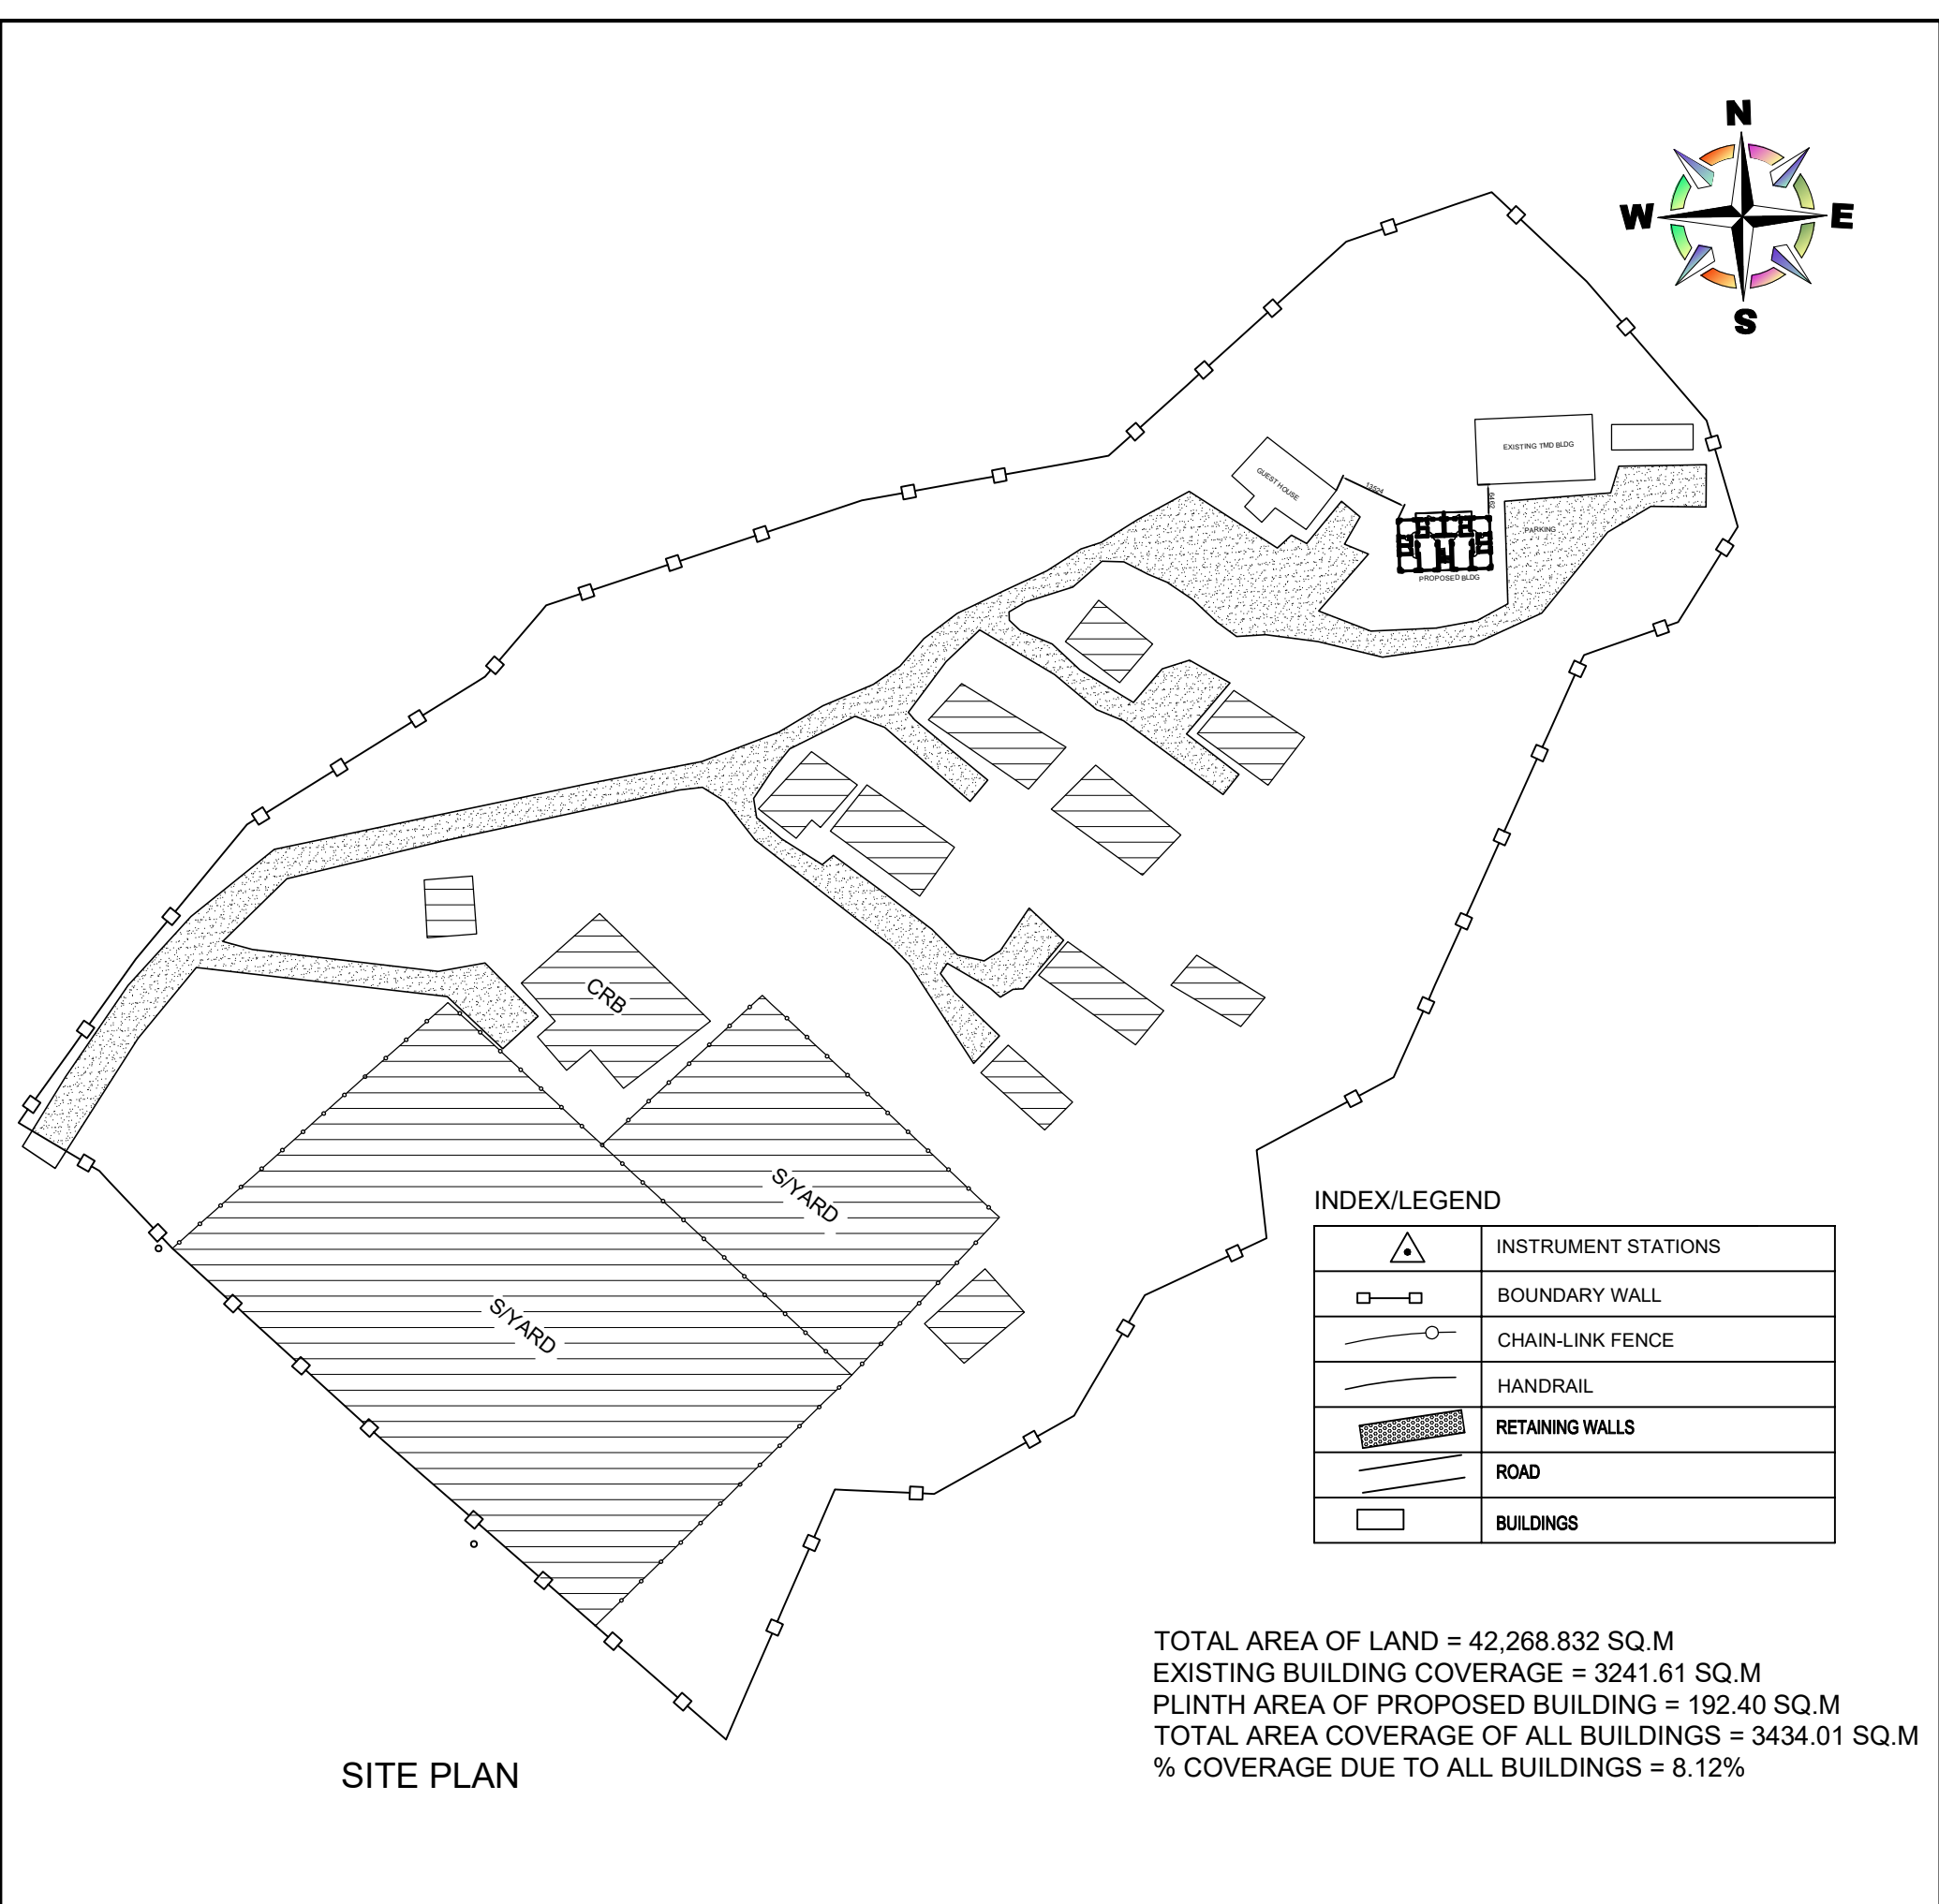

	BHUTAN POWER CORPORATION LIMITED TRANSMISSION DEPARTMENT	PROJECT TITLE			REFERENCE NOTES		APPROVED BY	DESIGNED BY	DRAWING TITLE		DRAWING NO.
		DESIGN OF STAFF QUARTER (G+2) AT TSHENKHARI, NANGLAM			1. ALL MEASUREMENTS IN THE DRAWING ARE IN mm UNLESS AND OTHERWISE MENTIONED				REFER DRAWING		BPC/TD/TMD/NANGKOR/ARCH
					2. THE MEASUREMENTS IN THE DRAWING ARE TO BE READ AND NOT MEASURED		KUNZANG TOBGYE GENERAL MANAGER TD BPC	SAILESH HUMAGAI ARCHITECT BA-141 (P)	SCALE	DATE	DWG # 01
		DRAWING STATUS	APPROVAL <input type="checkbox"/>	APPROVED <input type="checkbox"/>	3. ANY DISCREPANCY IN THE DRAWING SHALL BE IMMEDIATELY BROUGHT TO THE NOTICE OF THE DESIGNER				NTS	FEBRUARY, 2022	

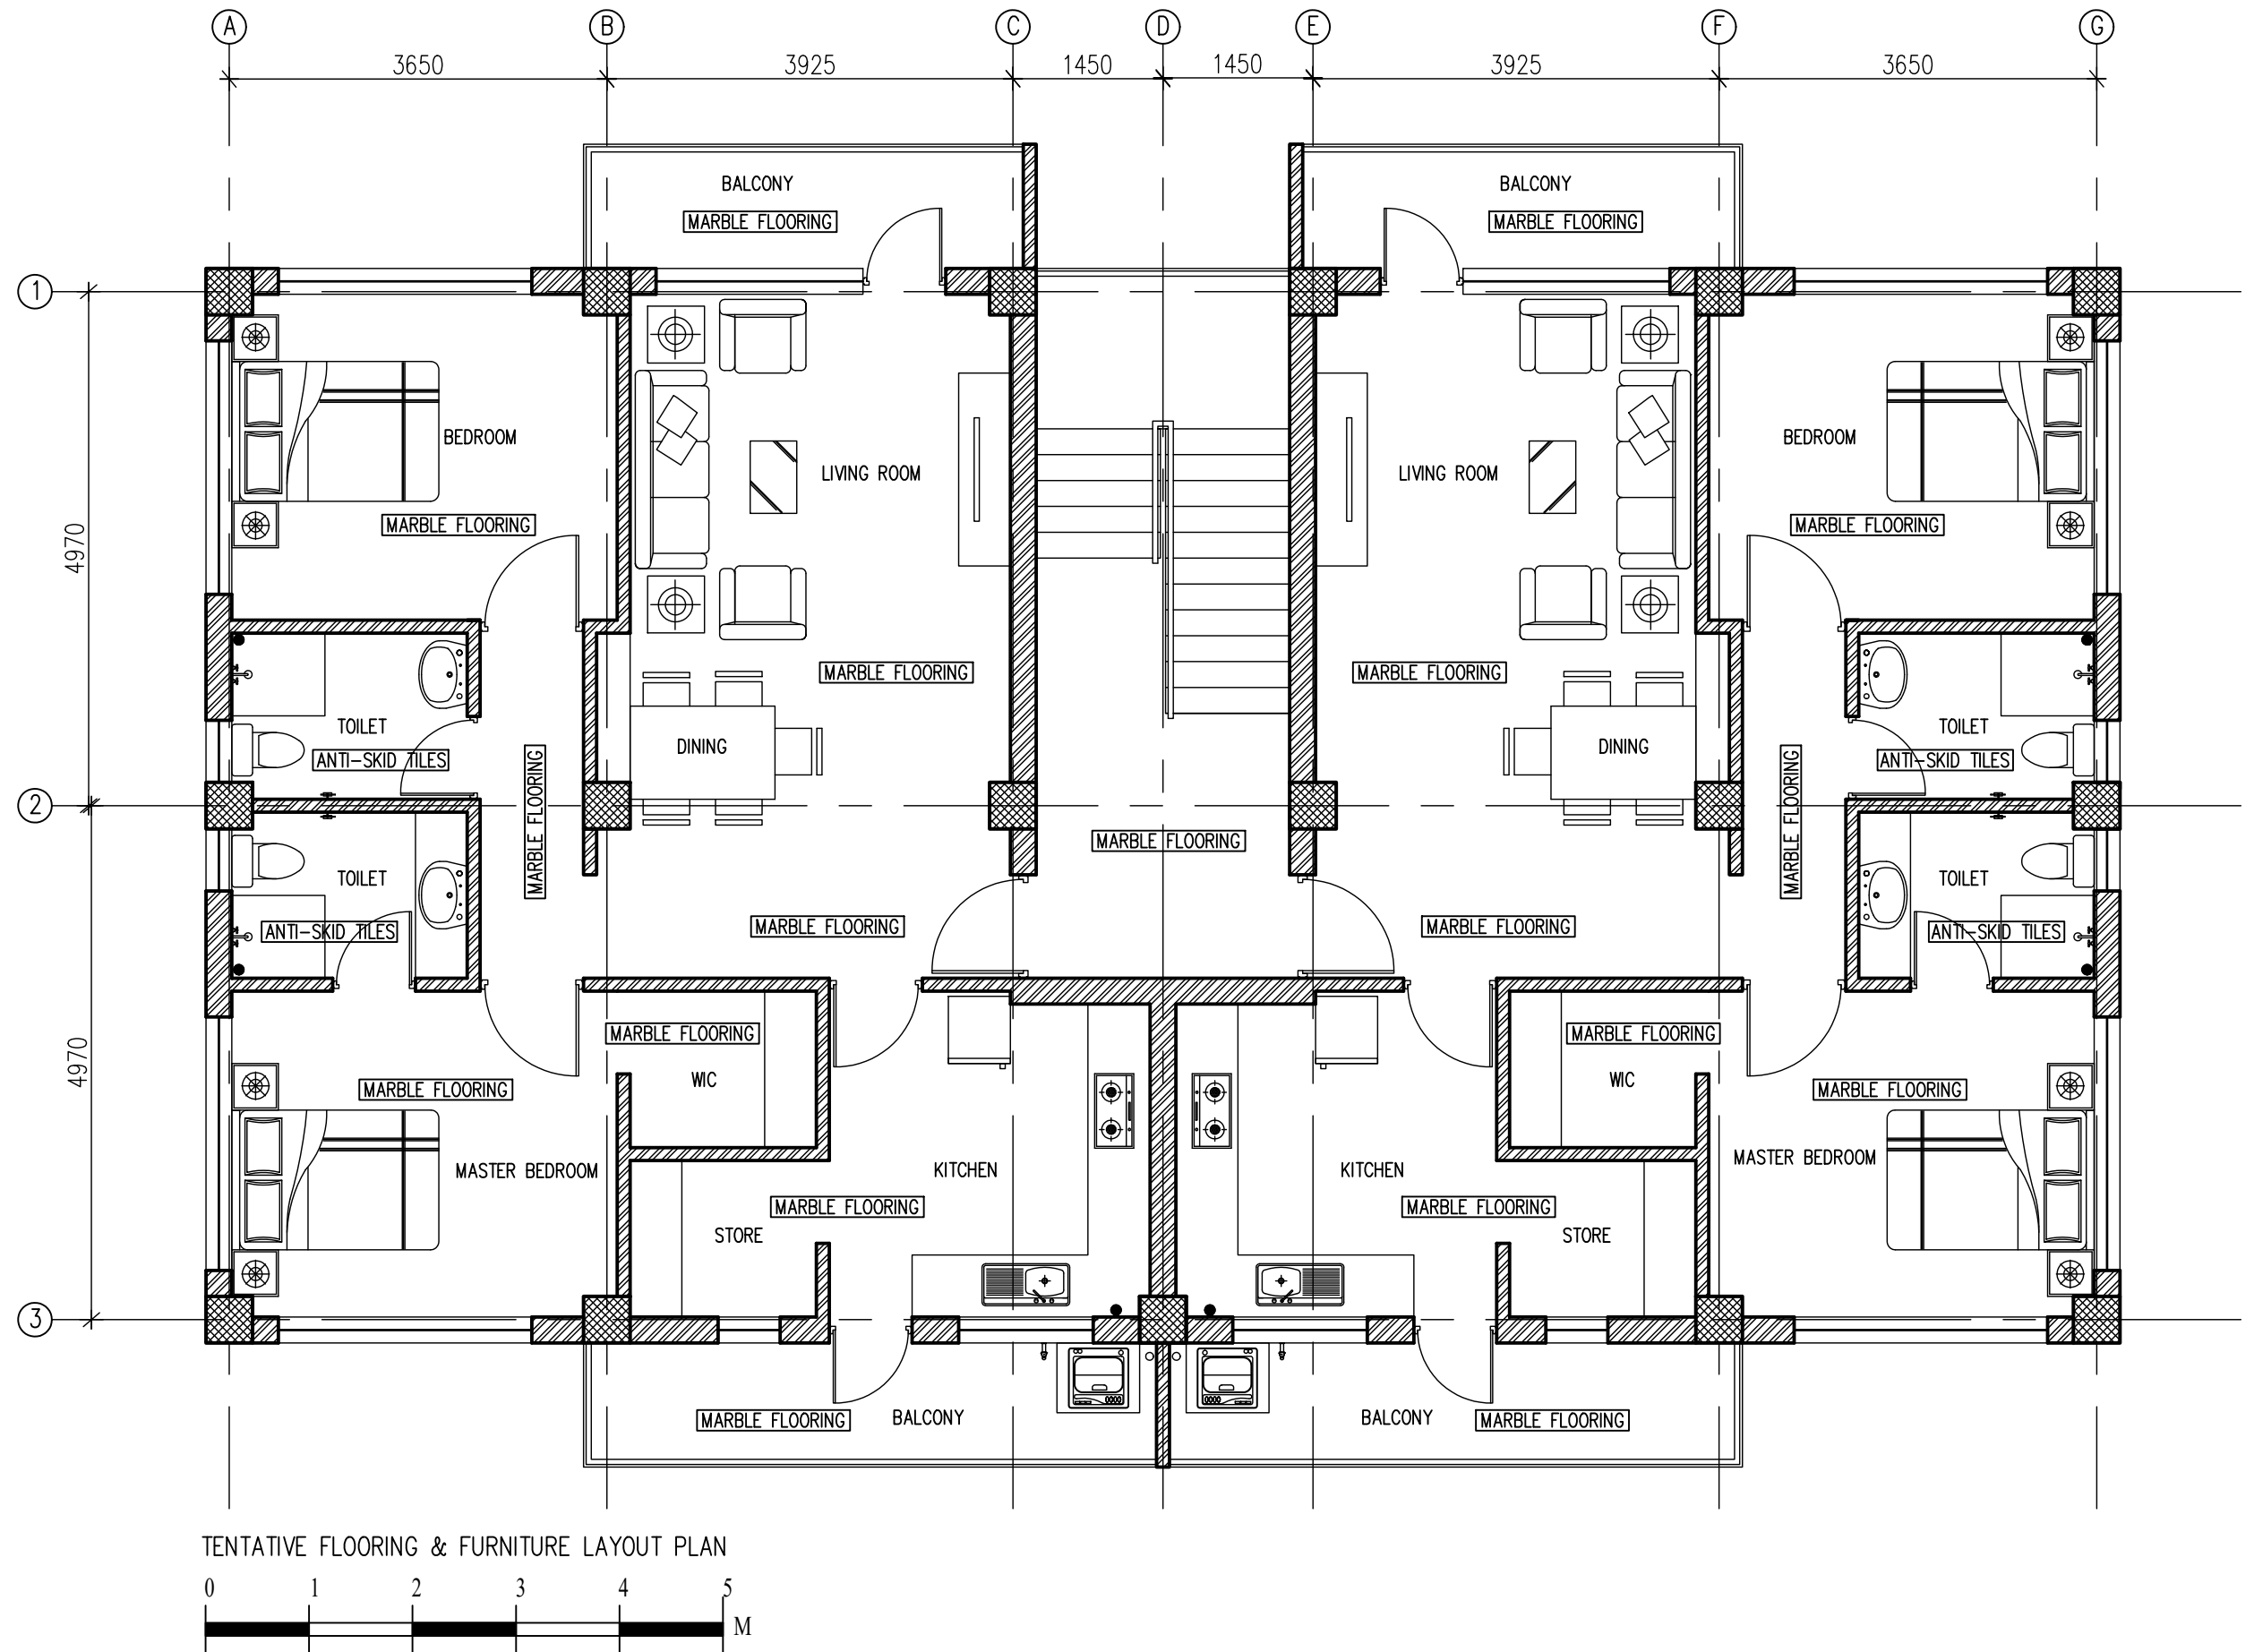

BHUTAN POWER CORPORATION LIMITED
TRANSMISSION DEPARTMENT

PROJECT TITLE
**DESIGN OF STAFF QUARTER (G+2) AT
TSHENKHARI, NANGLAM**


DRAWING STATUS: APPROVAL ☐ APPROVED ☐

REFERENCE NOTES

1. ALL MEASUREMENTS IN THE DRAWING ARE IN mm UNLESS AND OTHERWISE MENTIONED
2. THE MEASUREMENTS IN THE DRAWING ARE TO BE READ AND NOT MEASURED
3. ANY DISCREPANCY IN THE DRAWING SHALL BE IMMEDIATELY BROUGHT TO THE NOTICE OF THE DESIGNER

APPROVED BY

KUNZANG TOBGYE
GENERAL MANAGER
TD, BPC


DESIGNED BY

SAILESH KUMAGAI
ARCHITECT
BA-141 (P)

DRAWING TITLE
REFER DRAWING

SCALE: 1:75
DATE: FEBRUARY, 2022

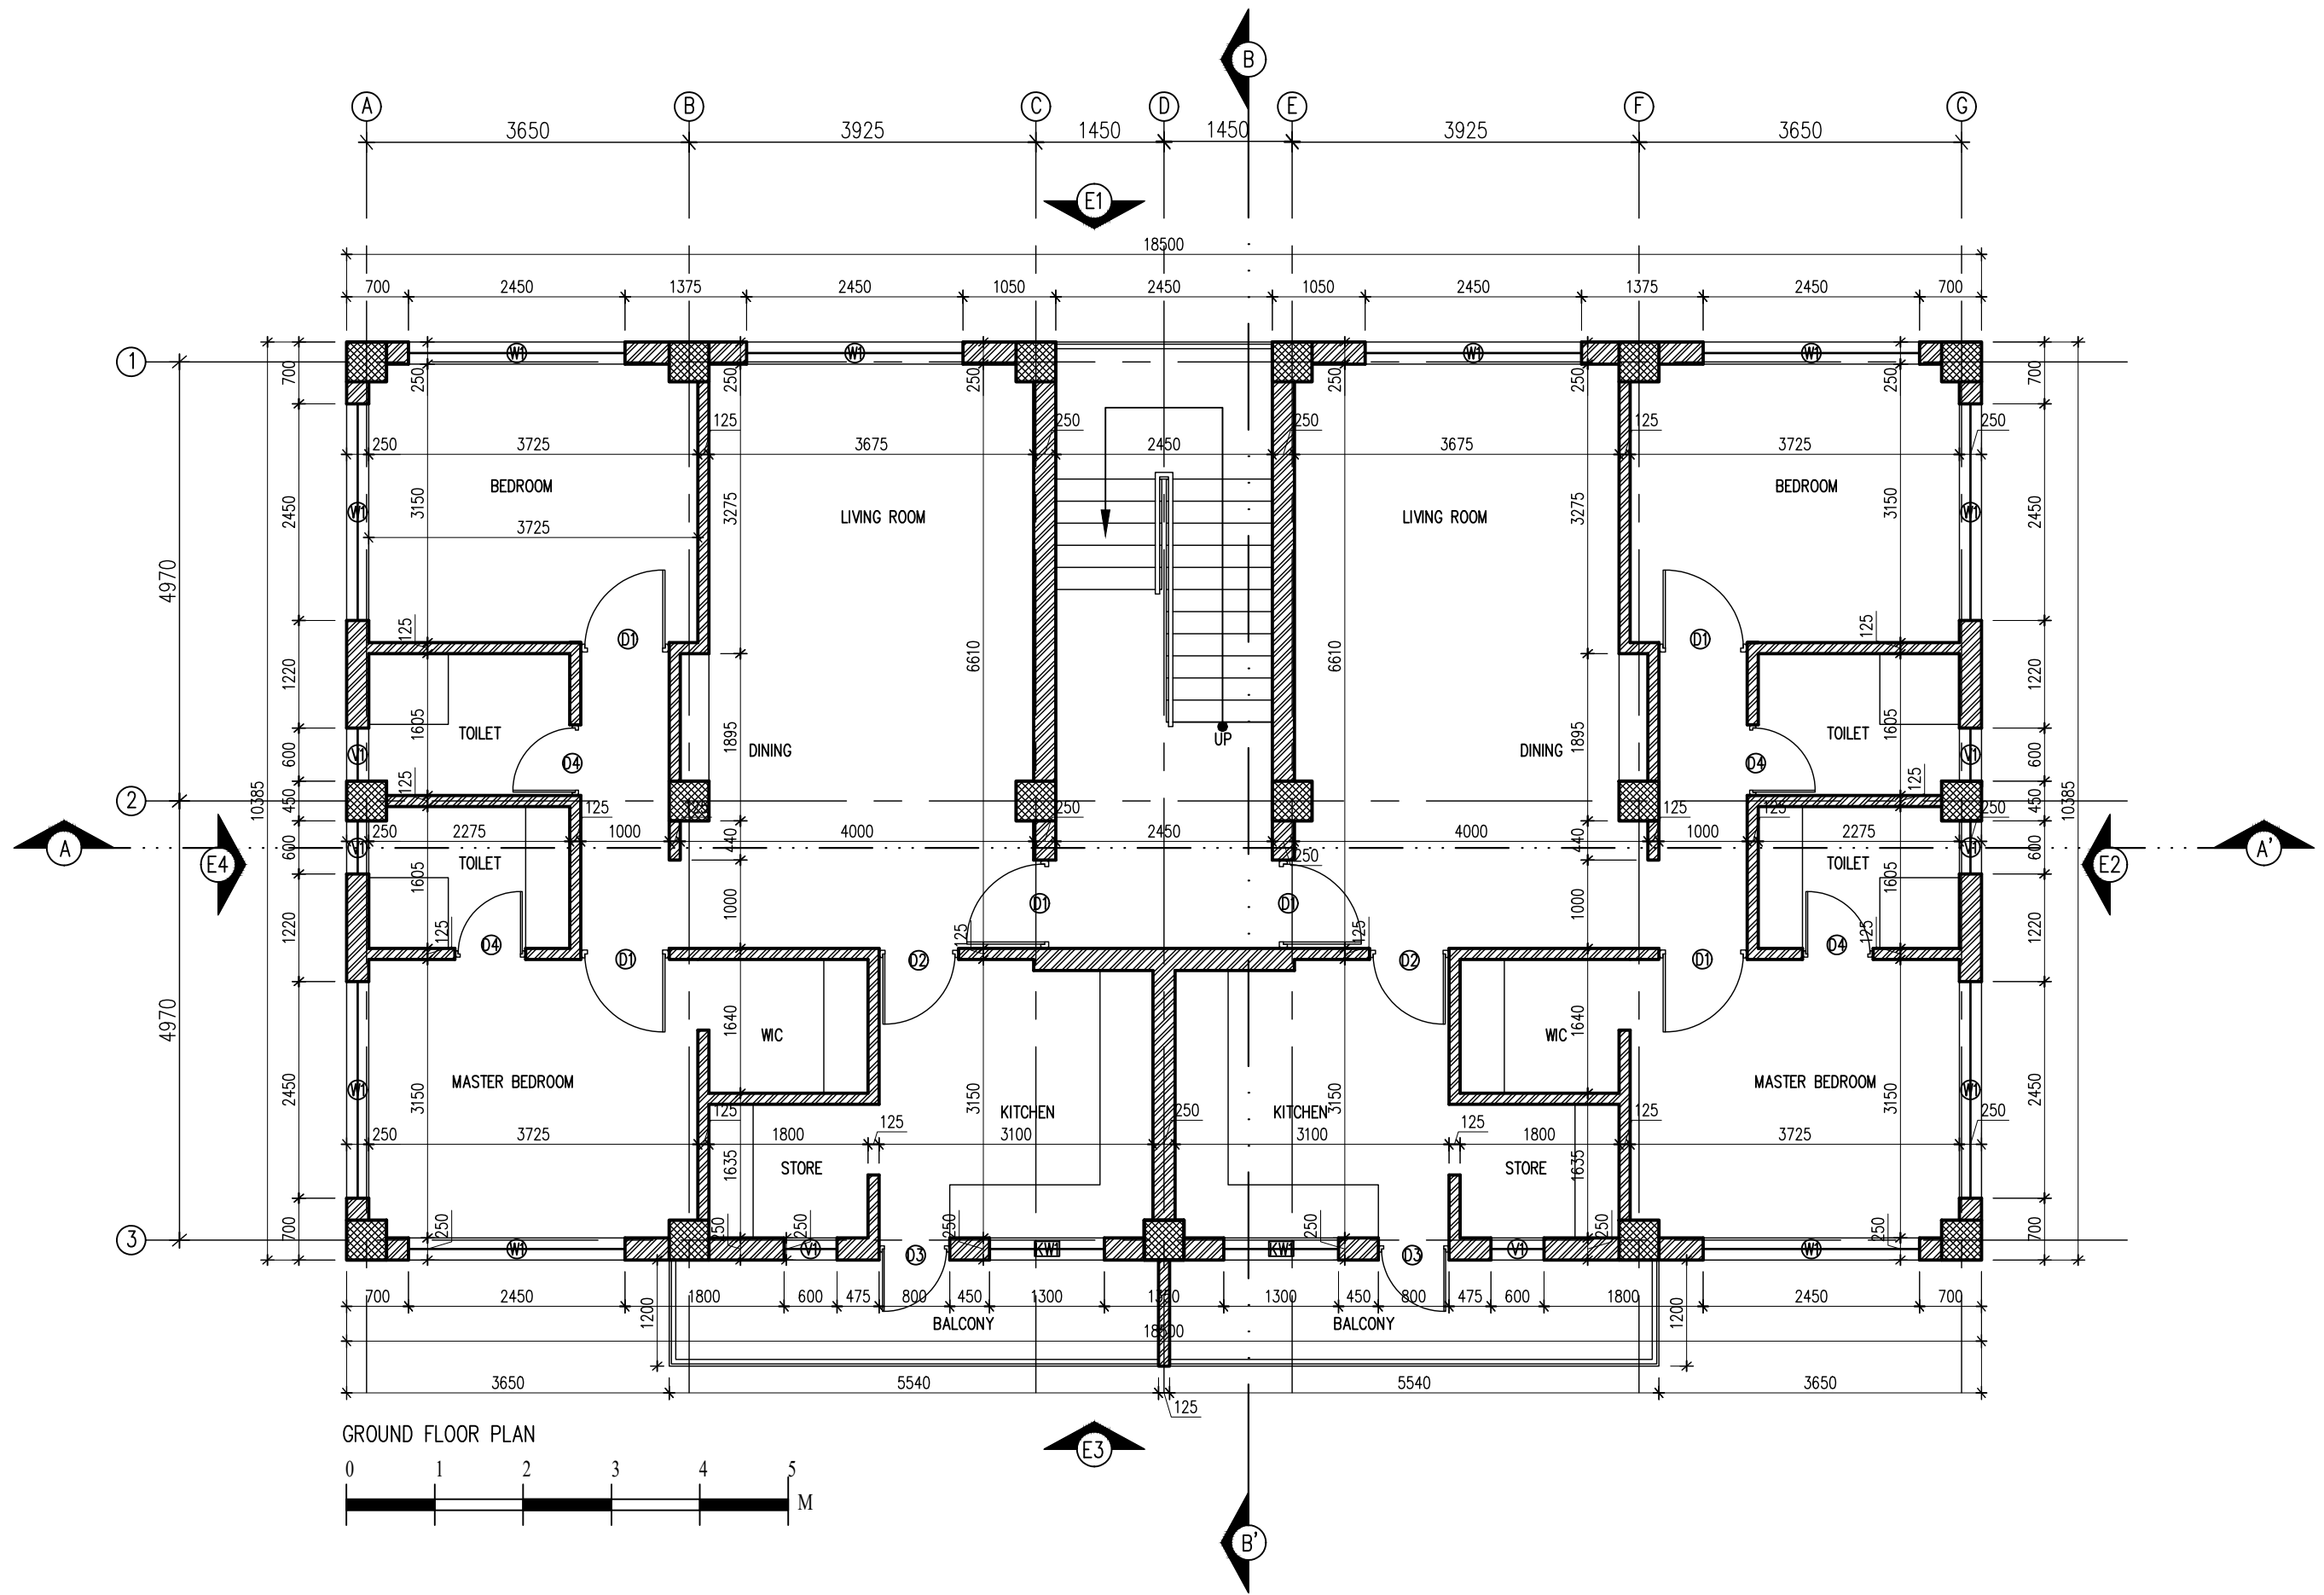

DRAWING NO.
BPC/TD/TMD/NANGKOR/ARCH


DWG # 02






GROUND FLOOR PLAN

0 1 2 3 4 5 M

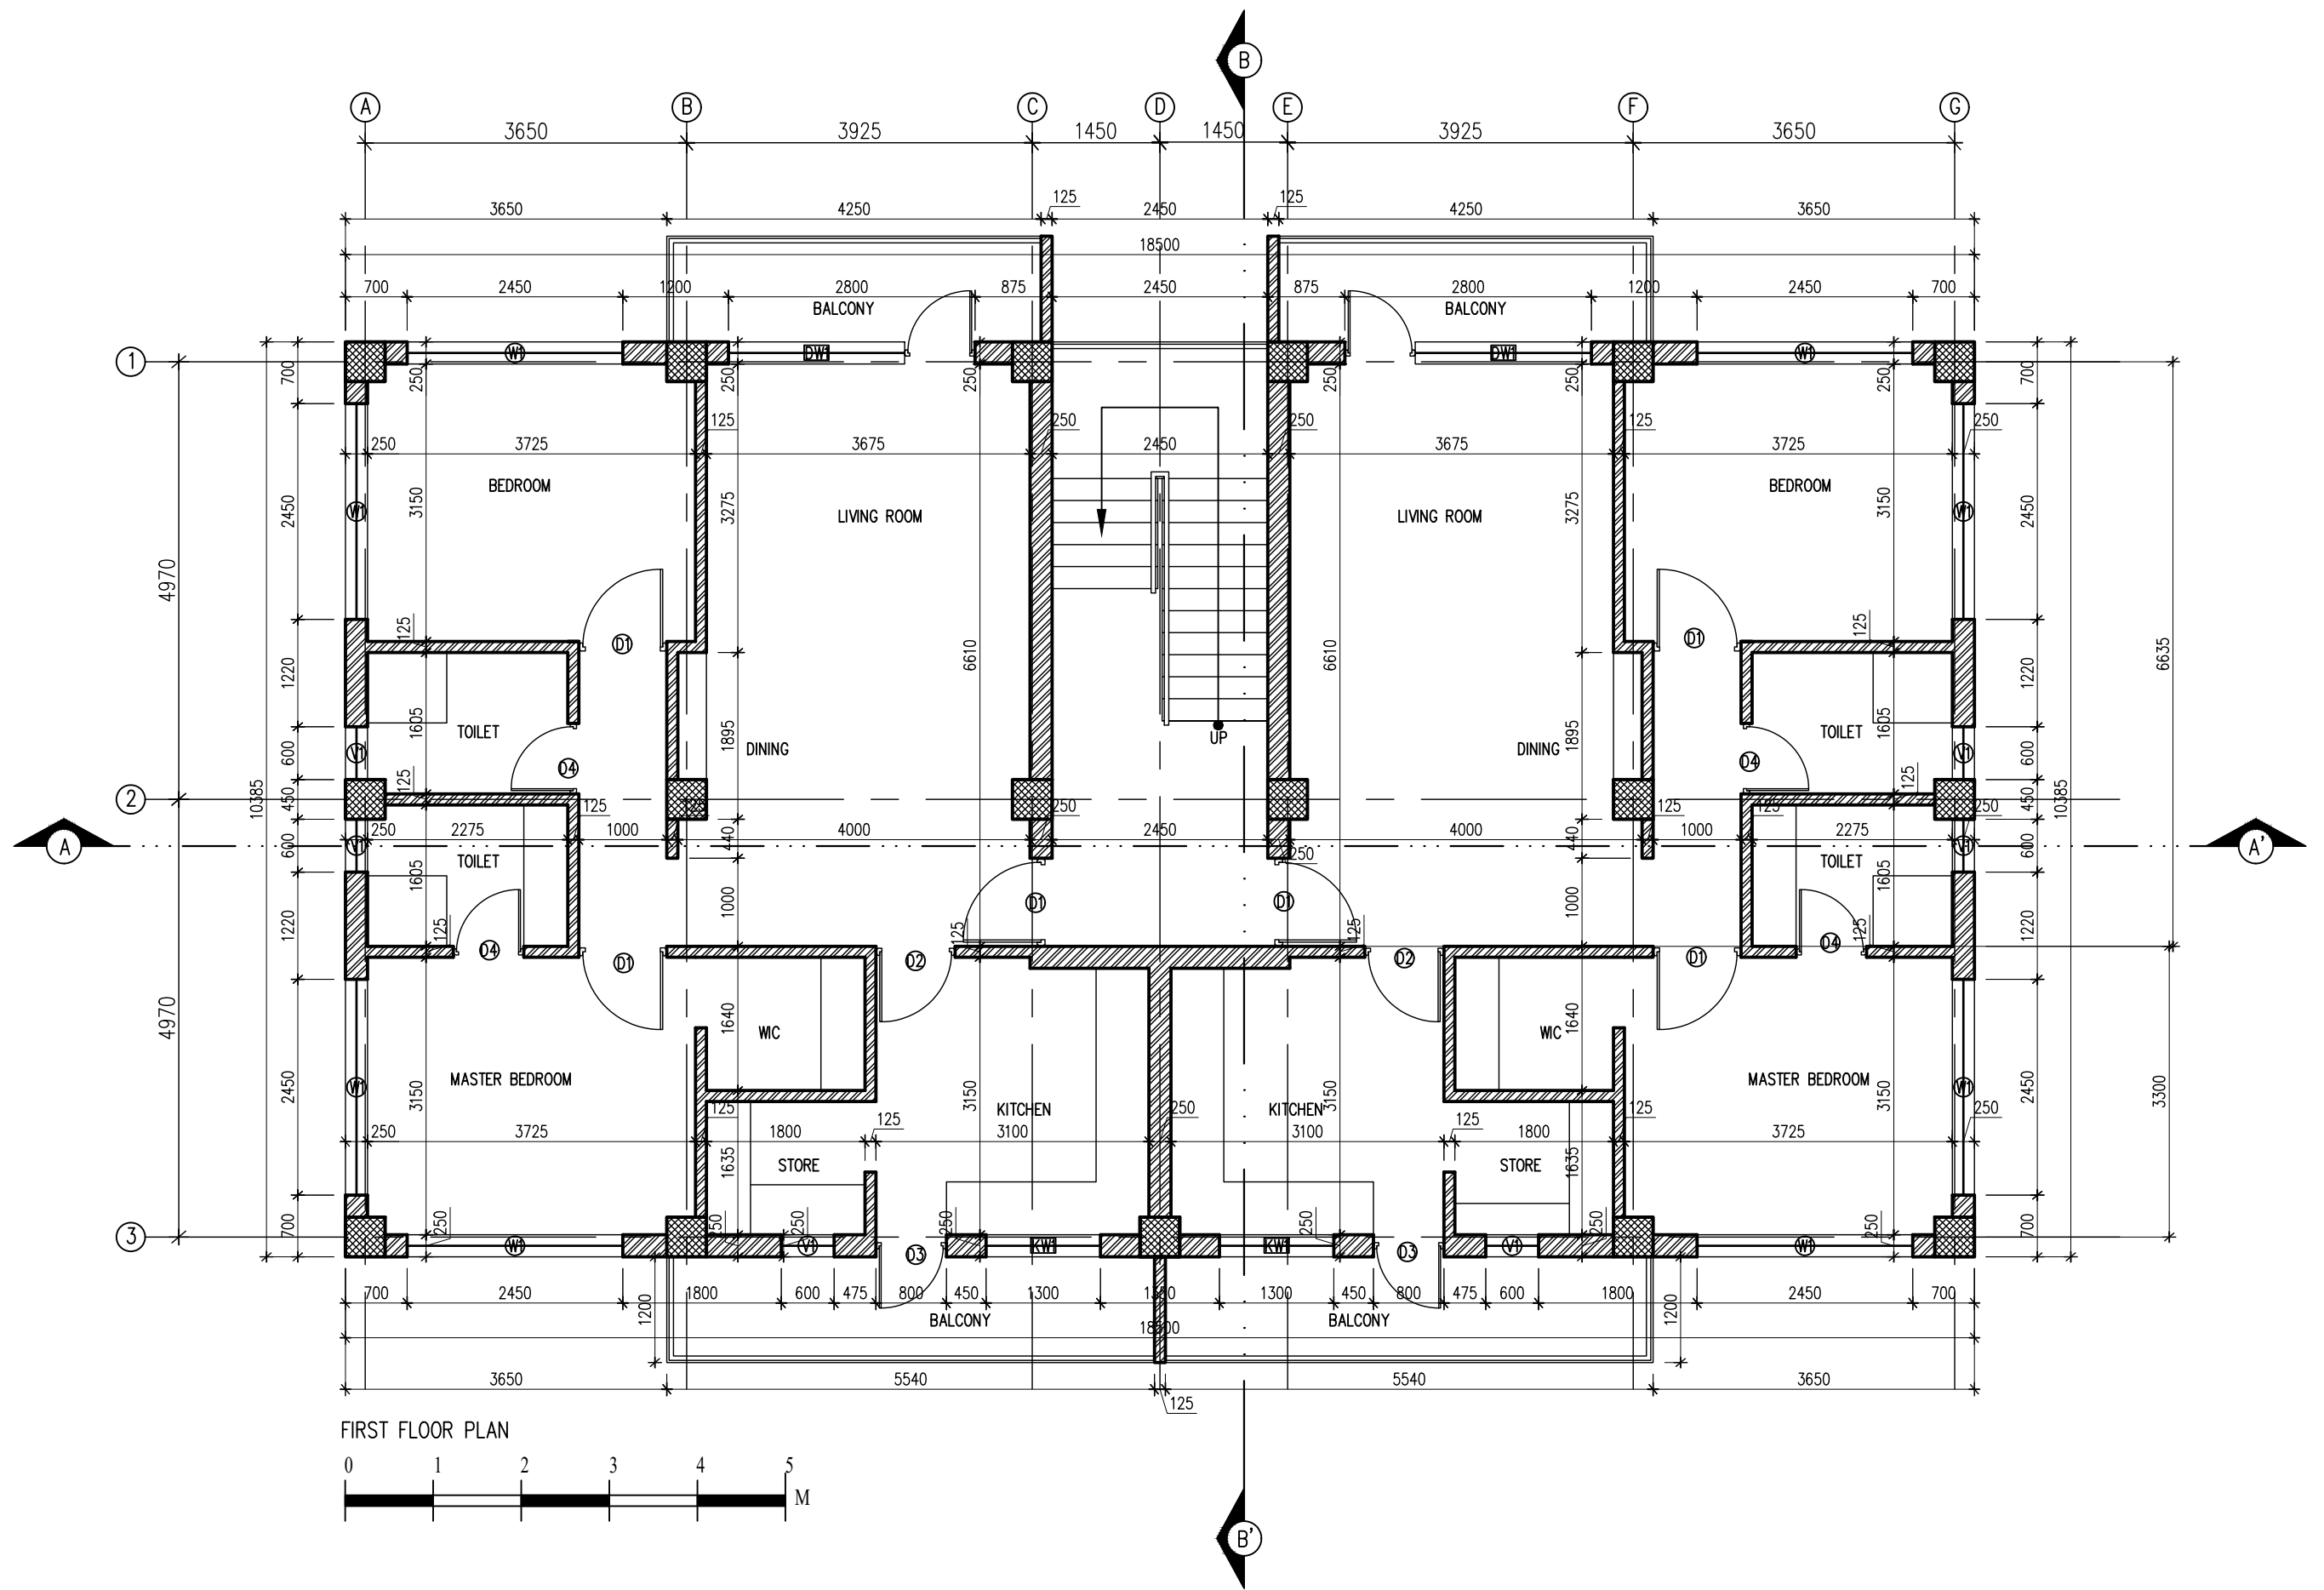 BHUTAN POWER CORPORATION LIMITED TRANSMISSION DEPARTMENT	PROJECT TITLE		REFERENCE NOTES		APPROVED BY	DESIGNED BY	DRAWING TITLE		DRAWING NO.
	DESIGN OF STAFF QUARTER (G+2) AT TSHENKHARI, NANGLAM		1. ALL MEASUREMENTS IN THE DRAWING ARE IN mm UNLESS AND OTHERWISE MENTIONED 2. THE MEASUREMENTS IN THE DRAWING ARE TO BE READ AND NOT MEASURED 3. ANY DISCREPANCY IN THE DRAWING SHALL BE IMMEDIATELY BROUGHT TO THE NOTICE OF THE DESIGNER				REFER DRAWING		BPC/TD/TMD/NANGKOR/ARCH
	DRAWING STATUS	APPROVAL <input type="checkbox"/> APPROVED <input type="checkbox"/>			KUNZANG TOBGYE GENERAL MANAGER TD, BPC	SAILESH PUMAGAI ARCHITECT BA-141 (P)	SCALE 1:75	DATE FEBRUARY, 2022	DWG # 03




	BHUTAN POWER CORPORATION LIMITED TRANSMISSION DEPARTMENT	PROJECT TITLE		REFERENCE NOTES		APPROVED BY	DESIGNED BY	DRAWING TITLE		DRAWING NO.
		DESIGN OF STAFF QUARTER (G+2) AT TSHENKHARI, NANGLAM		1. ALL MEASUREMENTS IN THE DRAWING ARE IN mm UNLESS AND OTHERWISE MENTIONED 2. THE MEASUREMENTS IN THE DRAWING ARE TO BE READ AND NOT MEASURED 3. ANY DISCREPANCY IN THE DRAWING SHALL BE IMMEDIATELY BROUGHT TO THE NOTICE OF THE DESIGNER				REFER DRAWING		BPC/TD/TMD/NANGKOR/ARCH
		DRAWING STATUS	APPROVAL <input type="checkbox"/> APPROVED <input type="checkbox"/>			KUNZANG TOBGYE GENERAL MANAGER TD, BPC	SAILESH JOMAGAI ARCHITECT BA-141 (P)	SCALE 1:75	DATE FEBRUARY, 2022	DWG # 04

 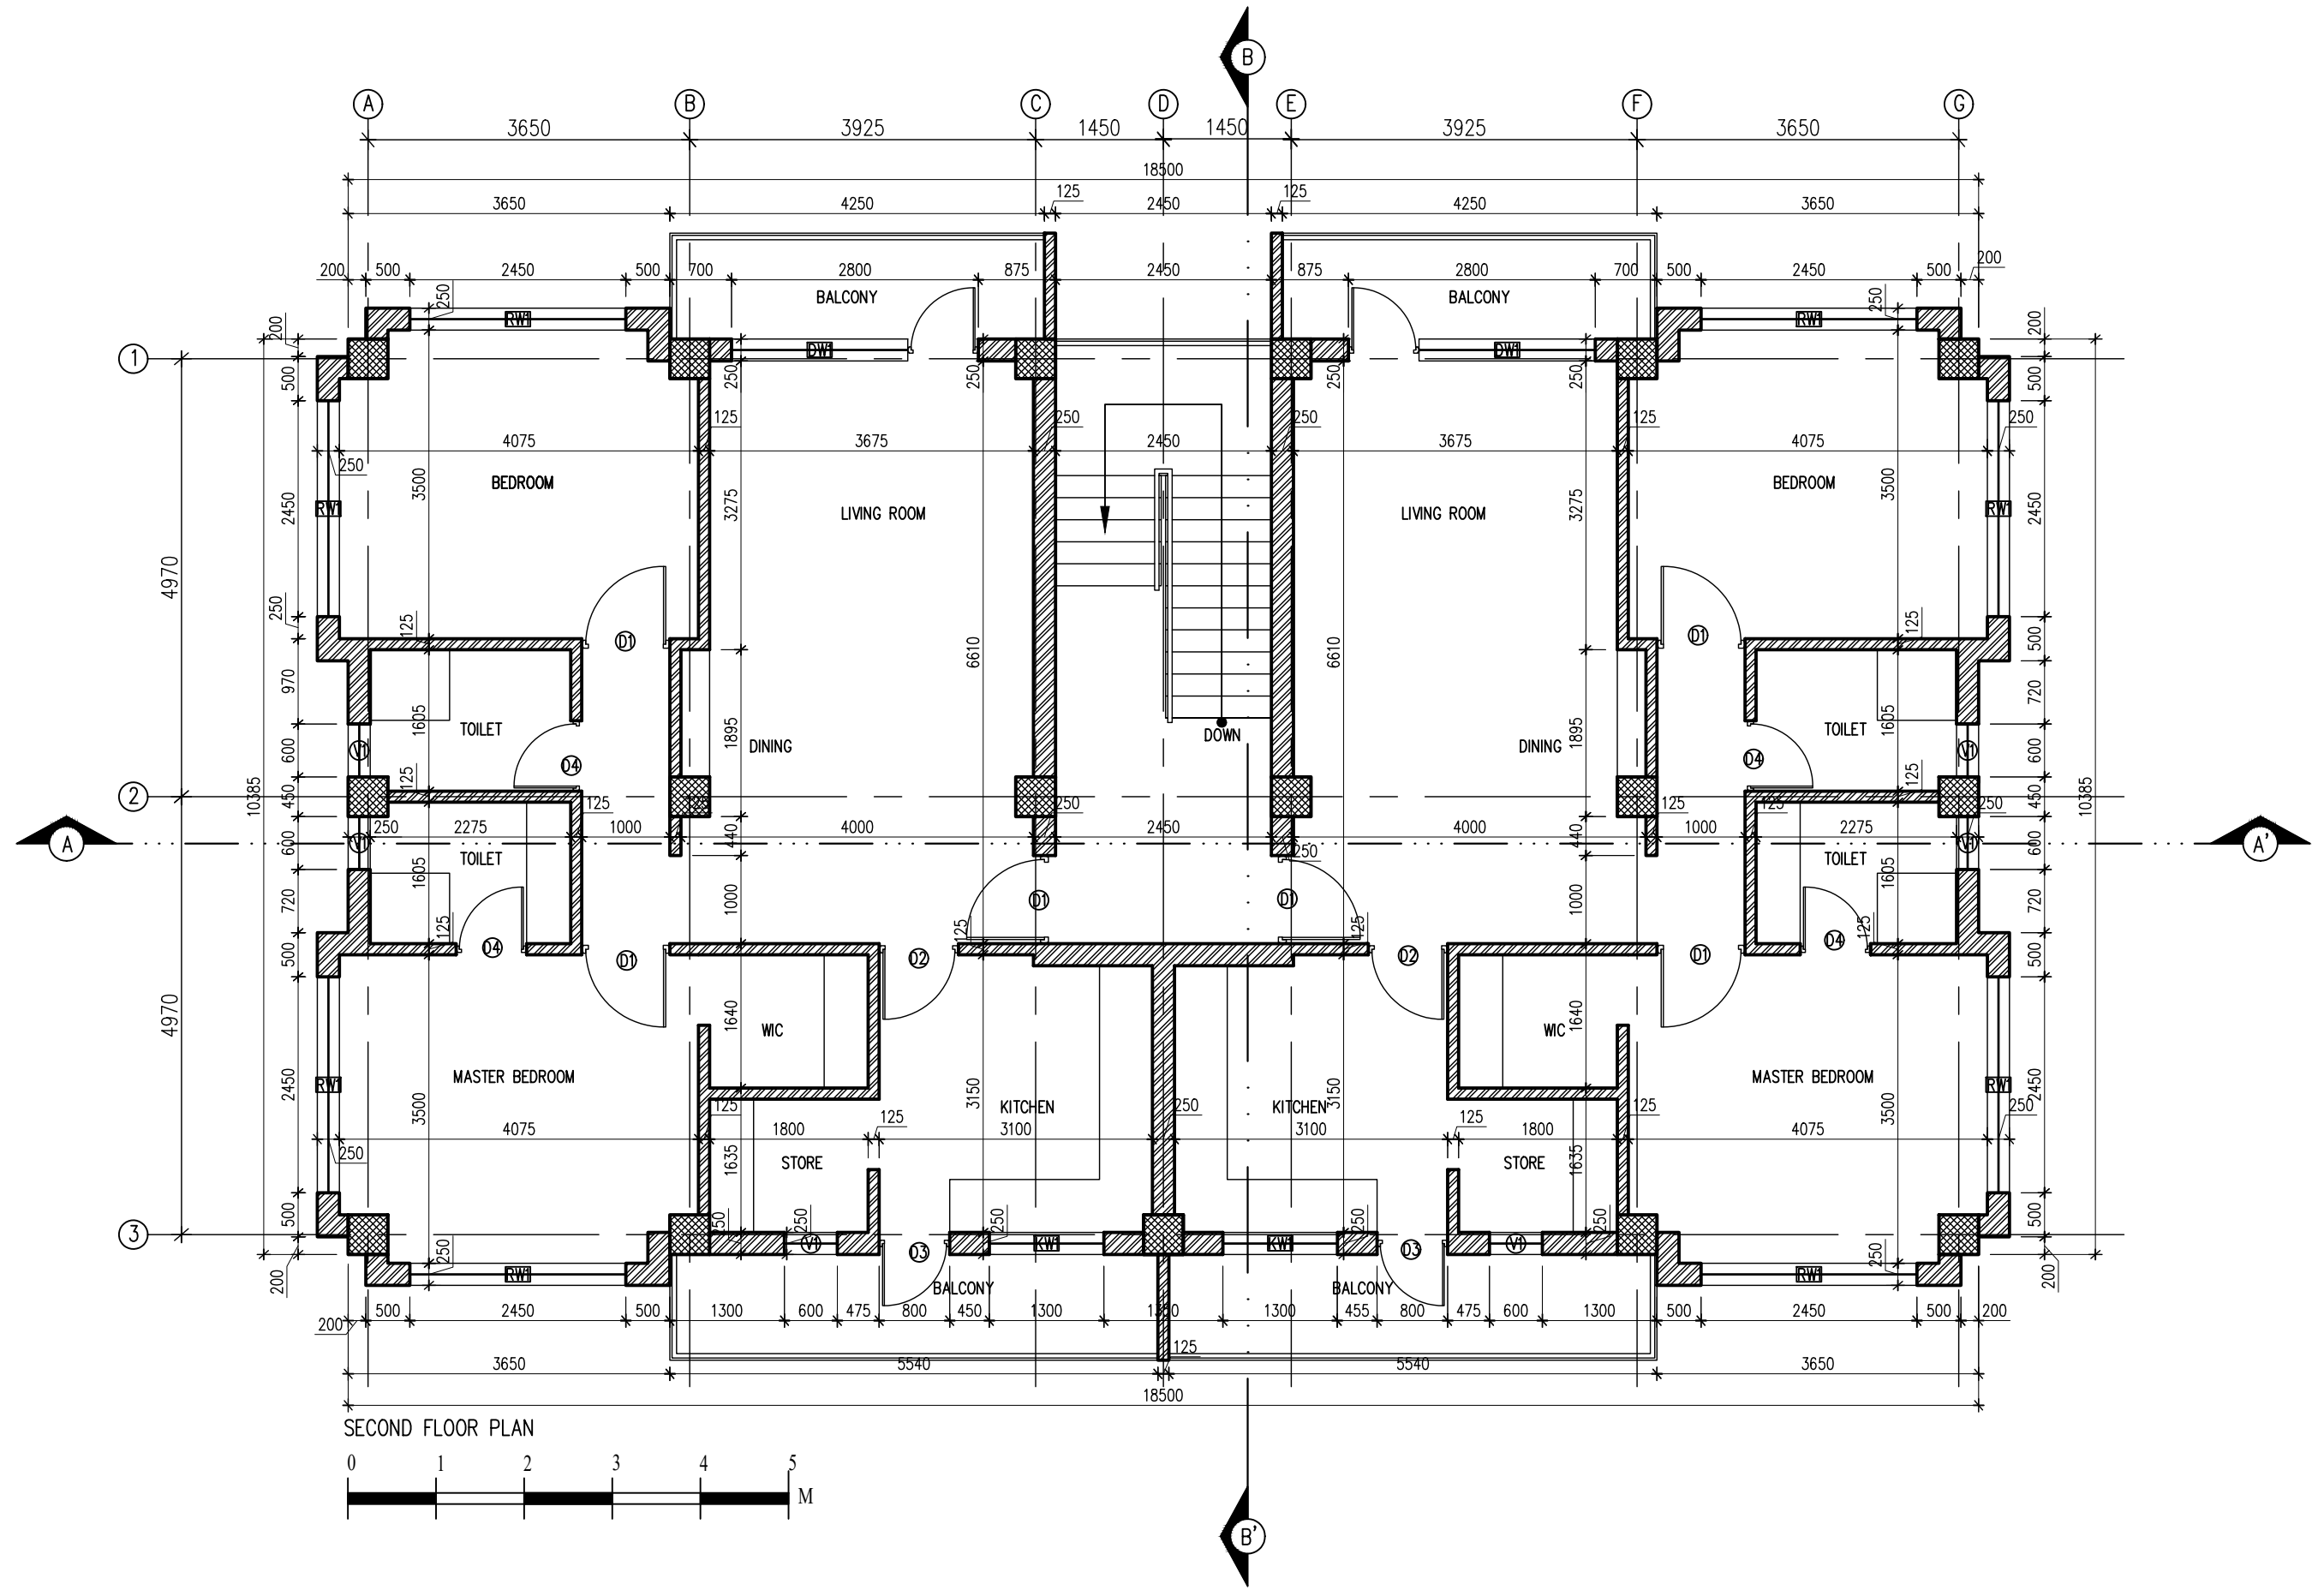


BHUTAN POWER CORPORATION LIMITED
TRANSMISSION DEPARTMENT


PROJECT TITLE			REFERENCE NOTES		APPROVED BY	DESIGNED BY	DRAWING TITLE		DRAWING NO.
DESIGN OF STAFF QUARTER (G+2) AT TSHENKHARI, NANGLAM			1. ALL MEASUREMENTS IN THE DRAWING ARE IN mm UNLESS AND OTHERWISE MENTIONED				REFER DRAWING		BPC/TD/TMD/NANGKOR/ARCH
			2. THE MEASUREMENTS IN THE DRAWING ARE TO BE READ AND NOT MEASURED				SCALE		
			3. ANY DISCREPANCY IN THE DRAWING SHALL BE IMMEDIATELY BROUGHT TO THE NOTICE OF THE DESIGNER		KUNZANG TOBGYE GENERAL MANAGER TD, BPC	SAILISH HUMAGAI ARCHITECT BA-141 (P)	DATE		
DRAWING STATUS	APPROVAL	APPROVED					1:75	FEBRUARY, 2022	DWG # 05

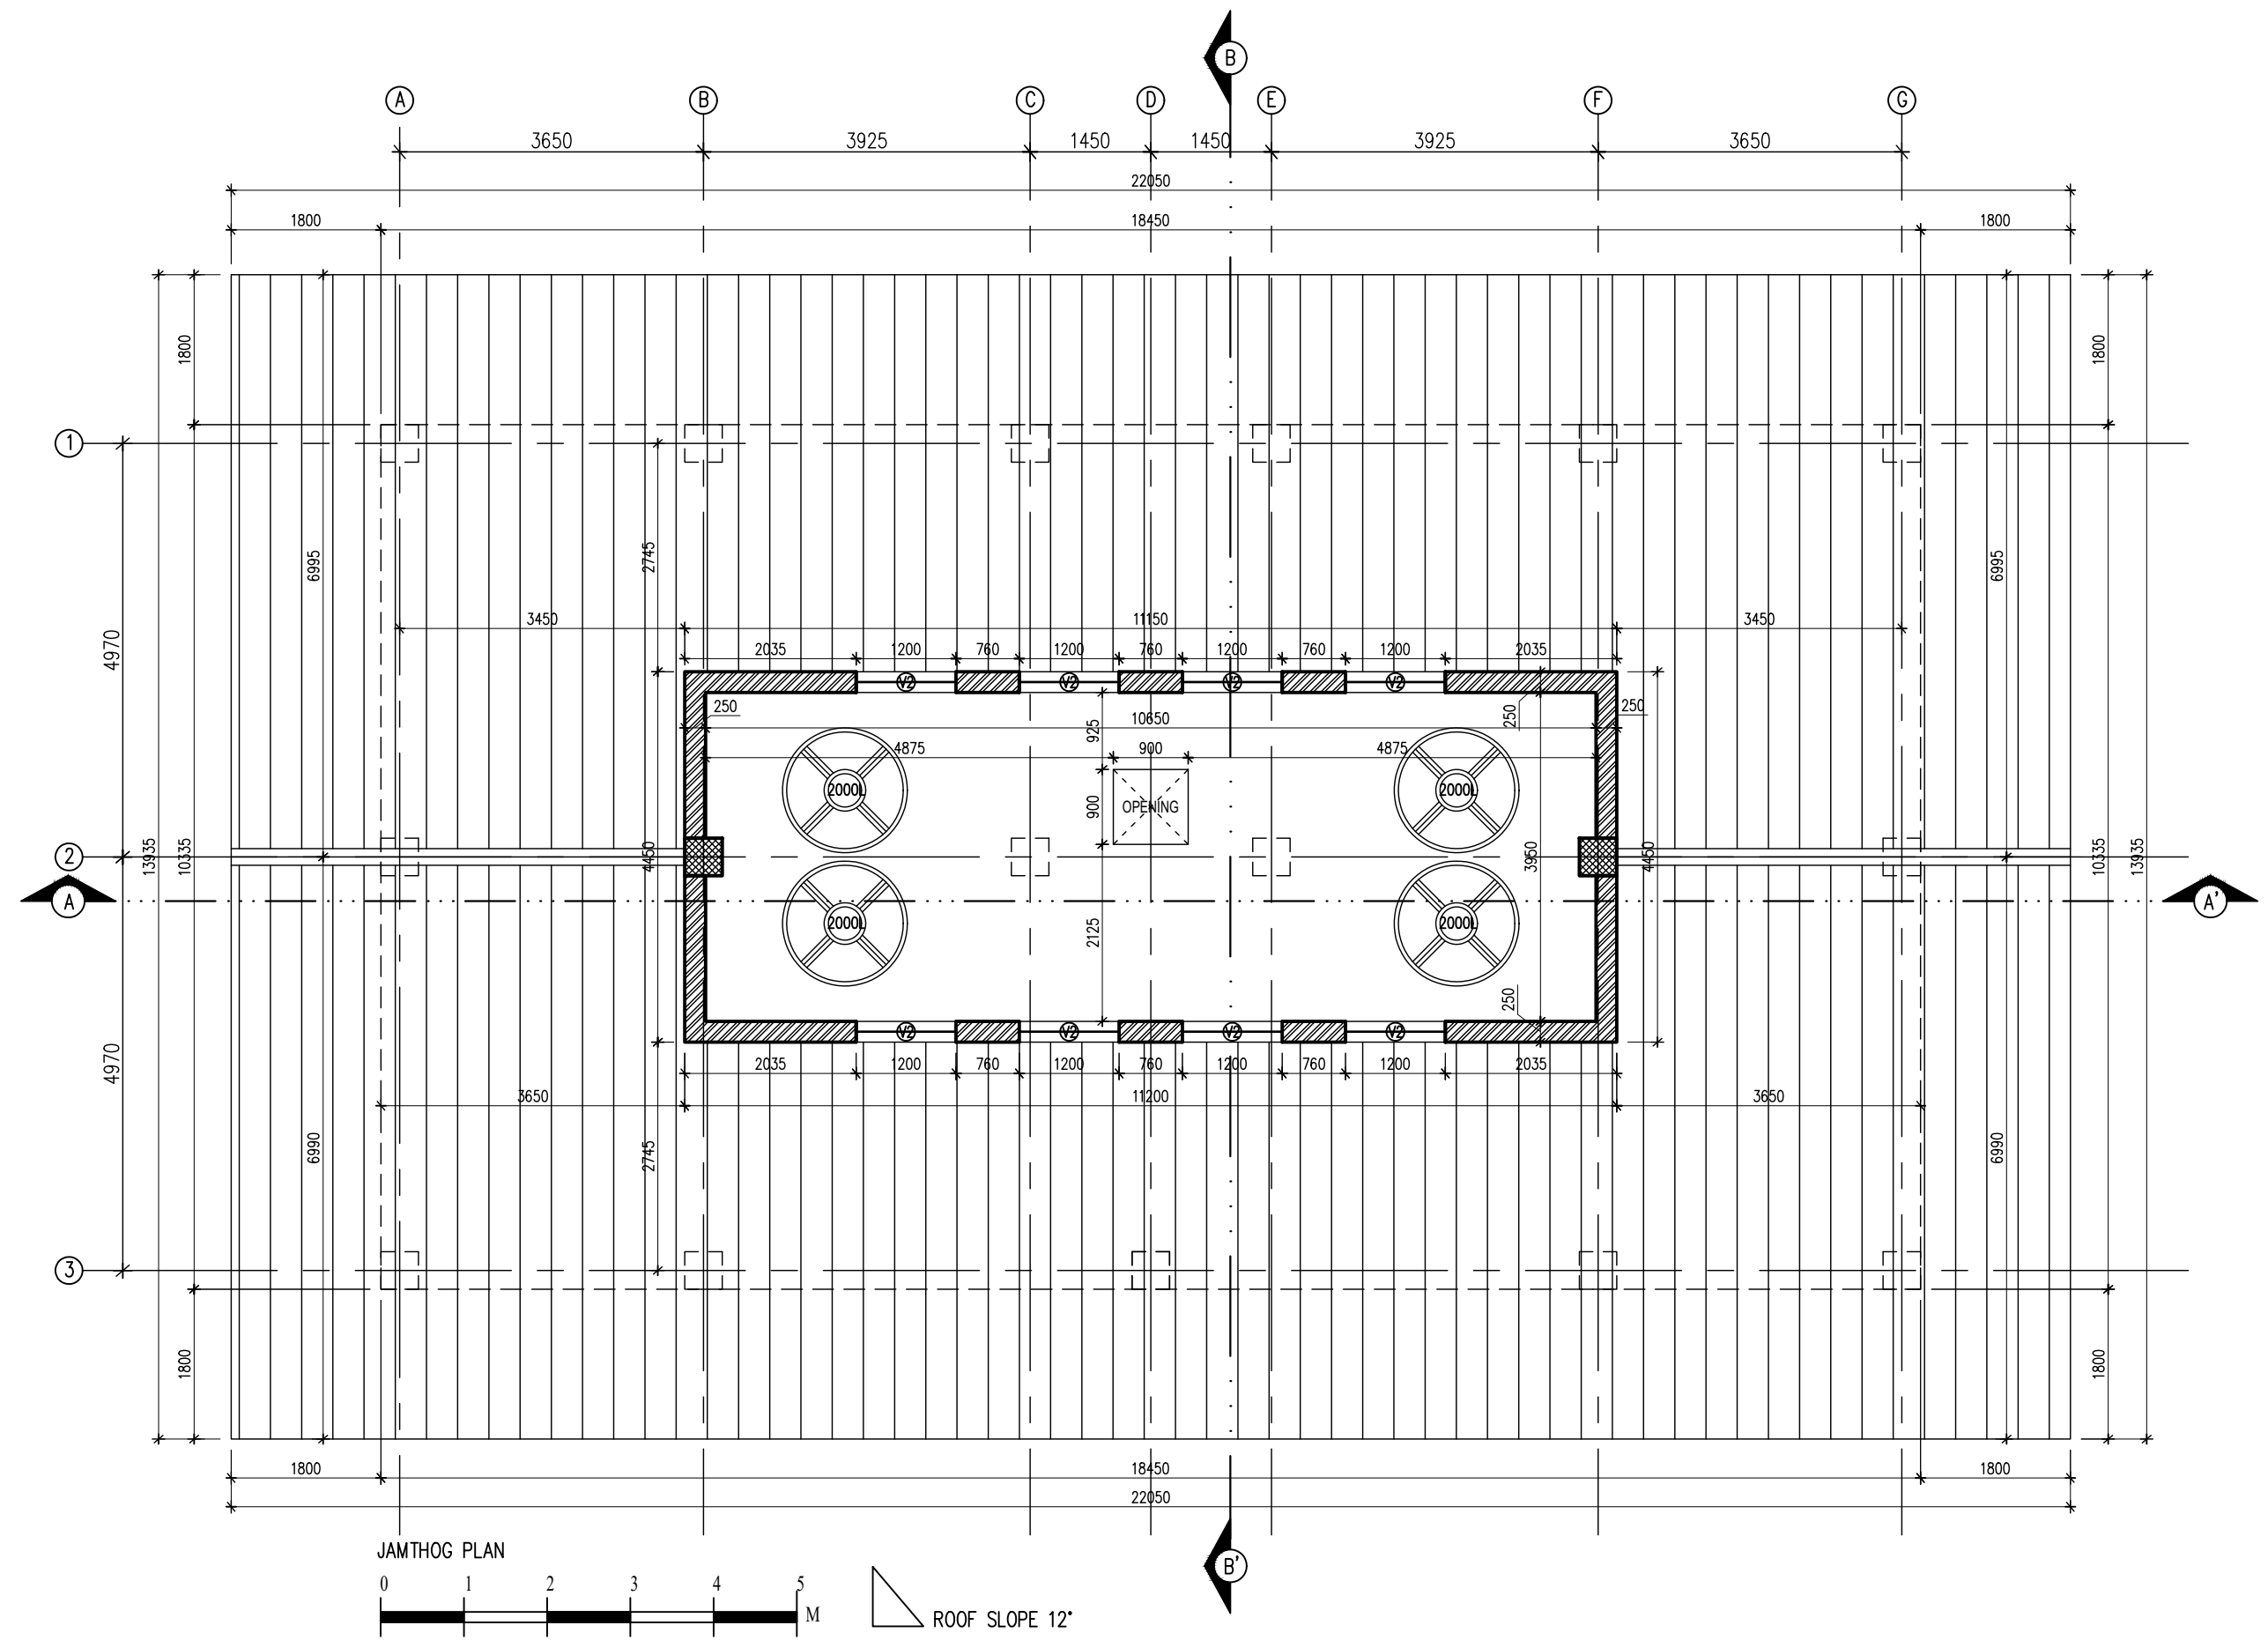




BHUTAN POWER CORPORATION LIMITED
TRANSMISSION DEPARTMENT

PROJECT TITLE				REFERENCE NOTES		APPROVED BY	DESIGNED BY	DRAWING TITLE		DRAWING NO.
DESIGN OF STAFF QUARTER (G+2) AT TSHENKHARI, NANGLAM				1. ALL MEASUREMENTS IN THE DRAWING ARE IN mm UNLESS AND OTHERWISE MENTIONED			 SAALESH ROMAGAI ARCHITECT BA-141 (P)	REFER DRAWING		BPC/TD/TMD/NANGKOR/ARCH
				2. THE MEASUREMENTS IN THE DRAWING ARE TO BE READ AND NOT MEASURED		KUNZANG TOBGYE GENERAL MANAGER TD, BPC		SCALE	DATE	DWG # 06
				3. ANY DISCREPANCY IN THE DRAWING SHALL BE IMMEDIATELY BROUGHT TO THE NOTICE OF THE DESIGNER				1:75	FEBRUARY, 2022	
DRAWING STATUS	APPROVAL <input type="checkbox"/>	APPROVED <input type="checkbox"/>								

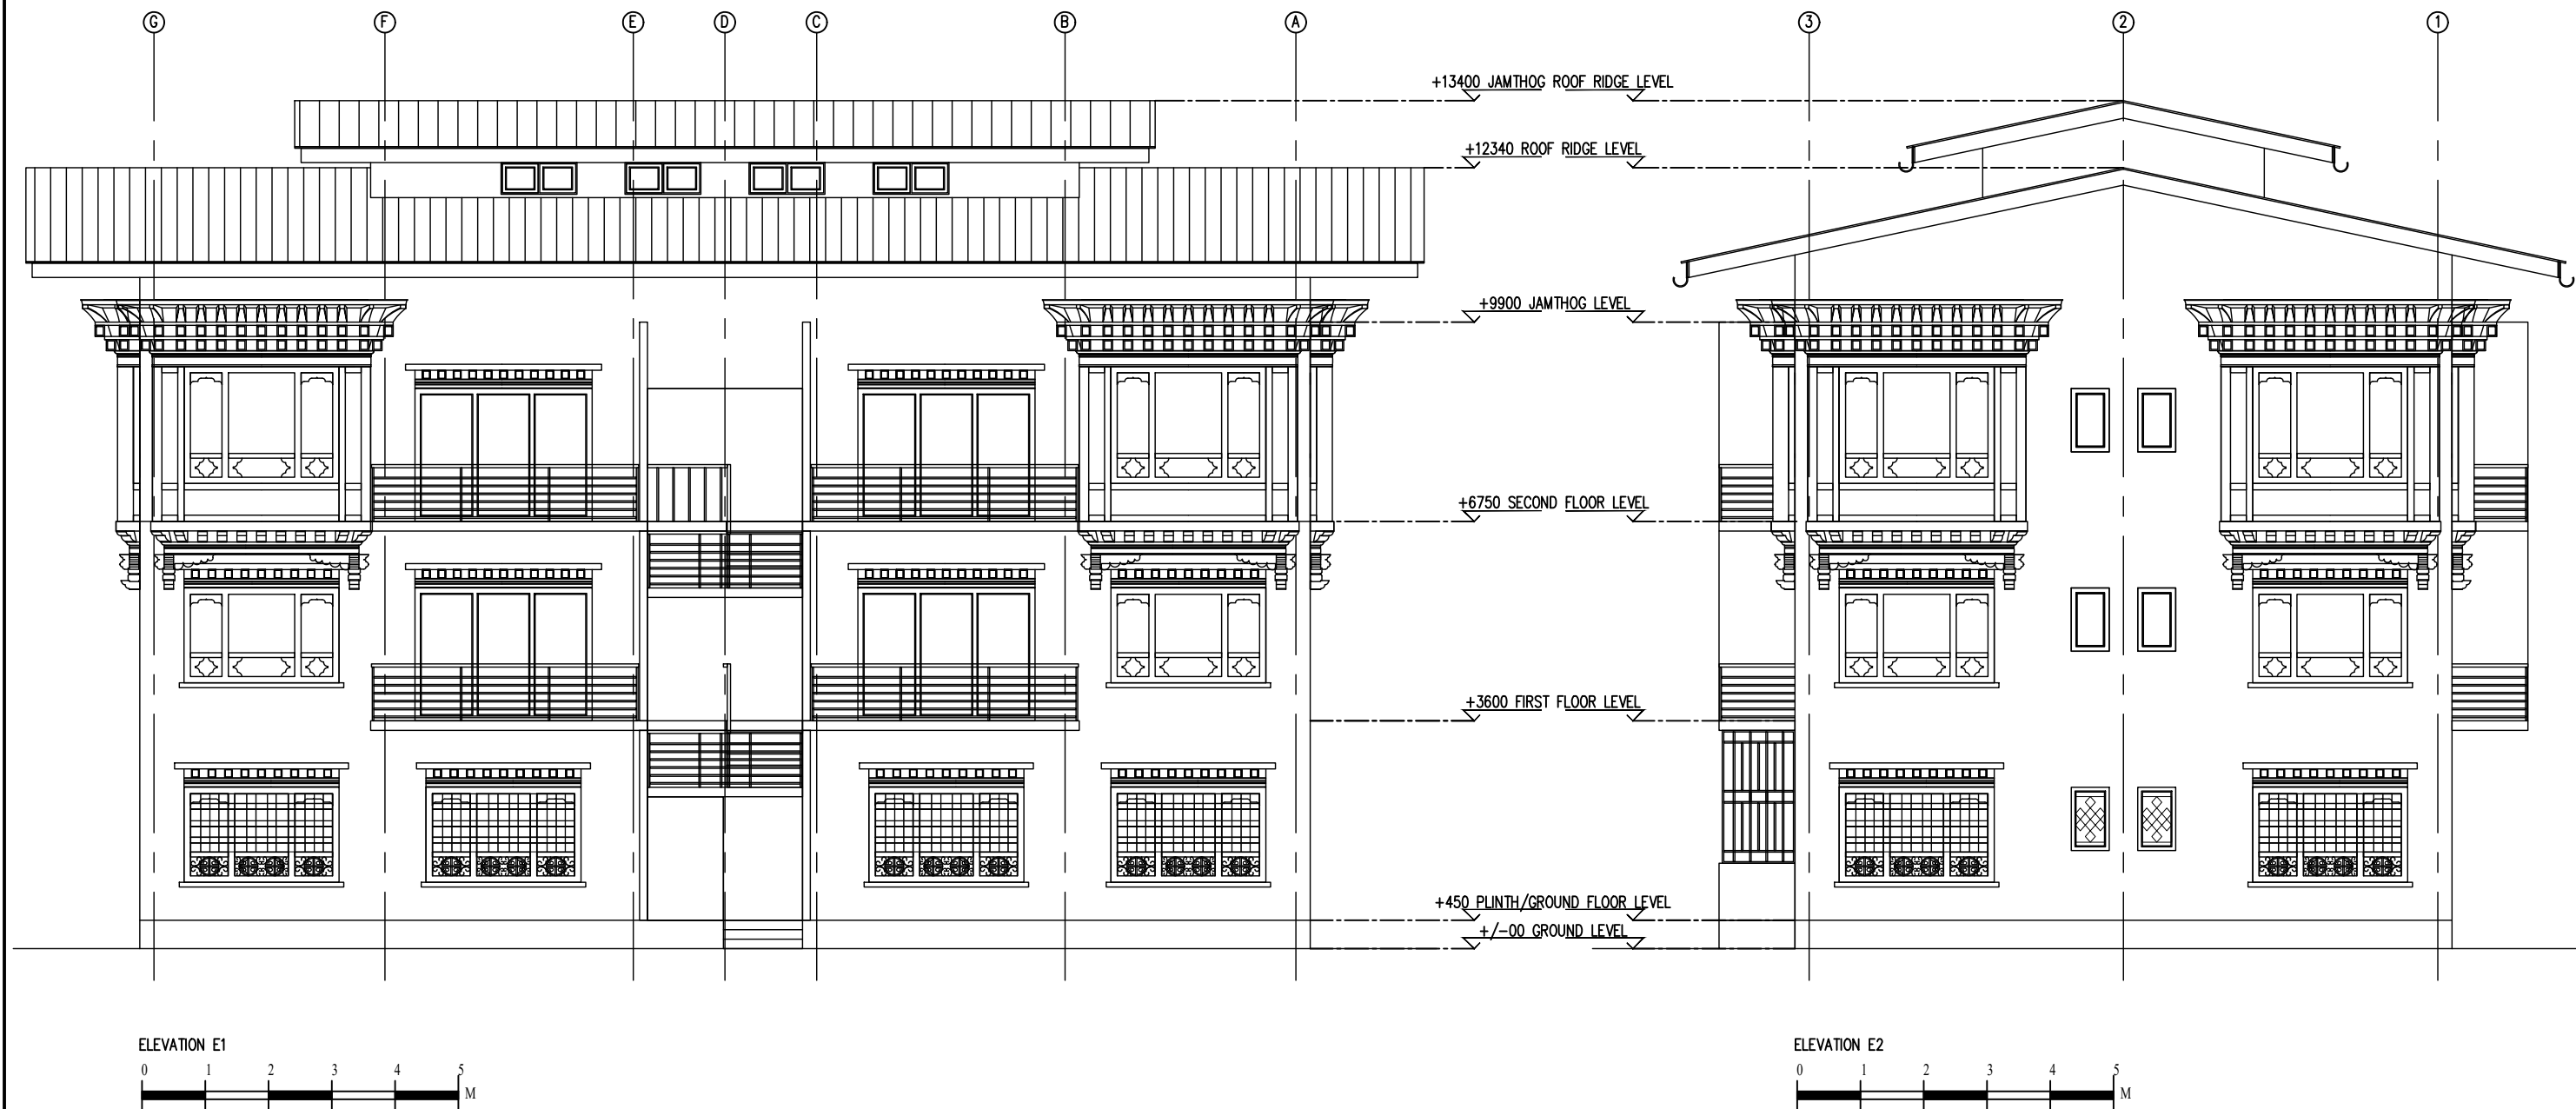DWG # 07



	BHUTAN POWER CORPORATION LIMITED TRANSMISSION DEPARTMENT	PROJECT TITLE		REFERENCE NOTES		APPROVED BY	DESIGNED BY	DRAWING TITLE		DRAWING NO.
		DESIGN OF STAFF QUARTER (G+2) AT TSHENKHARI, NANGLAM		1. ALL MEASUREMENTS IN THE DRAWING ARE IN mm UNLESS AND OTHERWISE MENTIONED			 SAILESH HUMAGAI ARCHITECT BA-141 (P)	REFER DRAWING		BPC/TD/TMD/NANGKOR/ARCH
				2. THE MEASUREMENTS IN THE DRAWING ARE TO BE READ AND NOT MEASURED		KUNZANG TOBGYE GENERAL MANAGER TD, BPC		SCALE	DATE	DWG # 08
		DRAWING STATUS	APPROVAL <input type="checkbox"/>	APPROVED <input type="checkbox"/>	3. ANY DISCREPANCY IN THE DRAWING SHALL BE IMMEDIATELY BROUGHT TO THE NOTICE OF THE DESIGNER			REF DWG	FEBRUARY, 2022	

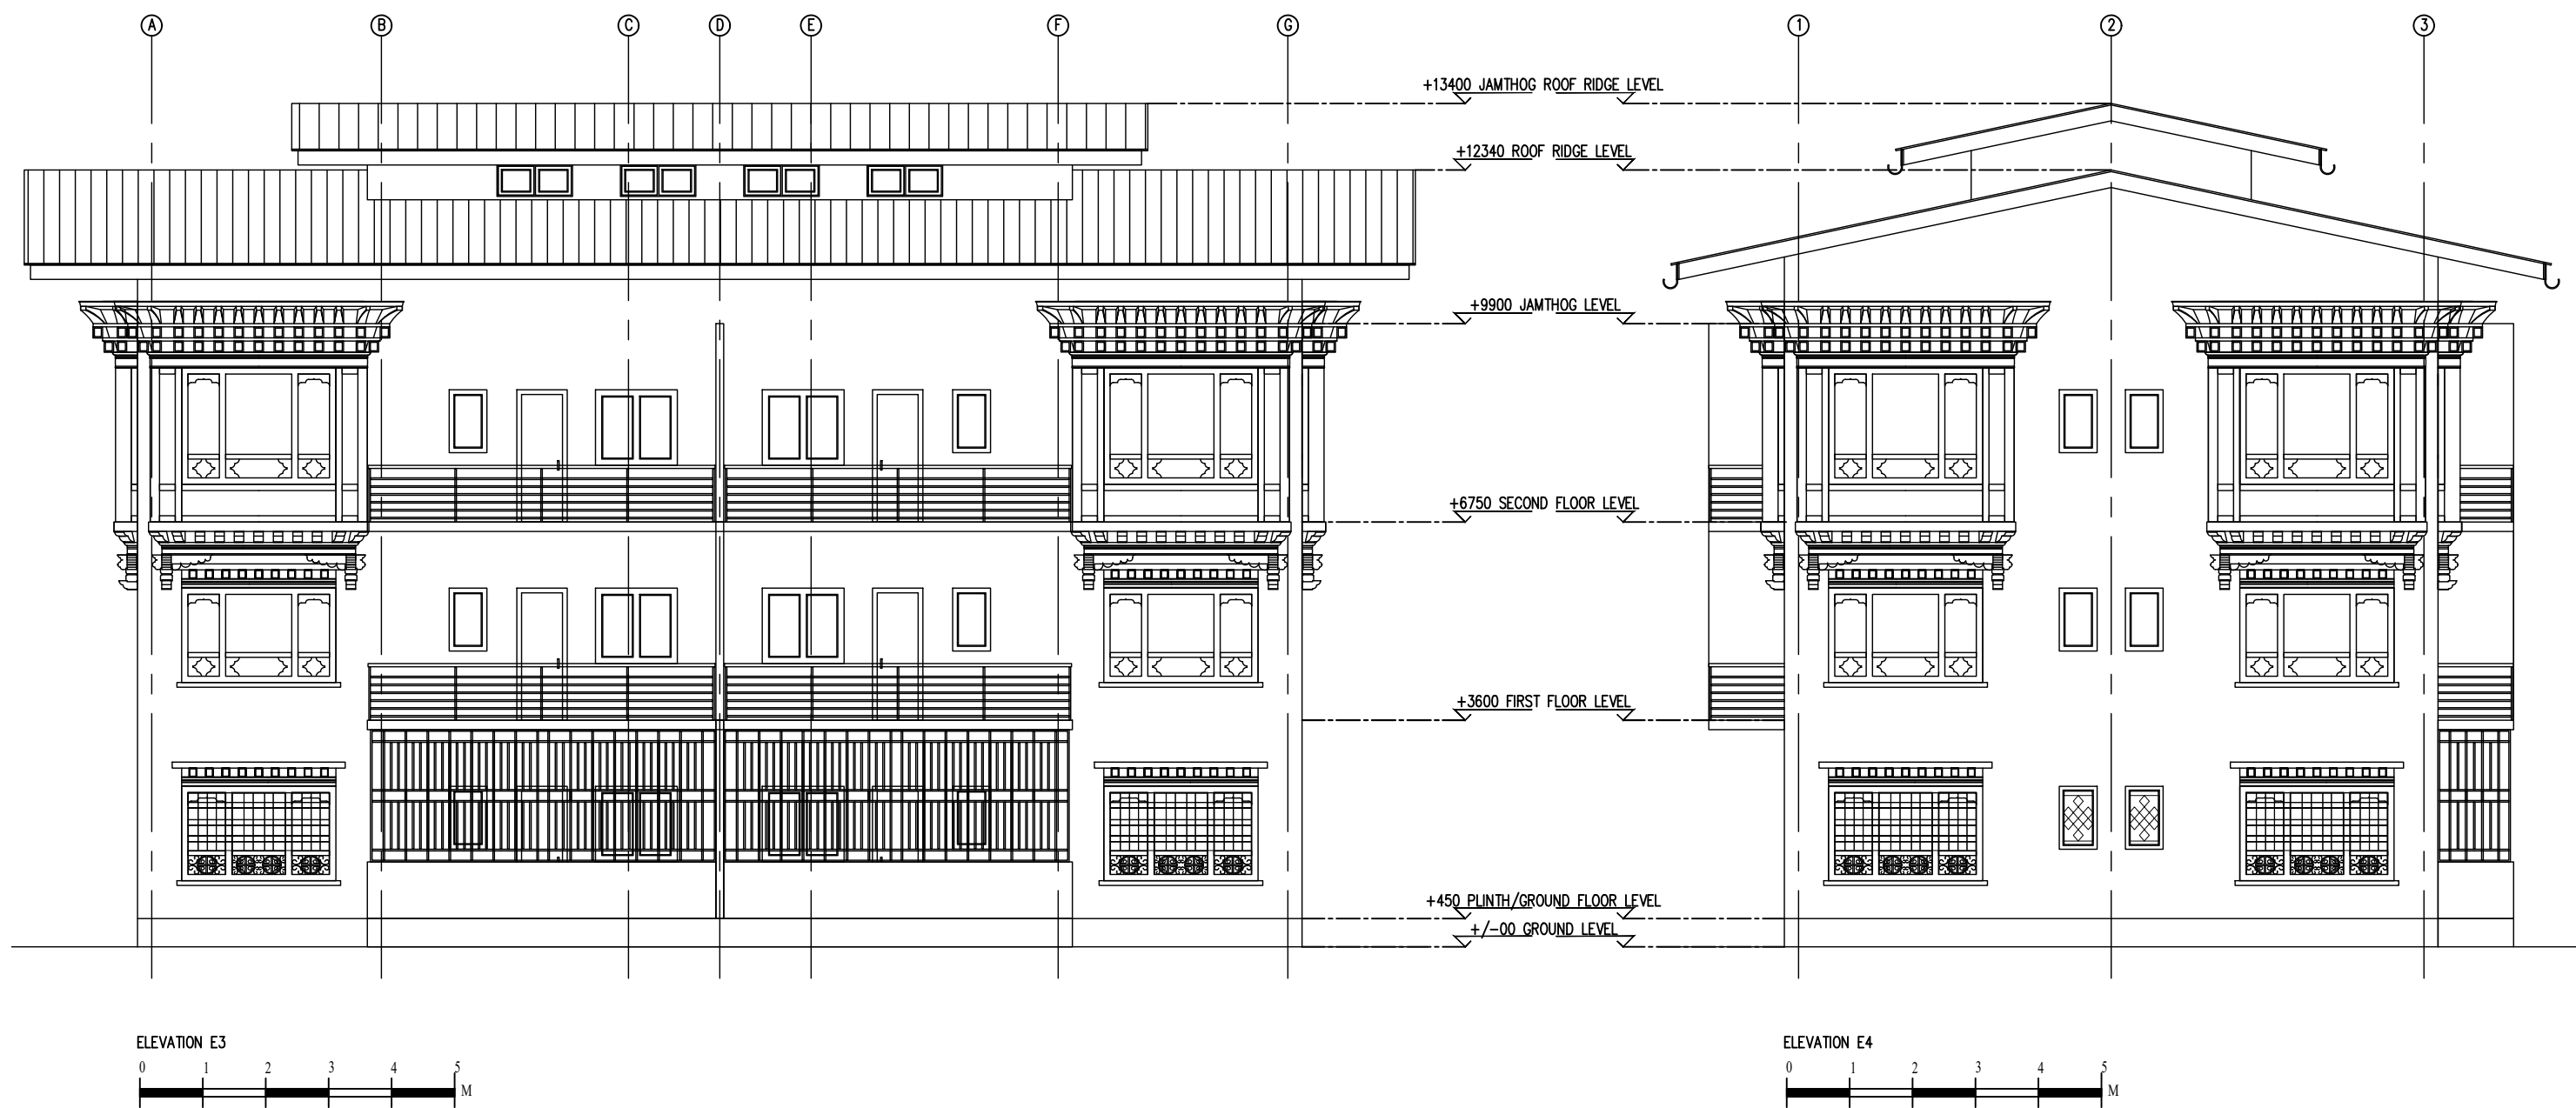

BHUTAN POWER CORPORATION LIMITED

TRANSMISSION DEPARTMENT

PROJECT TITLE

DESIGN OF STAFF QUARTER (G+2) AT TSHENKHARI, NANGLAM

DRAWING STATUS	APPROVAL <input type="checkbox"/>	APPROVED <input type="checkbox"/>
----------------	-----------------------------------	-----------------------------------

REFERENCE NOTES

1. ALL MEASUREMENTS IN THE DRAWING ARE IN mm UNLESS AND OTHERWISE MENTIONED

2. THE MEASUREMENTS IN THE DRAWING ARE TO BE READ AND NOT MEASURED

3. ANY DISCREPANCY IN THE DRAWING SHALL BE IMMEDIATELY BROUGHT TO THE NOTICE OF THE DESIGNER

APPROVED BY

KUNZANG TOBGYE
GENERAL MANAGER
TD, BPC

DESIGNED BY

SAILESH HUMAGAI
ARCHITECT
BA-141 (P)

DRAWING TITLE

REFER DRAWING

SCALE
REF DWG


DATE _____


FEBRUARY, 2022




DRAWING NO.


BPC/TD/TMD/NANGKOR/ARCH

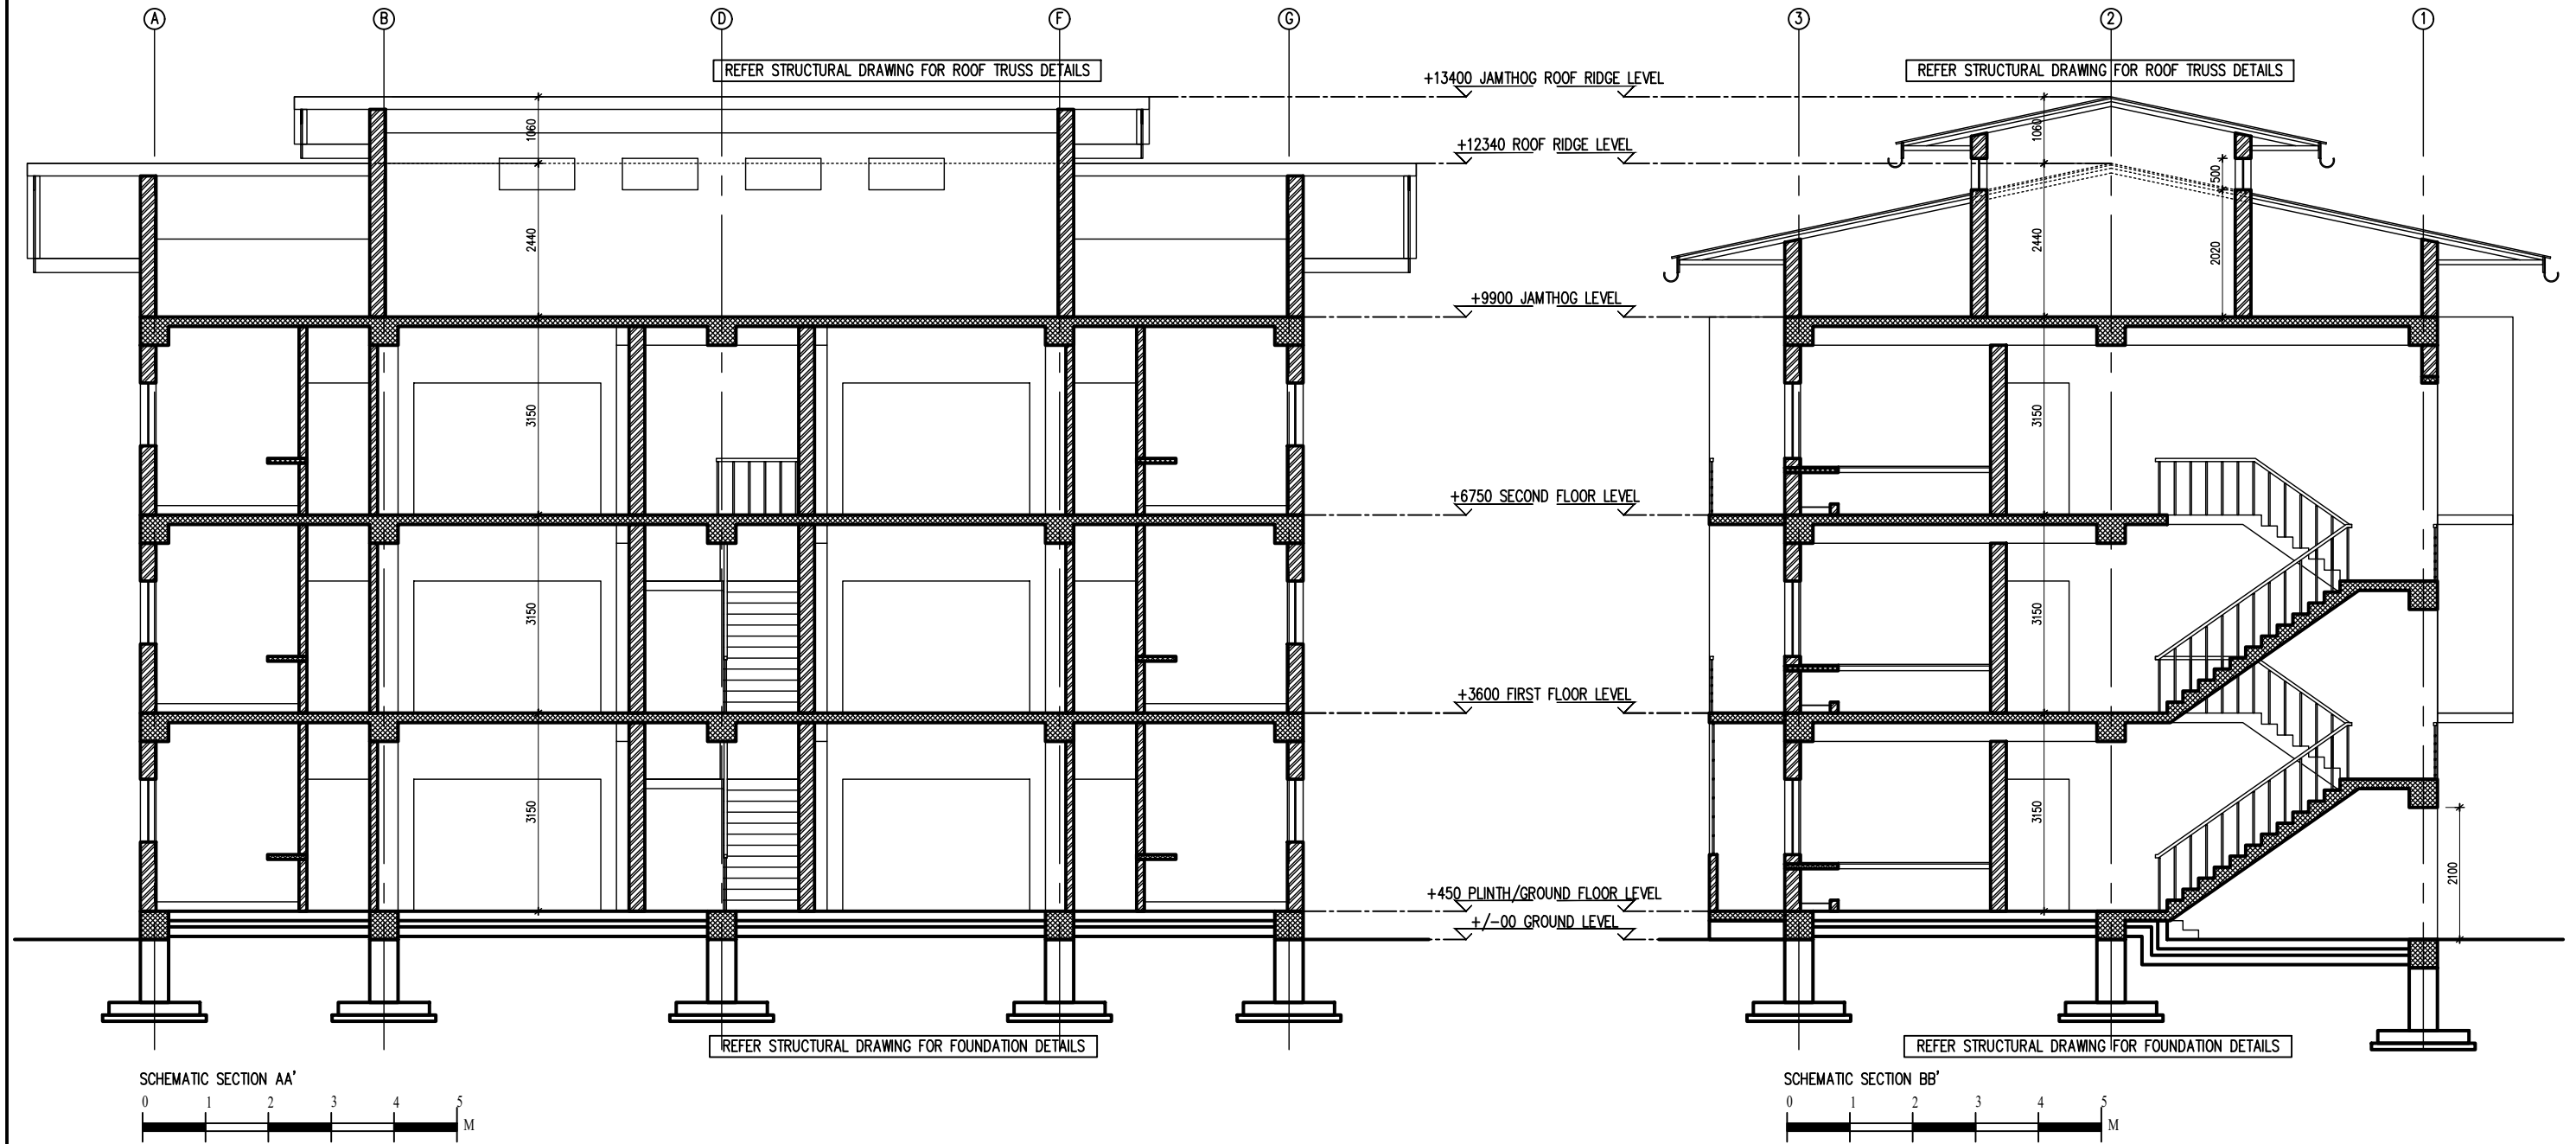

DWG # 09

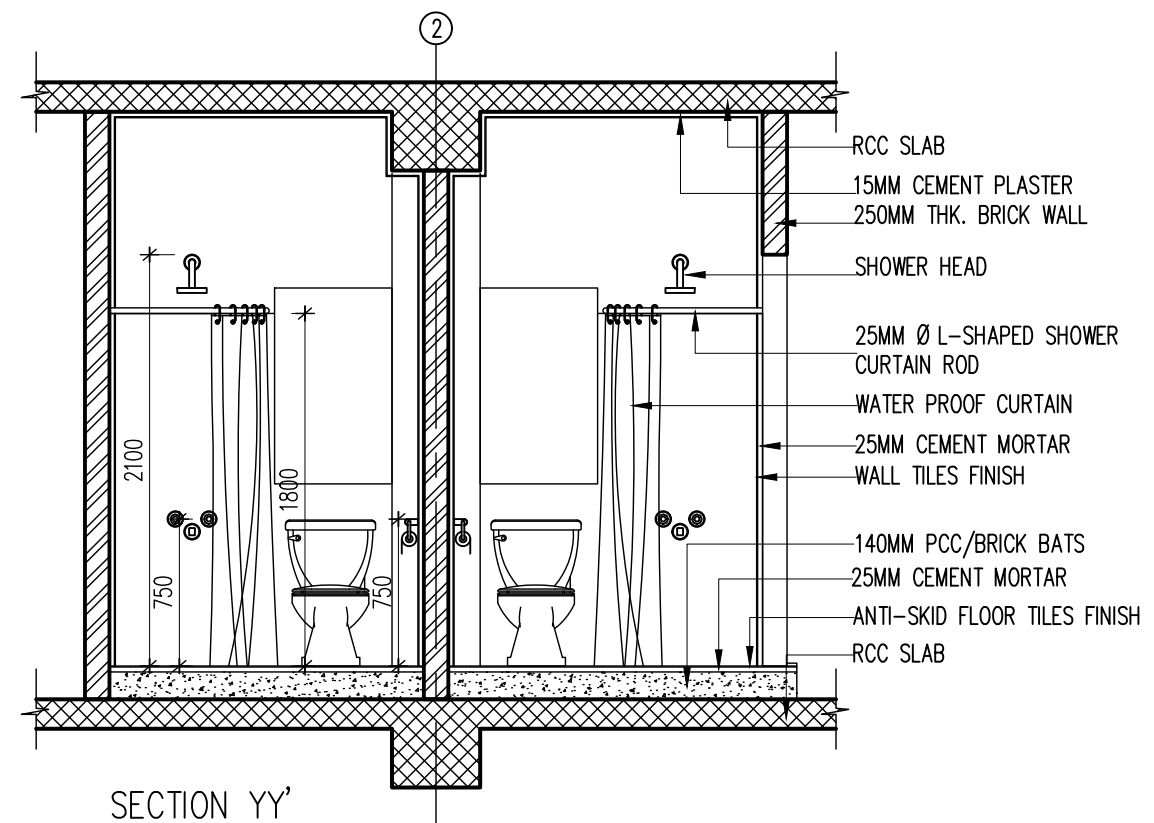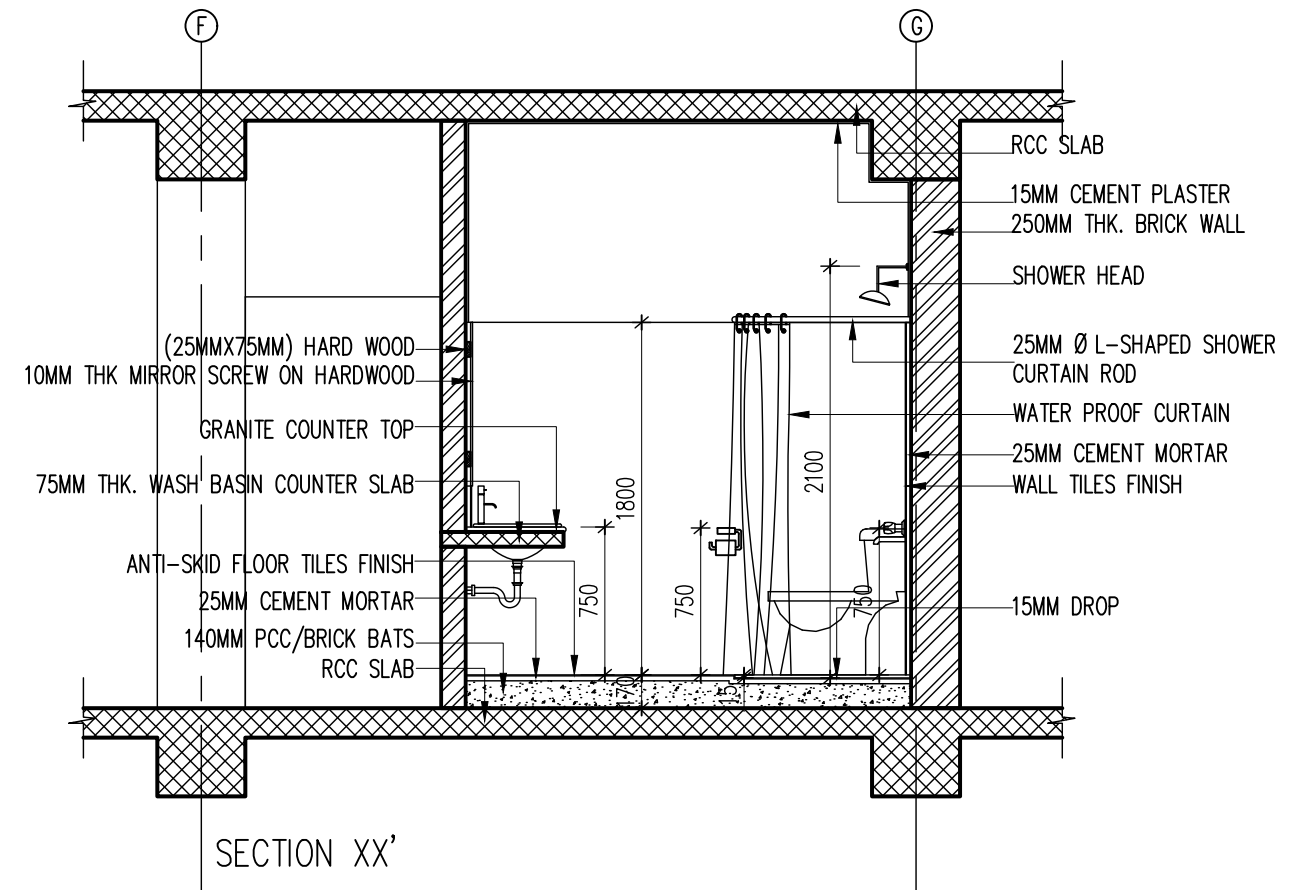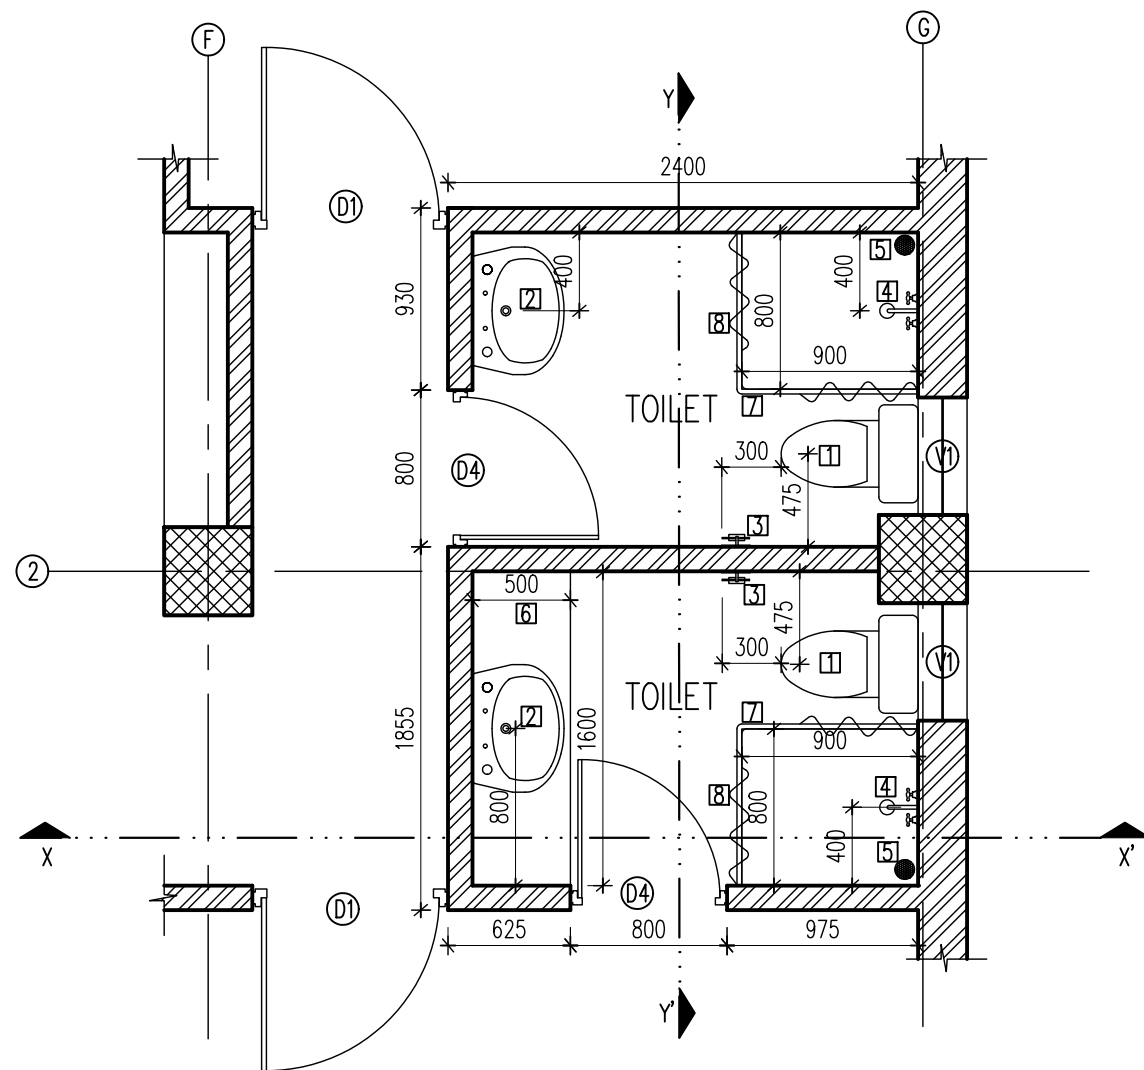

	BHUTAN POWER CORPORATION LIMITED TRANSMISSION DEPARTMENT	PROJECT TITLE			REFERENCE NOTES		APPROVED BY	DESIGNED BY	DRAWING TITLE		DRAWING NO.
		DESIGN OF STAFF QUARTER (G+2) AT TSHENKHARI, NANGLAM			1. ALL MEASUREMENTS IN THE DRAWING ARE IN mm UNLESS AND OTHERWISE MENTIONED				REFER DRAWING		BPC/TD/TMD/NANGKOR/ARCH
					2. THE MEASUREMENTS IN THE DRAWING ARE TO BE READ AND NOT MEASURED		KUNZANG TOBGYE GENERAL MANAGER TD, BPC	SAILESH KUMAGAI ARCHITECT BA-141 (P)	SCALE	DATE	DWG # 10
		DRAWING STATUS			APPROVAL <input type="checkbox"/>	APPROVED <input type="checkbox"/>			3. ANY DISCREPANCY IN THE DRAWING SHALL BE IMMEDIATELY BROUGHT TO THE NOTICE OF THE DESIGNER		





 BHUTAN POWER CORPORATION LIMITED TRANSMISSION DEPARTMENT	PROJECT TITLE		REFERENCE NOTES		APPROVED BY	DESIGNED BY	DRAWING TITLE		DRAWING NO.
	DESIGN OF STAFF QUARTER (G+2) AT TSHENKHARI, NANGLAM		1. ALL MEASUREMENTS IN THE DRAWING ARE IN mm UNLESS AND OTHERWISE MENTIONED				REFER DRAWING		BPC/TD/TMD/NANGKOR/ARCH
	DRAWING STATUS		2. THE MEASUREMENTS IN THE DRAWING ARE TO BE READ AND NOT MEASURED		KUNZANG TOBGYE GENERAL MANAGER TD, BPC	SAILESH HUMAGAI ARCHITECT BA-141 (P)	SCALE	DATE	DWG # 12
	APPROVAL <input type="checkbox"/> APPROVED <input type="checkbox"/>		3. ANY DISCREPANCY IN THE DRAWING SHALL BE IMMEDIATELY BROUGHT TO THE NOTICE OF THE DESIGNER				REF DWG	FEBRUARY, 2022	




 <div>BHUTAN POWER CORPORATION LIMITED TRANSMISSION DEPARTMENT</div>	PROJECT TITLE		REFERENCE NOTES		APPROVED BY	DESIGNED BY	DRAWING TITLE		DRAWING NO.
	DESIGN OF STAFF QUARTER (G+2) AT TSHENKHARI, NANGLAM		1. ALL MEASUREMENTS IN THE DRAWING ARE IN mm UNLESS AND OTHERWISE MENTIONED				REFER DRAWING		BPC/TD/TMD/NANGKOR/ARCH
			2. THE MEASUREMENTS IN THE DRAWING ARE TO BE READ AND NOT MEASURED						
	DRAWING STATUS	APPROVAL <input type="checkbox"/>	APPROVED <input type="checkbox"/>	3. ANY DISCREPANCY IN THE DRAWING SHALL BE IMMEDIATELY BROUGHT TO THE NOTICE OF THE DESIGNER		KUNZANG TOBGYE GENERAL MANAGER TD, BPC	 SAMRESH HUMAGAI ARCHITECT BA-141 (P)	SCALE	DATE
							REF DWG	FEBRUARY, 2022	



GENERAL NOTES FOR DOORS AND WINDOWS:

1. DOOR/WINDOW FRAMES TO BE FIXED TO MASONRY BY IRON
HOLDFAST 400X40X3MM THK. HOLDFAST BEND UP TO RIGHT ANGLE
50MM FIXED TO FRAME BY 10Ø BOLTS, NUTS AND WOOD PLUGS AND
EMBEDDED IN CEMENT CONCRETE BLOCK. THE HOLDFAST IN THE
BLOCK TO BE FORKED AND BENT AT RIGHT ANGLES IN THE
OPPOSITE DIRECTION. THESE CEMENT CONCRETE BLOCKS OF P.C.C
(1:3:6) SHALL BE CAST-IN-SITU DURING WALL CONSTRUCTION.
2. PELMET SHALL BE PROVIDED FOR DOORS AND WINDOWS WITH
NECESSARY CURTAIN FITTINGS.
3. BHUTANESE ARCHITECTURAL CURVES SHALL BE AS PER LATEST
PRACTICE AND FIXED TO WINDOW FRAMES AS PER APPROVAL OF
ENGINEER IN CHARGE.
4. FIX ORNAMENTAL GRILLS OF 20MMX5MM FOR WINDOWS IN THE
GROUND FLOOR ONLY.


SCHEDULE OF OPENINGS (DOORS AND WINDOWS)								
DOOR/WINDOW	GROUND FLOOR	FIRST FLOOR	SECOND FLOOR	JAMTHOG	TOTAL	SILL LVL	LINTEL LVL	DIMENSIONS
W1	10	08	–	–	18	600	2100	2450 X 1500
RW1	–	–	08	–	08	600	REF DWG	REF DWG
DW1	–	02	02	–	04	FL	2100	REF DWG
KW1	02	02	02	–	06	900	2100	1300 X 1200
V1	06	06	06	–	18	1100	2100	600 X 1000
V2	–	–	–	08	08	2020	2520	1200 X 500
D1	06	06	06	–	18	FL	2100	1000 X 2100
D2	02	02	02	–	06	FL	2100	900 X 2100
D3	02	02	02	–	06	FL	2100	800 X 2100
D4	04	04	04	–	12	FL	2100	800 X 2100

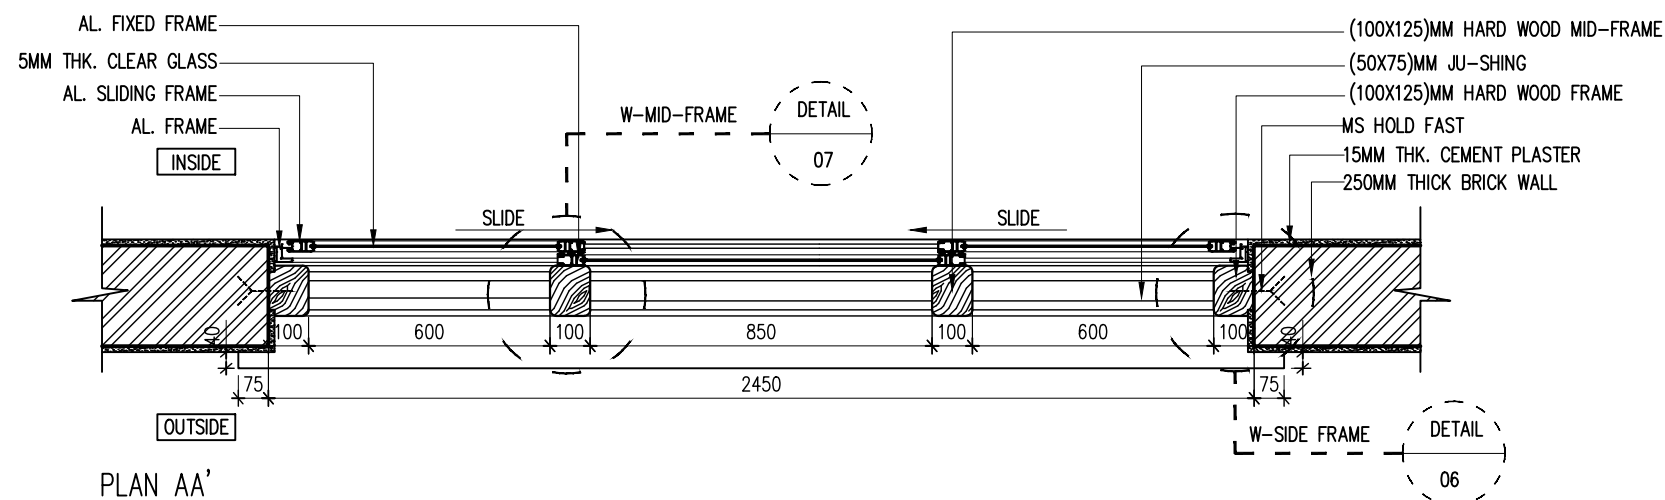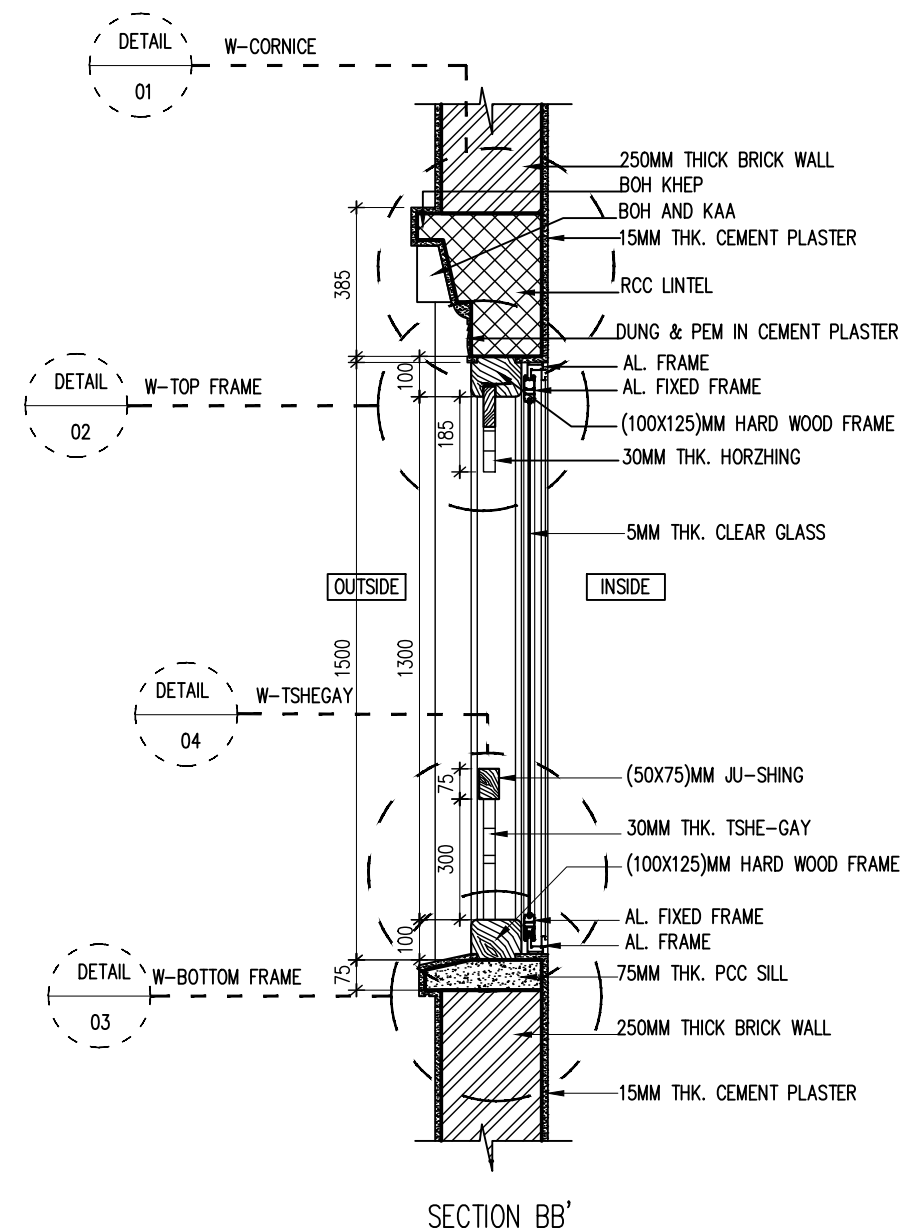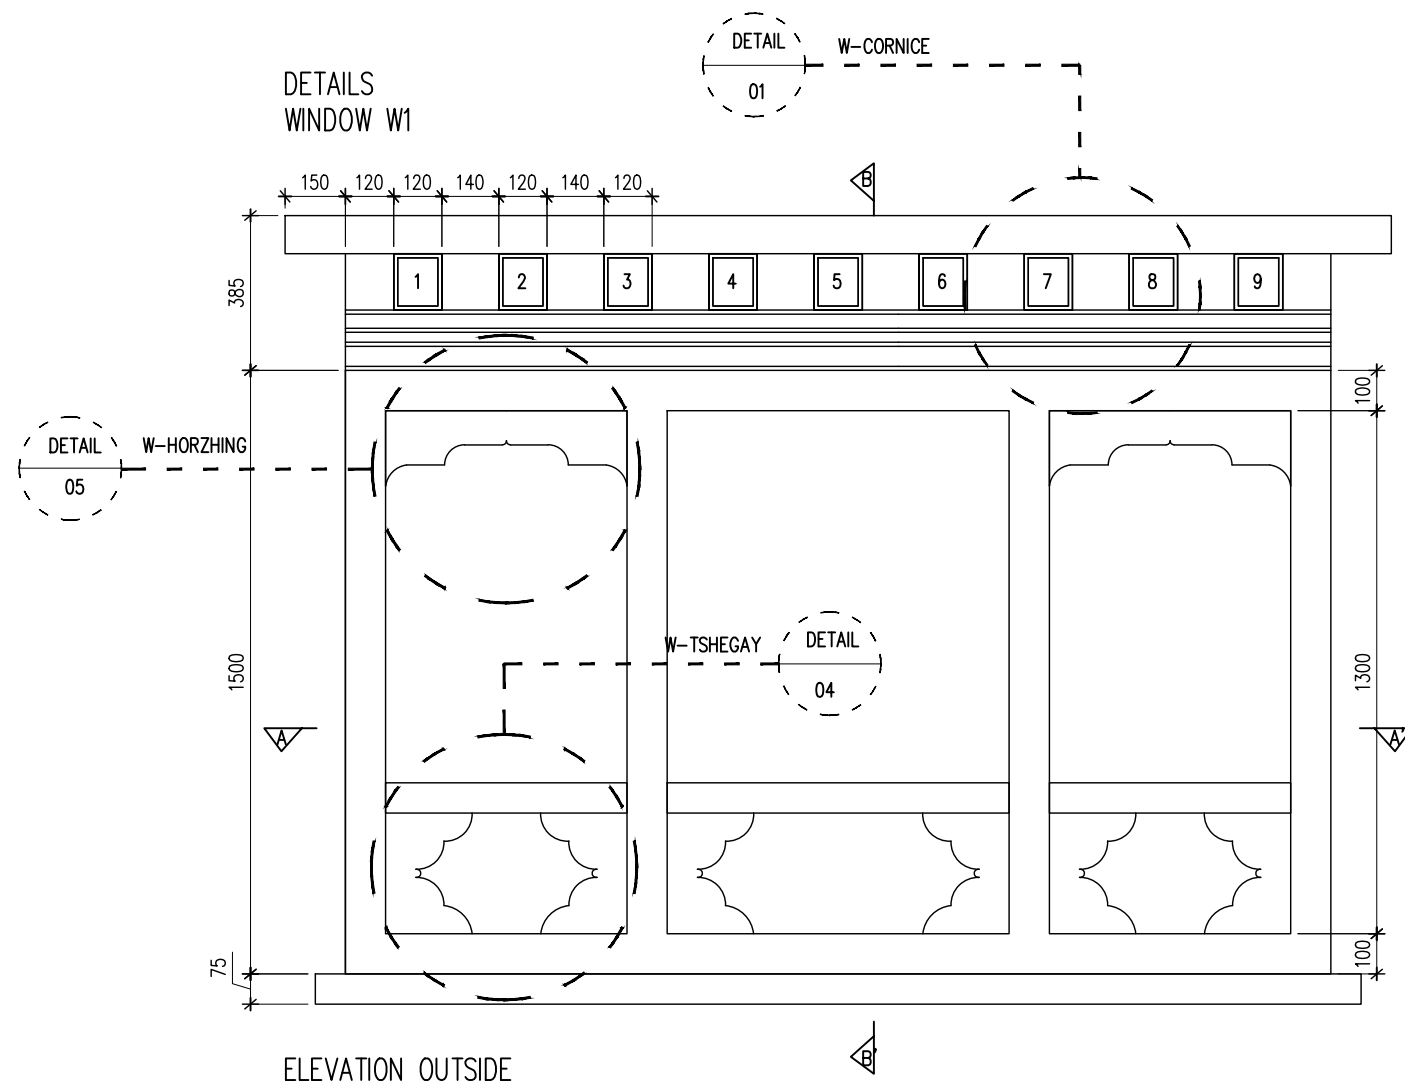	BHUTAN POWER CORPORATION LIMITED		PROJECT TITLE		REFERENCE NOTES		APPROVED BY	DESIGNED BY	DRAWING TITLE		DRAWING NO.	
			DESIGN OF STAFF QUARTER (G+2) AT TSHENKHARI, NANGLAM		1. ALL MEASUREMENTS IN THE DRAWING ARE IN mm UNLESS AND OTHERWISE MENTIONED				REFER DRAWING		BPC/TD/TMD/NANGKOR/ARCH	
	TRANSMISSION DEPARTMENT				2. THE MEASUREMENTS IN THE DRAWING ARE TO BE READ AND NOT MEASURED		KUNZANG TOBGYE GENERAL MANAGER TD, BPC		SCALE	DATE	DWG # 14	
	DRAWING STATUS	APPROVAL <input type="checkbox"/>	APPROVED <input type="checkbox"/>	3. ANY DISCREPANCY IN THE DRAWING SHALL BE IMMEDIATELY BROUGHT TO THE NOTICE OF THE DESIGNER	REF DWG	FEBRUARY, 2022						




 BPC <small>Electricity</small>	BHUTAN POWER CORPORATION LIMITED TRANSMISSION DEPARTMENT	PROJECT TITLE			REFERENCE NOTES		APPROVED BY	DESIGNED BY	DRAWING TITLE		DRAWING NO.
		DESIGN OF STAFF QUARTER (G+2) AT TSHENKHARI, NANGLAM			1. ALL MEASUREMENTS IN THE DRAWING ARE IN mm UNLESS AND OTHERWISE MENTIONED			 SAILESH HUMAGAI ARCHITECT BA-141 (P)	REFER DRAWING		BPC/TD/TMD/NANGKOR/ARCH
					2. THE MEASUREMENTS IN THE DRAWING ARE TO BE READ AND NOT MEASURED		KUNZANG TOBGYE GENERAL MANAGER TD, BPC		SCALE	DATE	DWG # 15
		DRAWING STATUS	APPROVAL <input type="checkbox"/>	APPROVED <input type="checkbox"/>	3. ANY DISCREPANCY IN THE DRAWING SHALL BE IMMEDIATELY BROUGHT TO THE NOTICE OF THE DESIGNER			REF DWG	FEBRUARY, 2022		


DETAILS KITCHEN WINDOW KW1

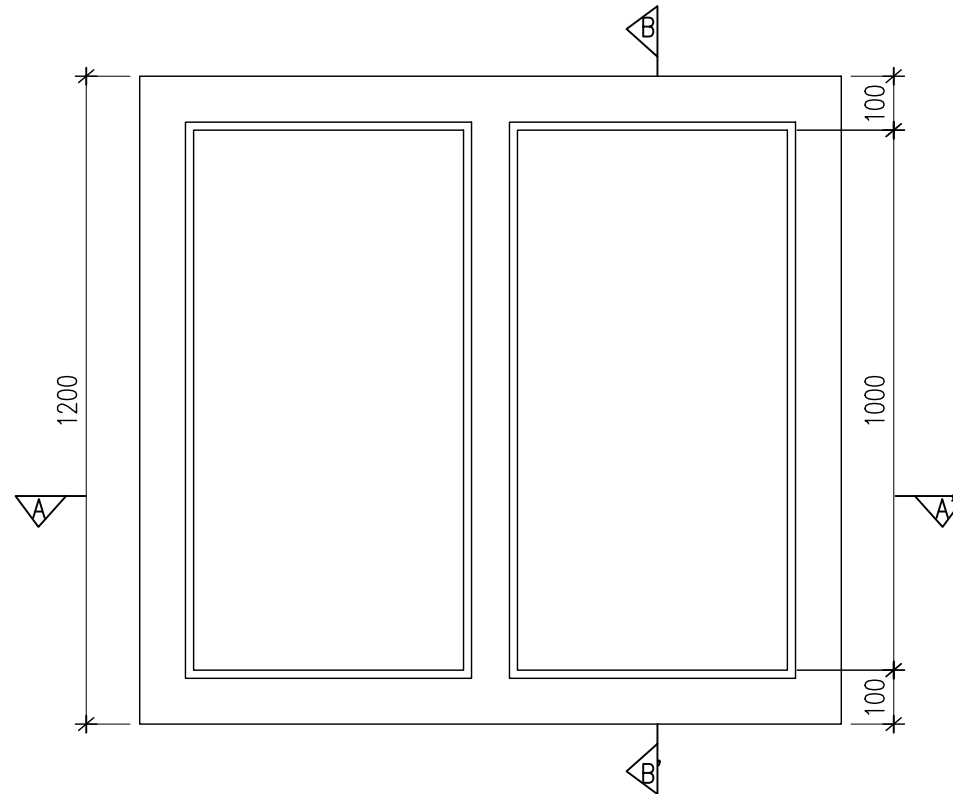

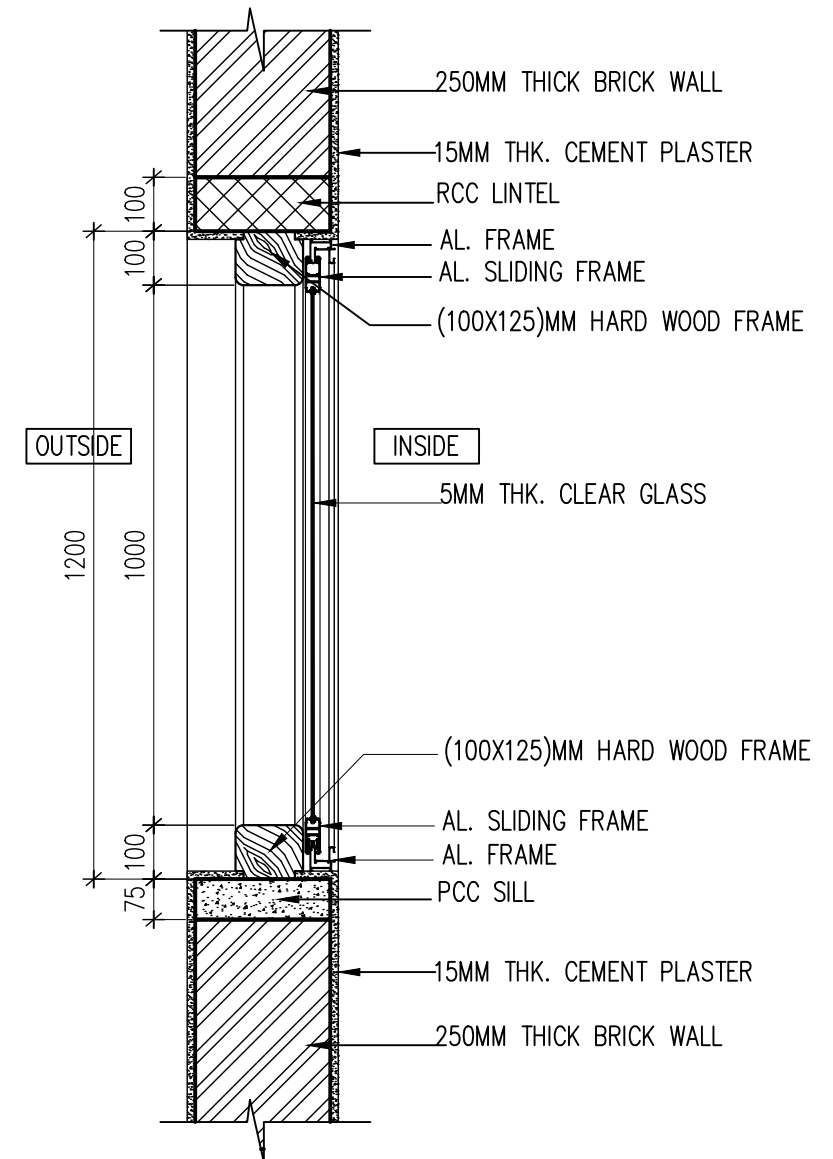

ELEVATION OUTSIDE



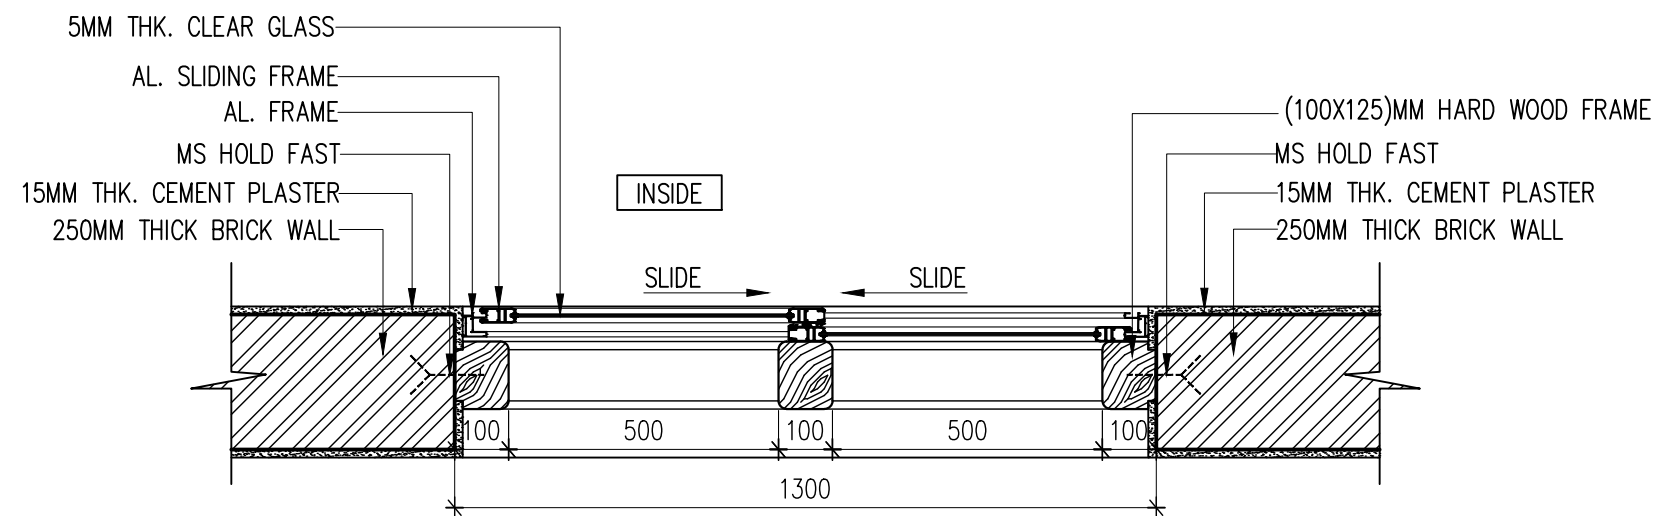



SECTION BB'











PLAN AA'

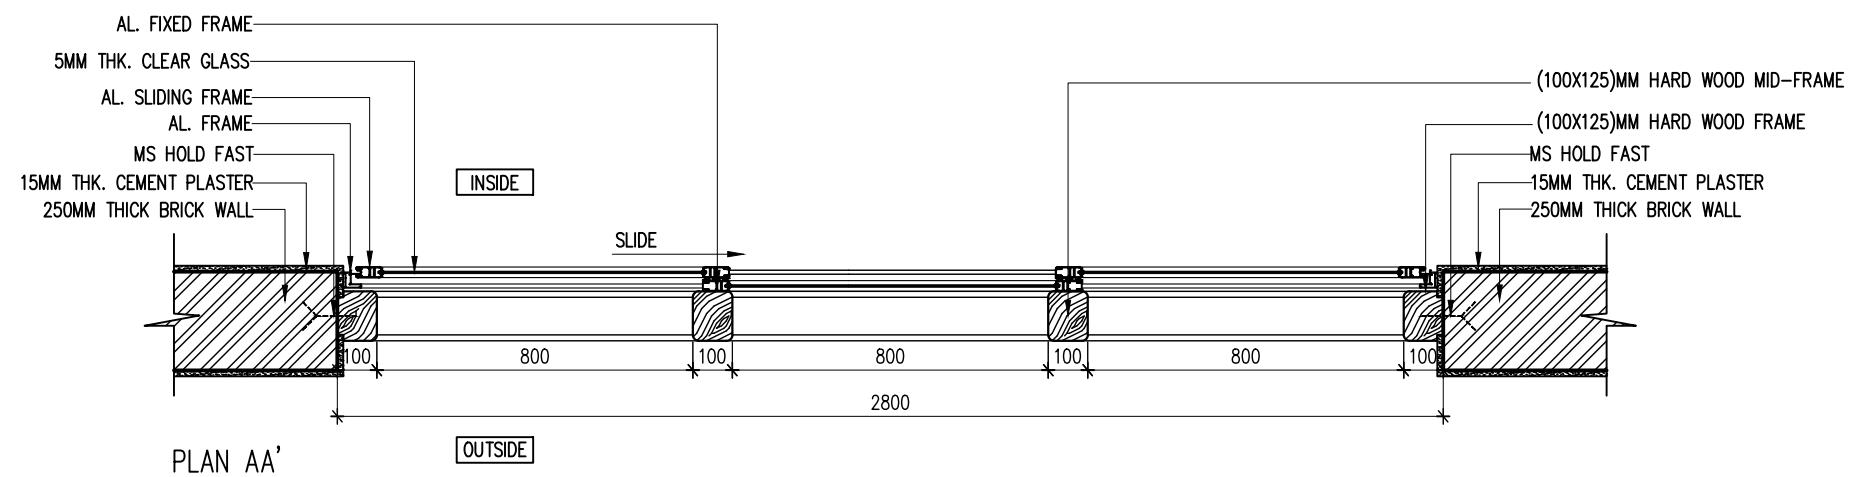
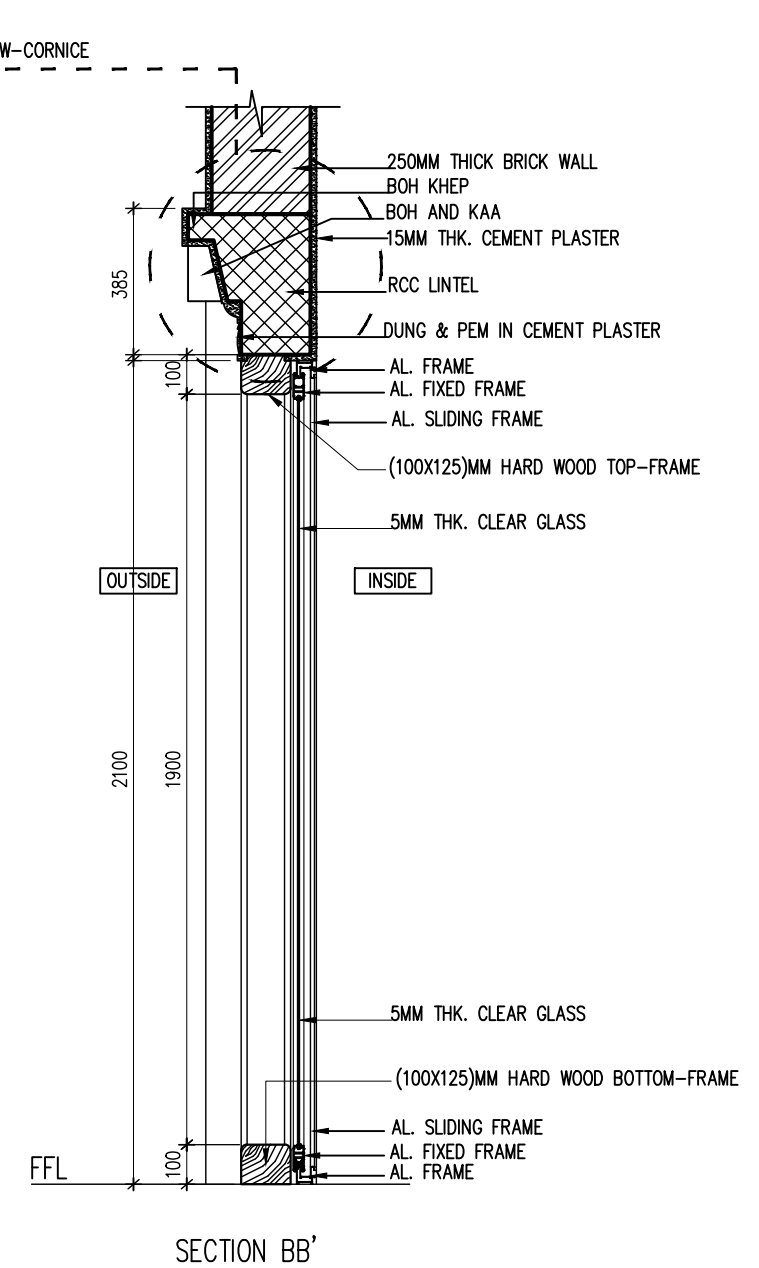
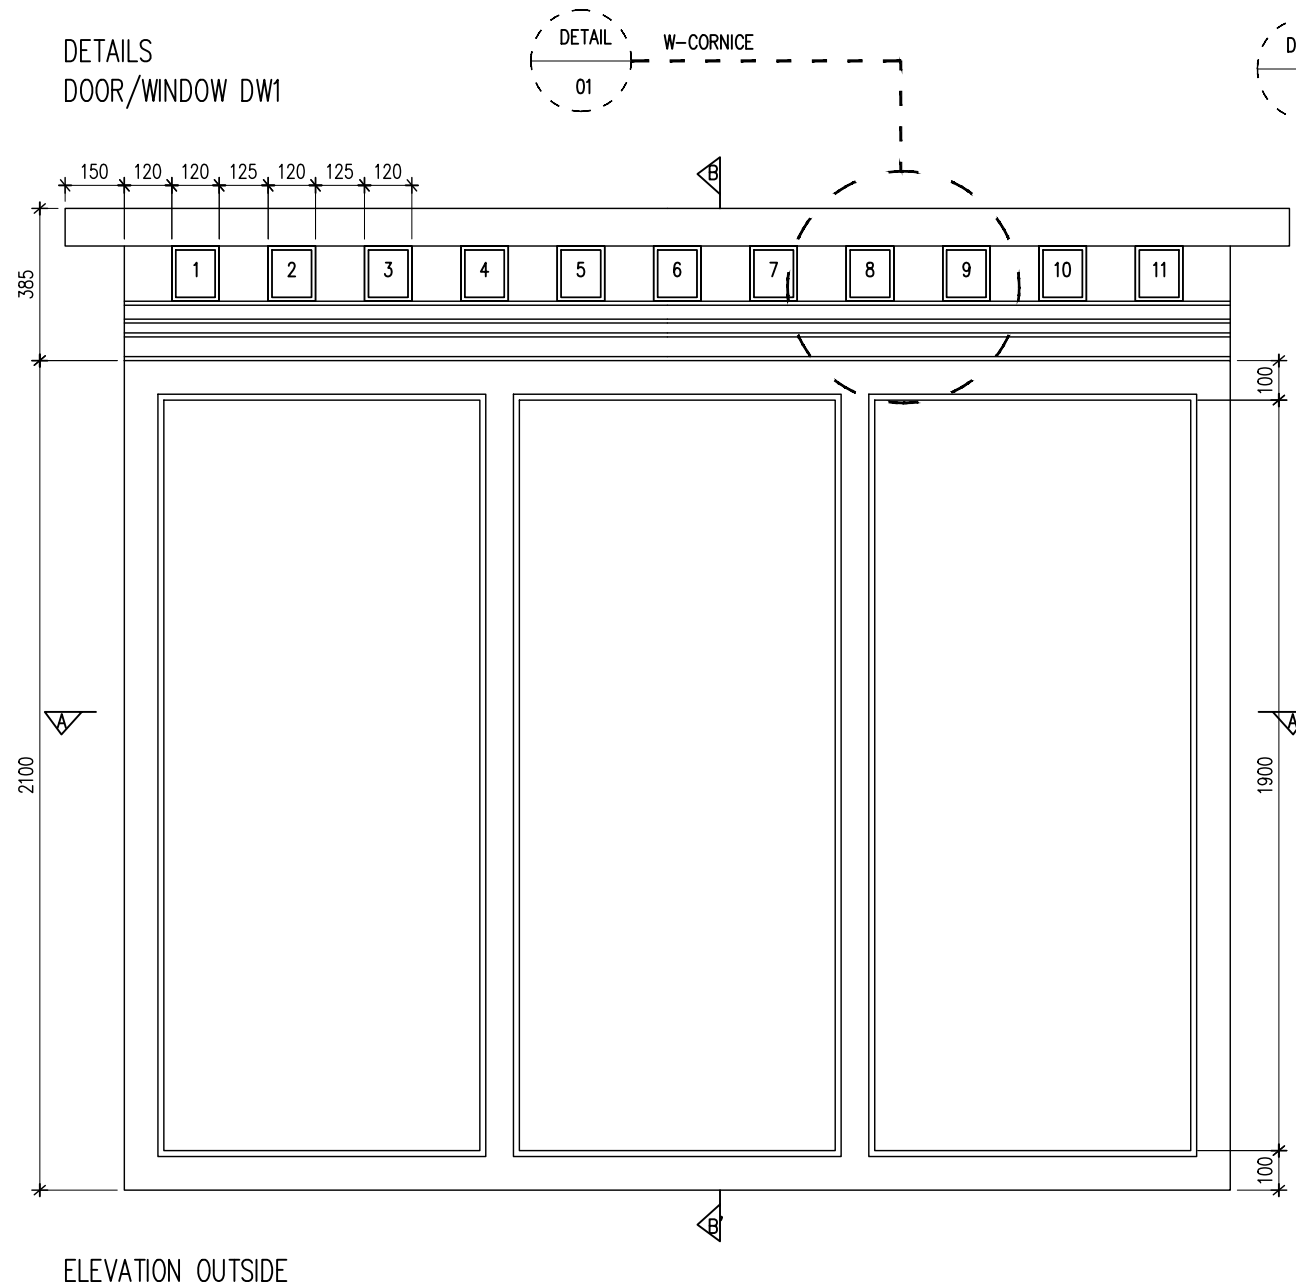
	BHUTAN POWER CORPORATION LIMITED TRANSMISSION DEPARTMENT	PROJECT TITLE		REFERENCE NOTES		APPROVED BY	DESIGNED BY	DRAWING TITLE		DRAWING NO.
		DESIGN OF STAFF QUARTER (G+2) AT TSHENKHARI, NANGLAM		1. ALL MEASUREMENTS IN THE DRAWING ARE IN mm UNLESS AND OTHERWISE MENTIONED			 SAILESH HUMAGAI ARCHITECT BA-141 (P)	REFER DRAWING		BPC/TD/TMD/NANGKOR/ARCH
				2. THE MEASUREMENTS IN THE DRAWING ARE TO BE READ AND NOT MEASURED		KUNZANG TOBGYE GENERAL MANAGER TD, BPC		SCALE	DATE	DWG # 16
		DRAWING STATUS	APPROVAL <input type="checkbox"/>	APPROVED <input type="checkbox"/>	3. ANY DISCREPANCY IN THE DRAWING SHALL BE IMMEDIATELY BROUGHT TO THE NOTICE OF THE DESIGNER		REF DWG	FEBRUARY, 2022		

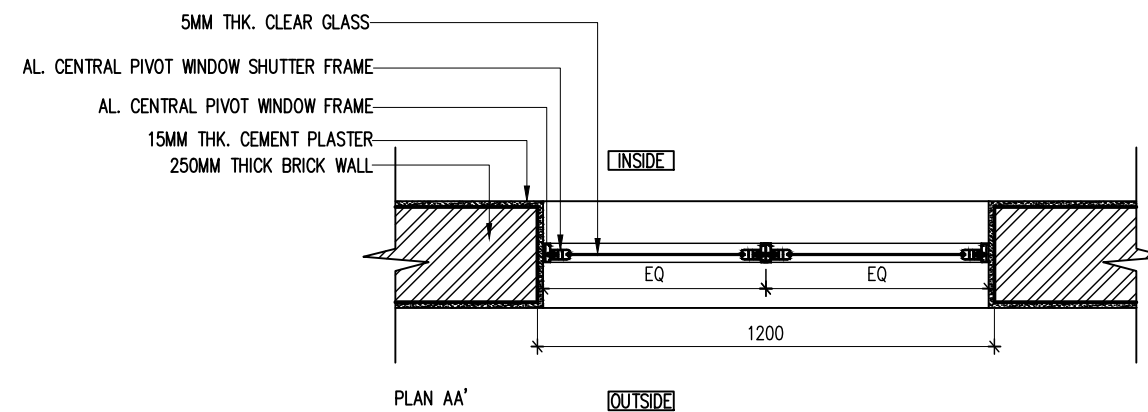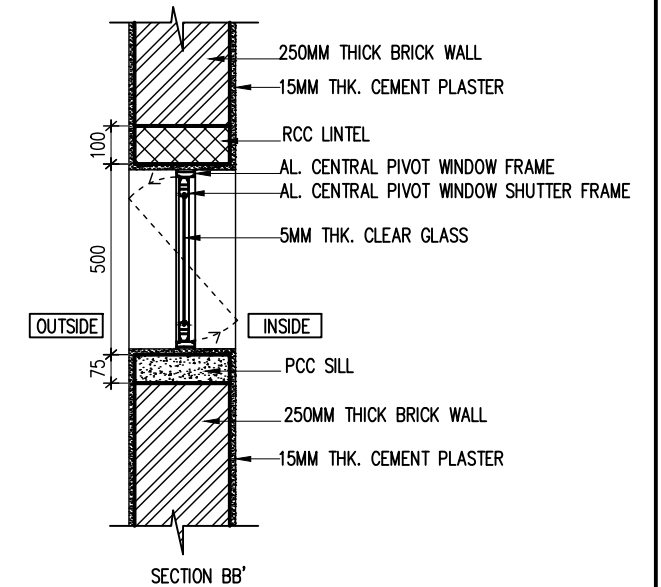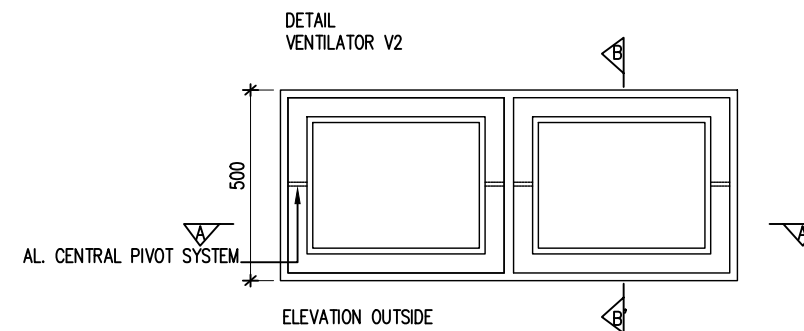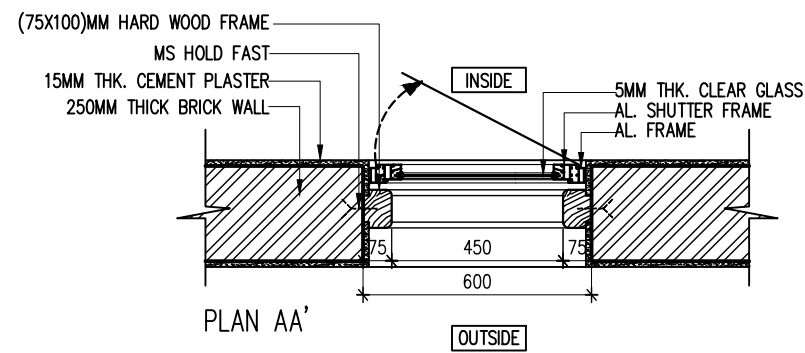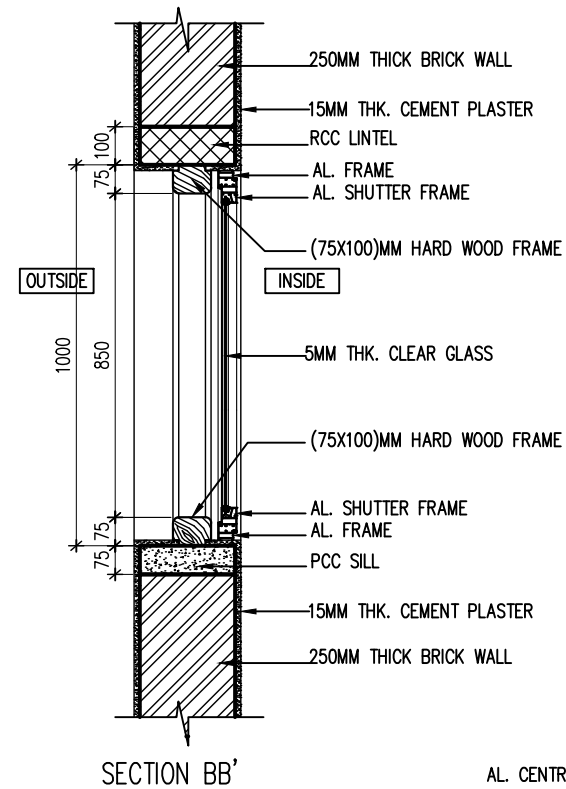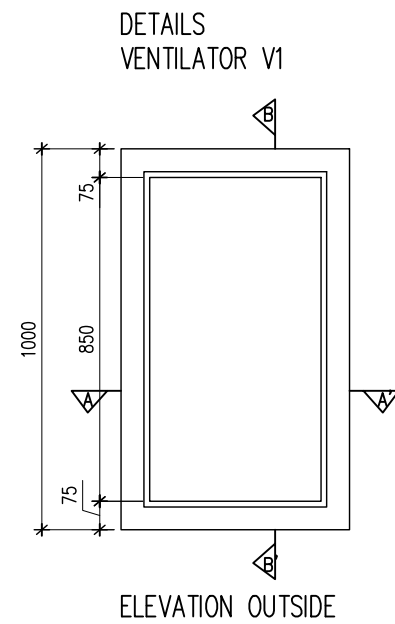


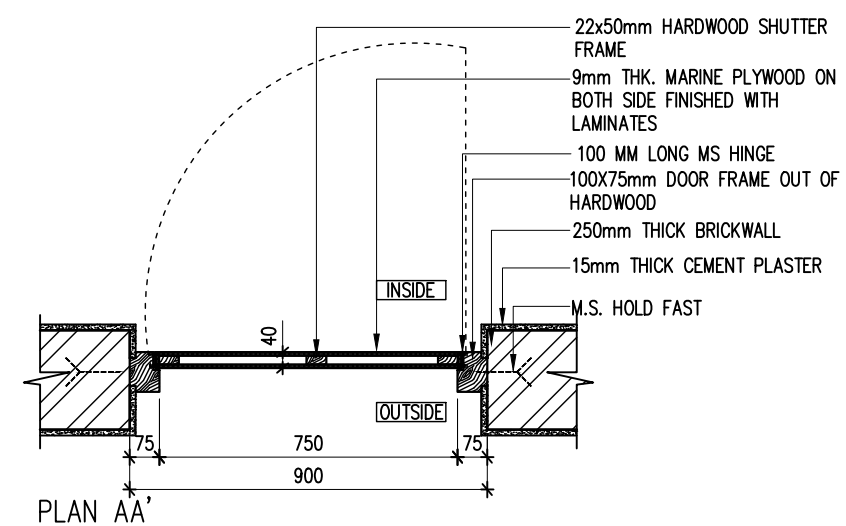
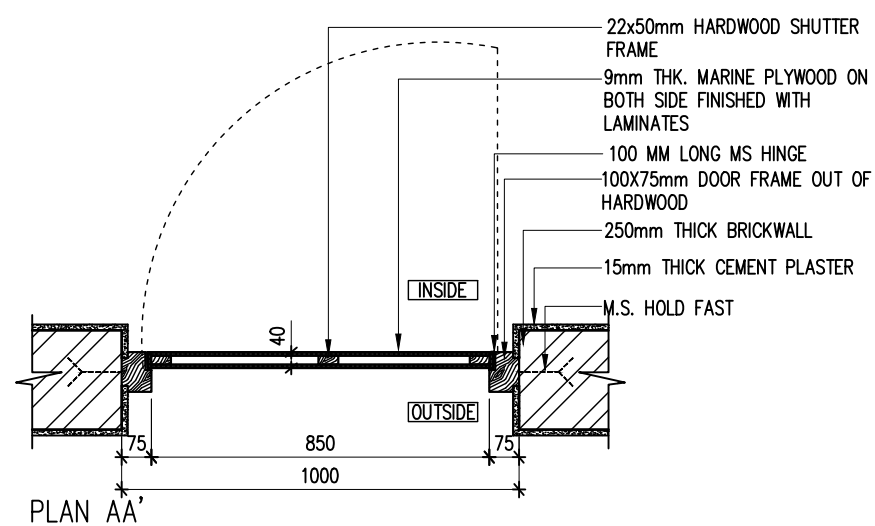
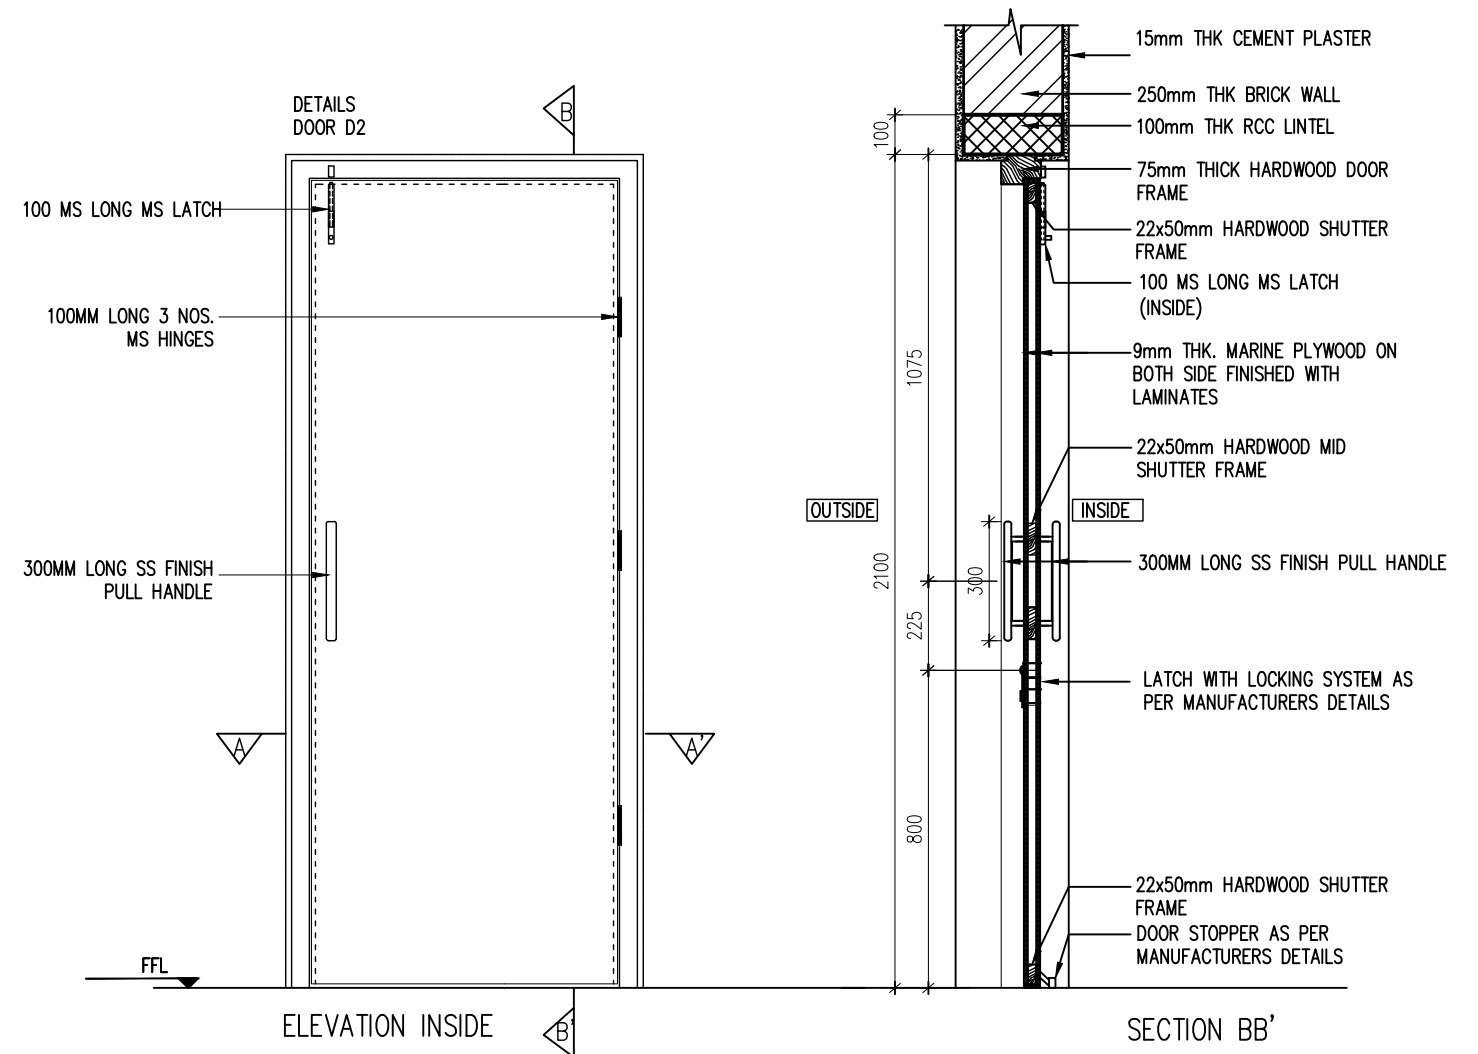
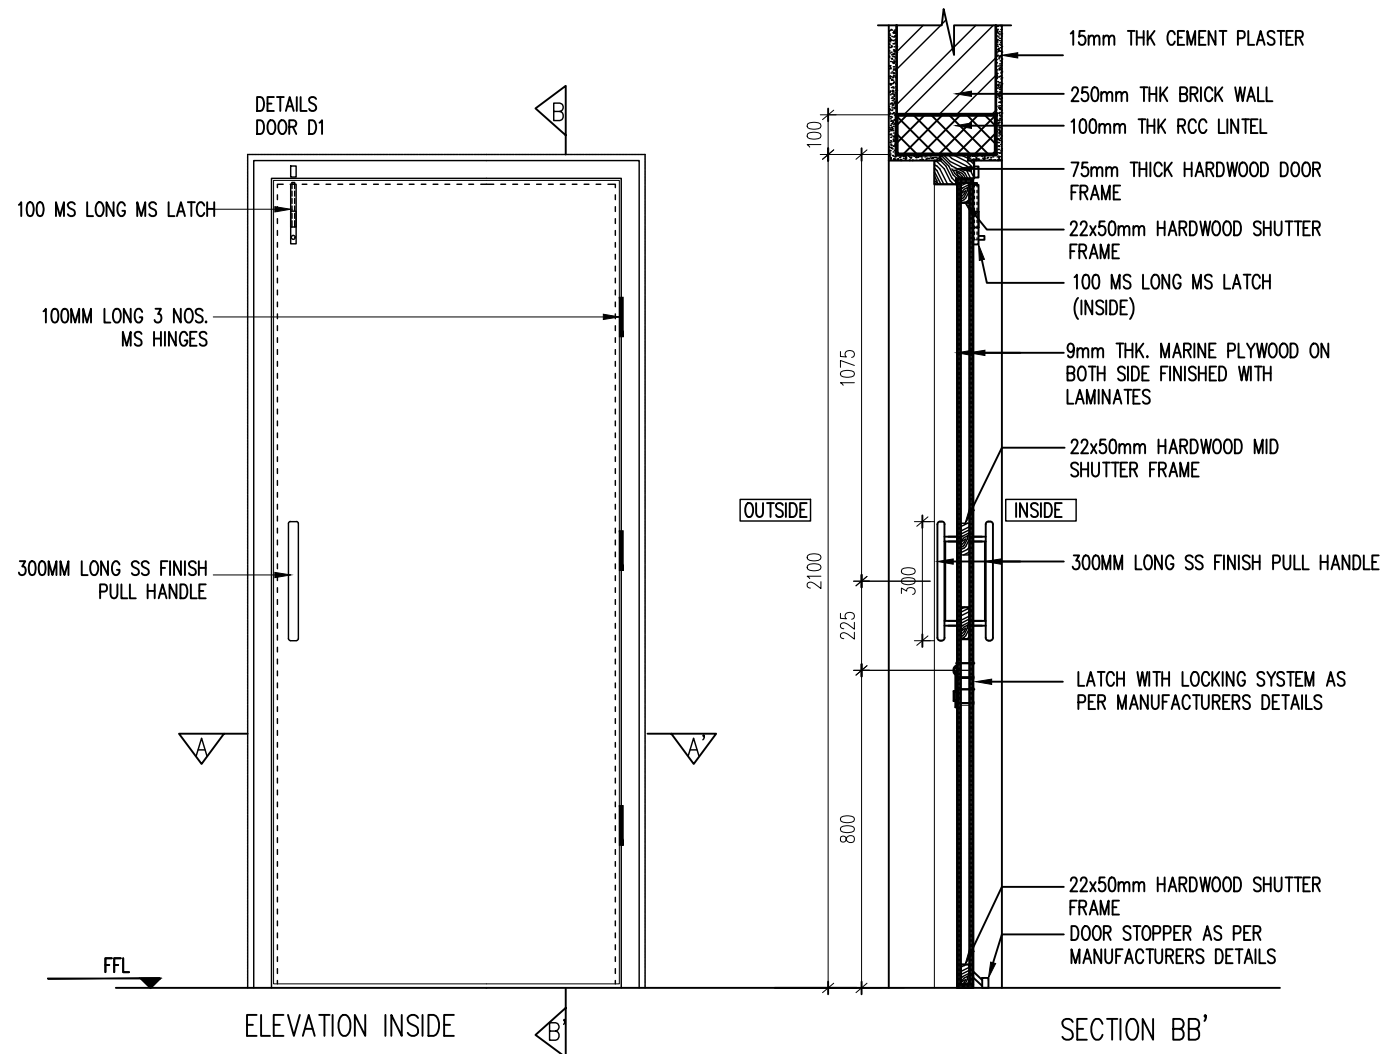
	BHUTAN POWER CORPORATION LIMITED TRANSMISSION DEPARTMENT	PROJECT TITLE	REFERENCE NOTES		APPROVED BY	DESIGNED BY	DRAWING TITLE		DRAWING NO.
		DESIGN OF STAFF QUARTER (G+2) AT TSHENKHARI, NANGLAM	1. ALL MEASUREMENTS IN THE DRAWING ARE IN mm UNLESS AND OTHERWISE MENTIONED				REFER DRAWING		BPC/TD/TMD/NANGKOR/ARCH
		DRAWING STATUS	APPROVAL	APPROVED	KUNZANG TOBGYE GENERAL MANAGER TD, BPC	SAILESH HUMAGAI ARCHITECT BA-141 (P)	SCALE	DATE	DWG # 17
							REF DWG	FEBRUARY, 2022	



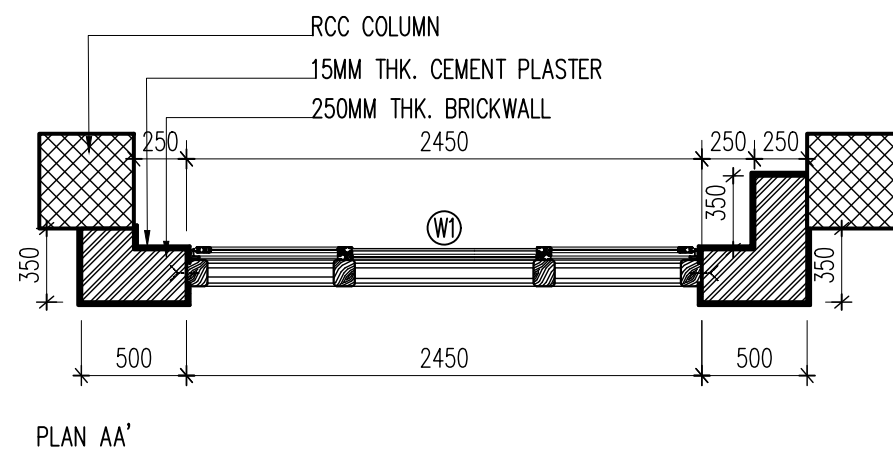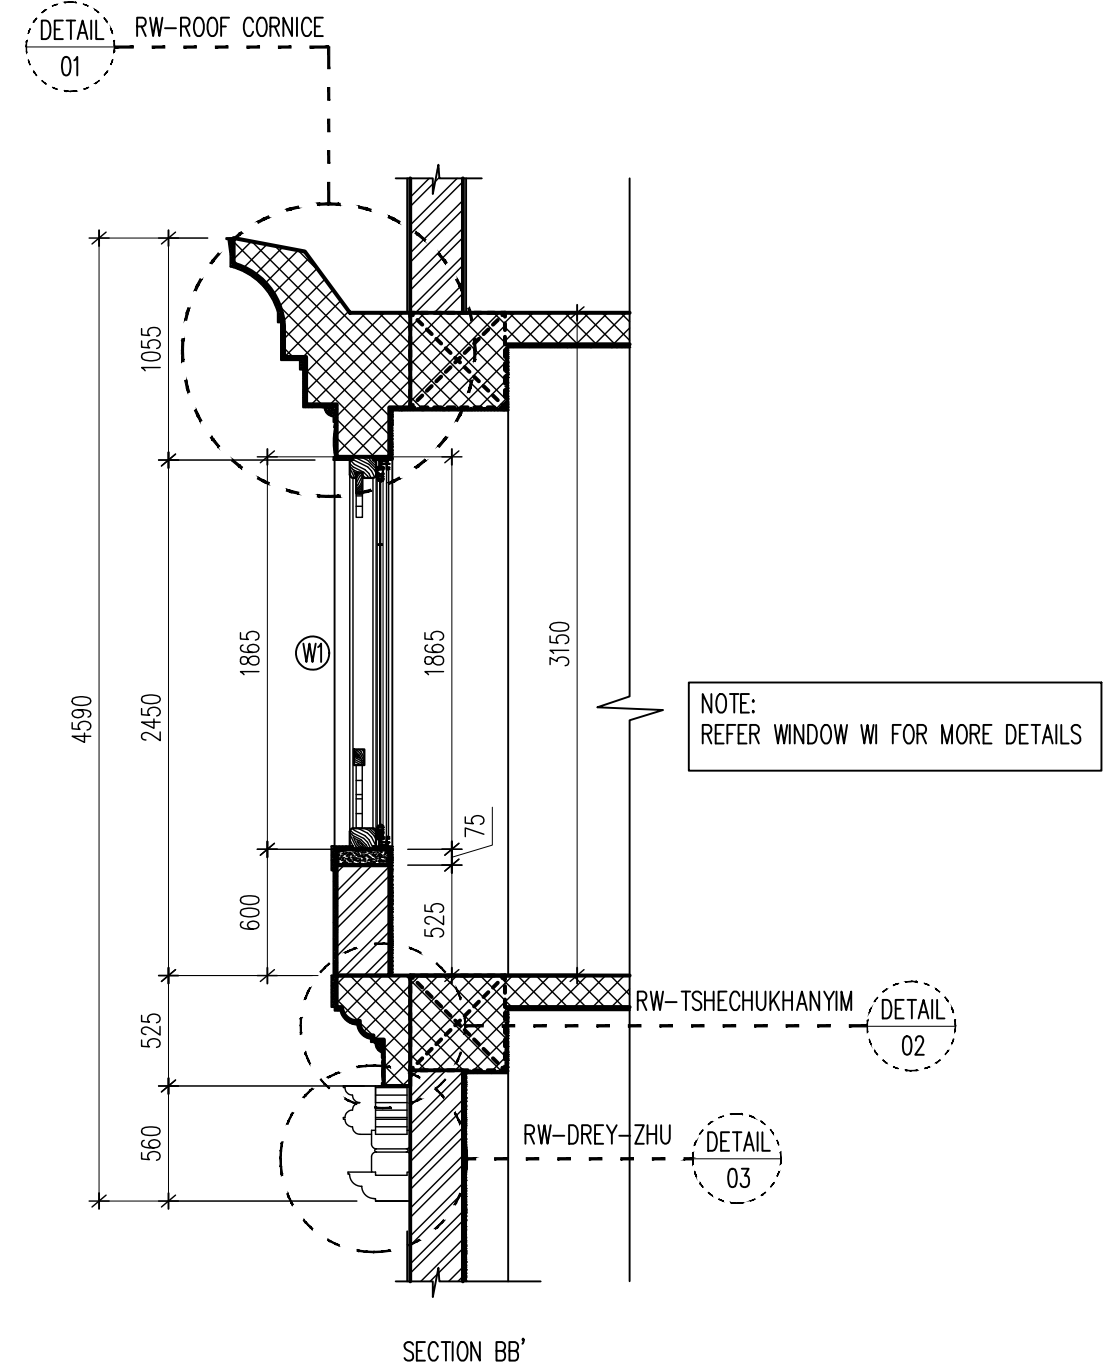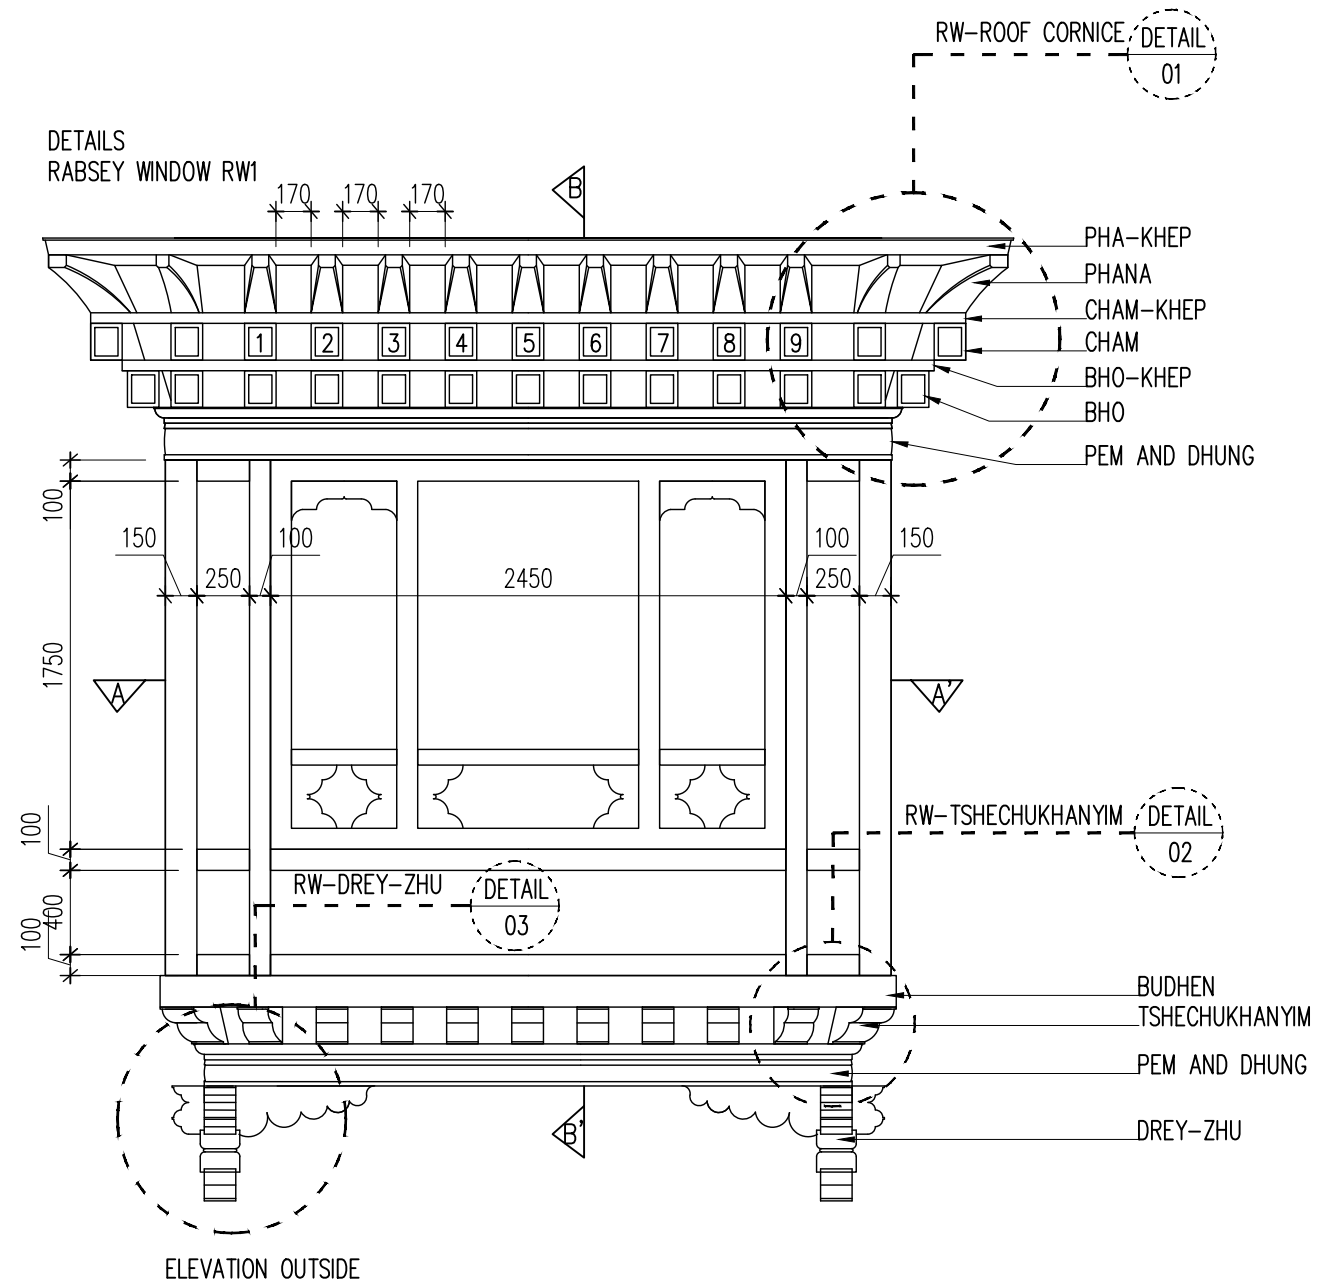





	BHUTAN POWER CORPORATION LIMITED	PROJECT TITLE			REFERENCE NOTES		APPROVED BY	DESIGNED BY	DRAWING TITLE		DRAWING NO.		
		DESIGN OF STAFF QUARTER (G+2) AT TSHENKHARI, NANGLAM			1. ALL MEASUREMENTS IN THE DRAWING ARE IN mm UNLESS AND OTHERWISE MENTIONED				REFER DRAWING		BPC/TD/TMD/NANGKOR/ARCH		
					2. THE MEASUREMENTS IN THE DRAWING ARE TO BE READ AND NOT MEASURED				KUNZANG TOBGYE GENERAL MANAGER TD, BPC	SAILESH HUMAGAI ARCHITECT BA-141 (P)	SCALE	DATE	DWG # 18
					DRAWING STATUS APPROVAL <input type="checkbox"/> APPROVED <input type="checkbox"/>						3. ANY DISCREPANCY IN THE DRAWING SHALL BE IMMEDIATELY BROUGHT TO THE NOTICE OF THE DESIGNER		
		TRANSMISSION DEPARTMENT											










	BHUTAN POWER CORPORATION LIMITED TRANSMISSION DEPARTMENT	PROJECT TITLE		REFERENCE NOTES		APPROVED BY	DESIGNED BY	DRAWING TITLE		DRAWING NO.
		DESIGN OF STAFF QUARTER (G+2) AT TSHENKHARI, NANGLAM		1. ALL MEASUREMENTS IN THE DRAWING ARE IN mm UNLESS AND OTHERWISE MENTIONED				REFER DRAWING		BPC/TD/TMD/NANGKOR/ARCH
		DRAWING STATUS	APPROVAL <input type="checkbox"/> APPROVED <input type="checkbox"/>	2. THE MEASUREMENTS IN THE DRAWING ARE TO BE READ AND NOT MEASURED		KUNZANG TOBGYE GENERAL MANAGER TD, BPC	SAALES HUMAGAI ARCHITECT BA-141 (P)	SCALE	DATE	DWG # 19
				3. ANY DISCREPANCY IN THE DRAWING SHALL BE IMMEDIATELY BROUGHT TO THE NOTICE OF THE DESIGNER				REF DWG	FEBRUARY, 2022	



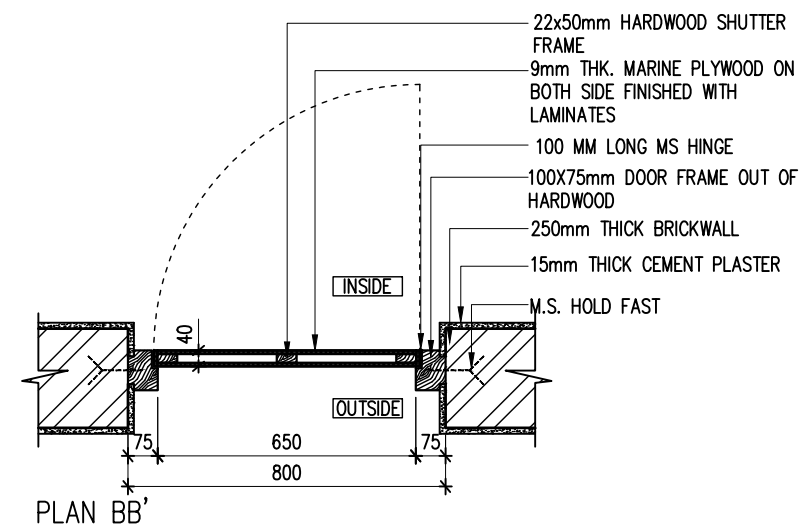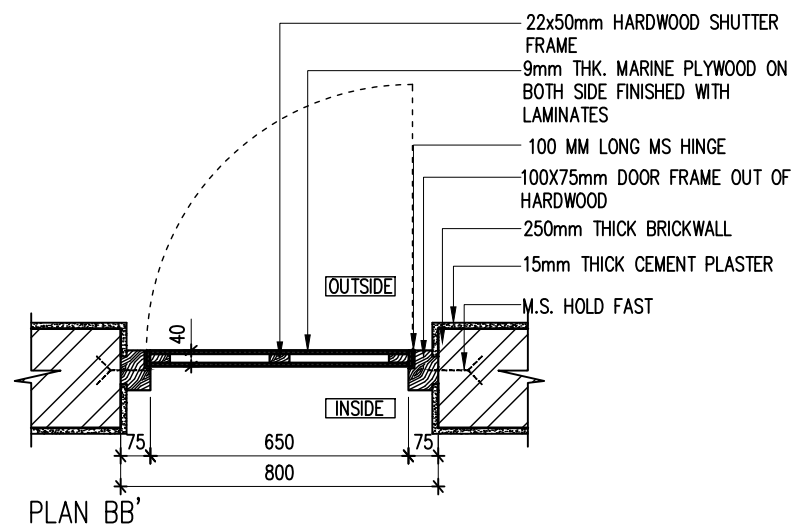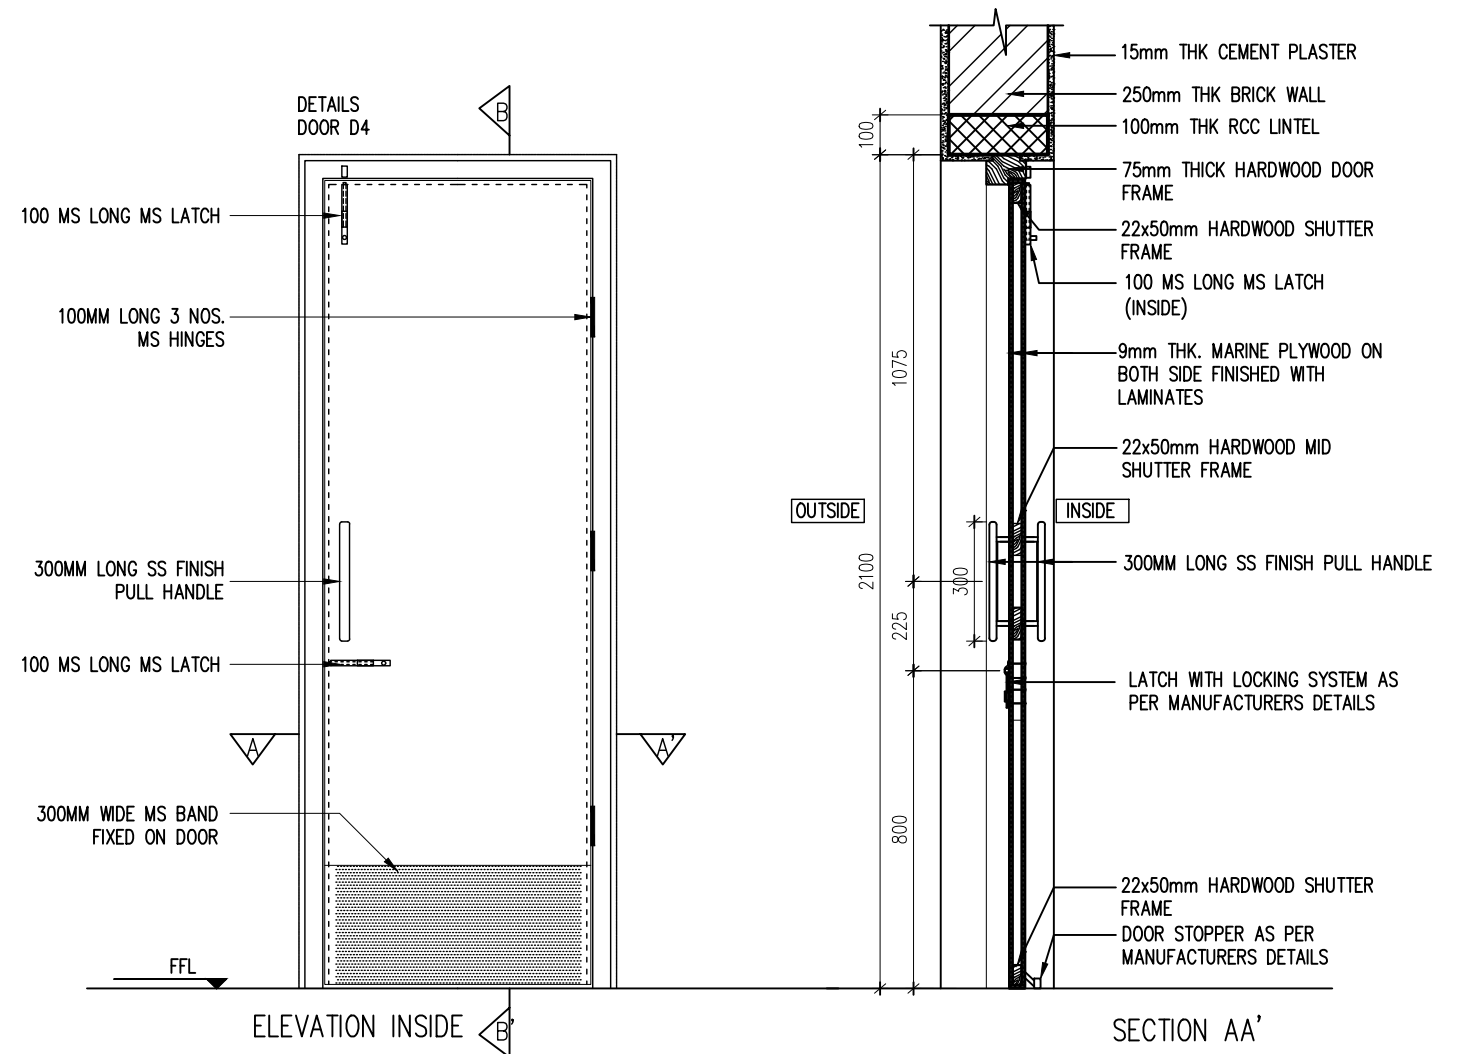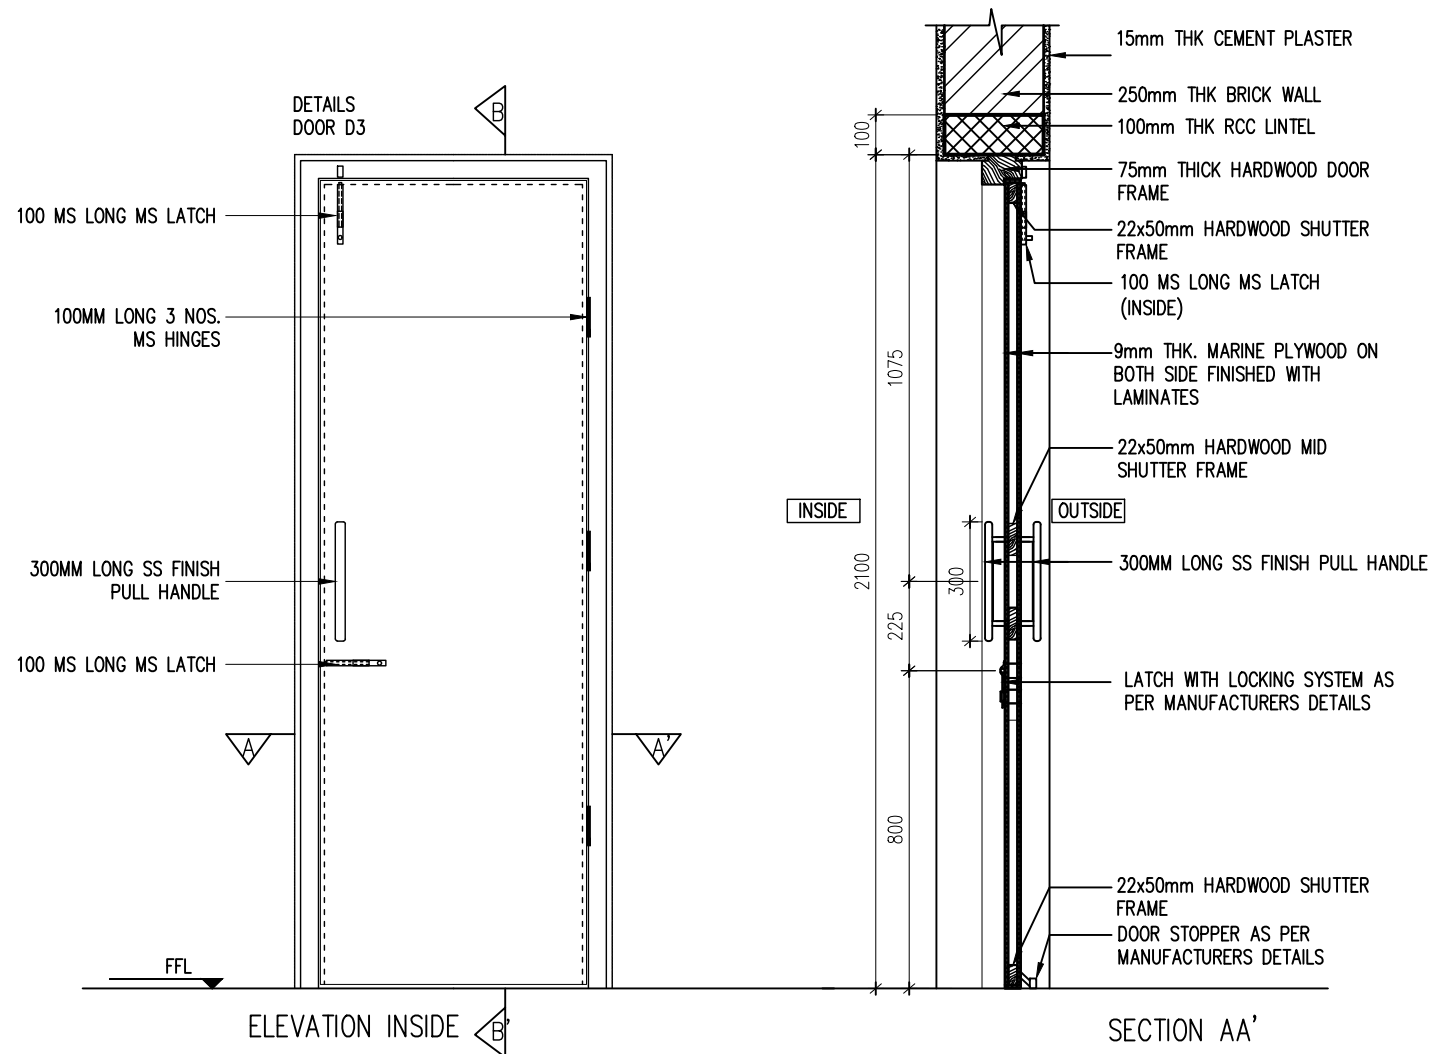

 
 
 
 <div>BHUTAN POWER CORPORATION LIMITED</div> <div>TRANSMISSION DEPARTMENT</div>	PROJECT TITLE		REFERENCE NOTES		APPROVED BY	DESIGNED BY	DRAWING TITLE		DRAWING NO.
	DESIGN OF STAFF QUARTER (G+2) AT TSHENKHARI, NANGLAM		1. ALL MEASUREMENTS IN THE DRAWING ARE IN mm UNLESS AND OTHERWISE MENTIONED			 SAILESH HUMAGAI ARCHITECT BA-141 (P)	REFER DRAWING		BPC/TD/TMD/NANGKOR/ARCH
			2. THE MEASUREMENTS IN THE DRAWING ARE TO BE READ AND NOT MEASURED				SCALE	DATE	DWG # 20
	DRAWING STATUS	APPROVAL <input type="checkbox"/>	APPROVED <input type="checkbox"/>	3. ANY DISCREPANCY IN THE DRAWING SHALL BE IMMEDIATELY BROUGHT TO THE NOTICE OF THE DESIGNER		KUNZANG TOBGYE GENERAL MANAGER TD, BPC		REF DWG	

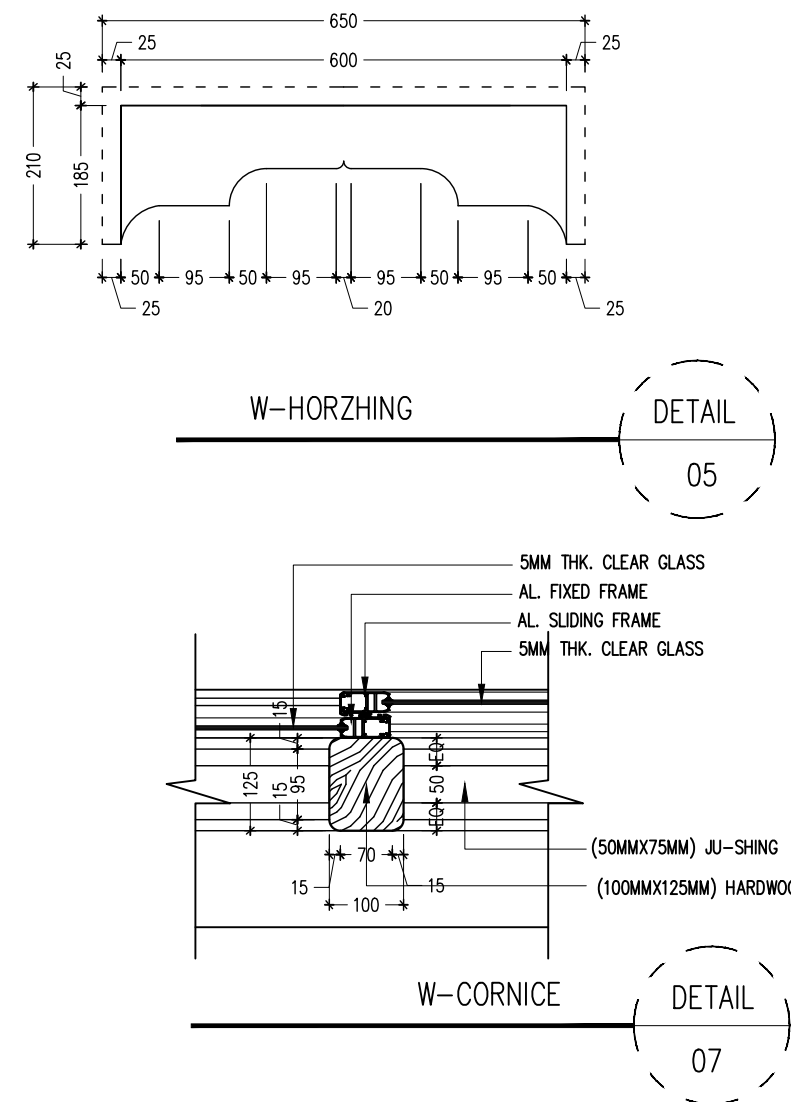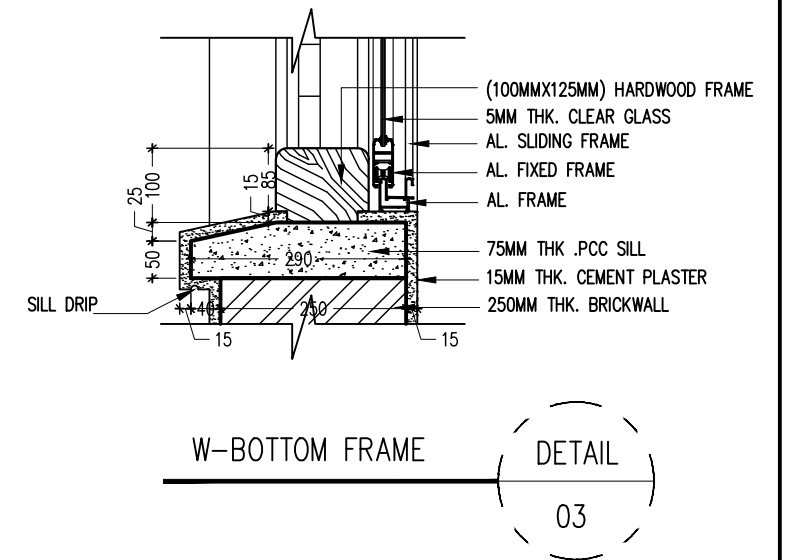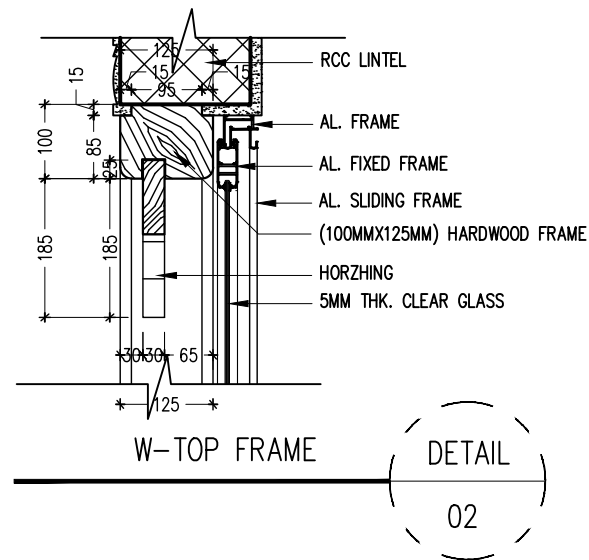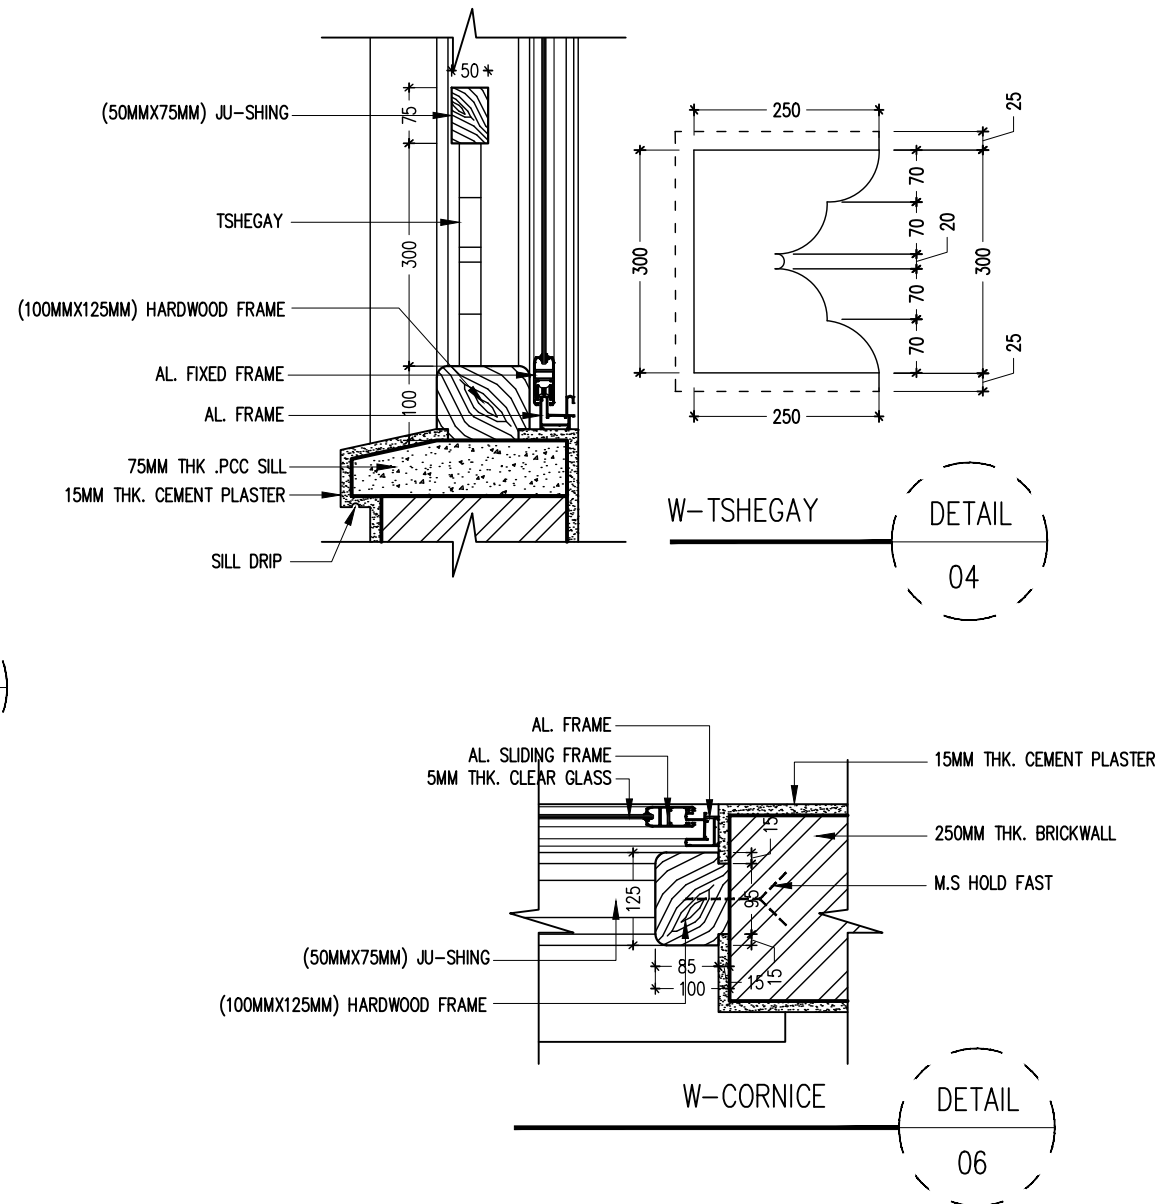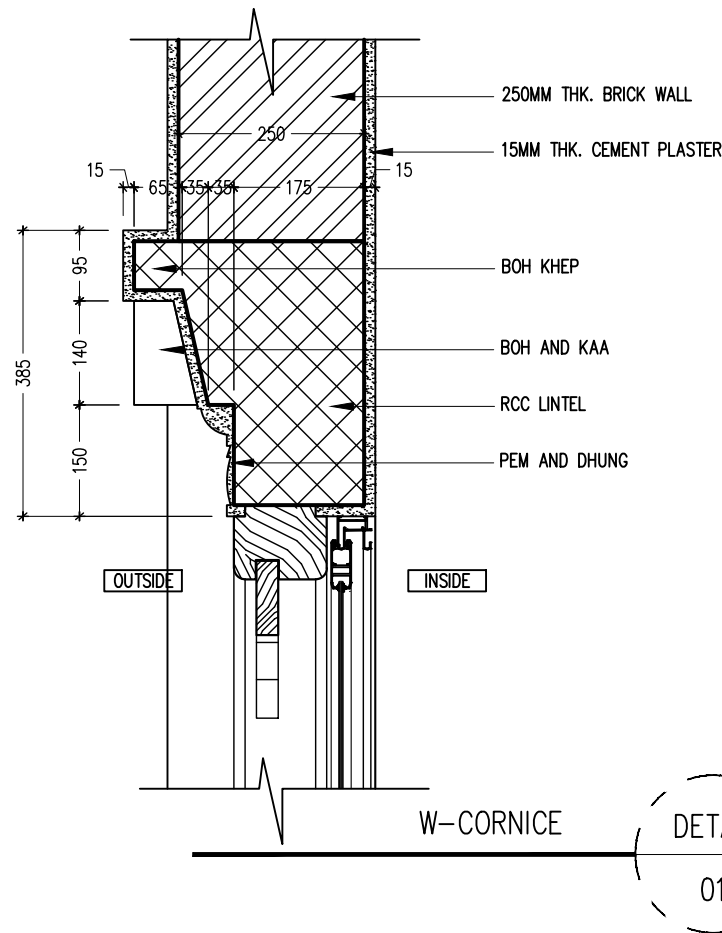

	<div>BHUTAN POWER CORPORATION LIMITED</div> <div>TRANSMISSION DEPARTMENT</div>	PROJECT TITLE			REFERENCE NOTES		APPROVED BY	DESIGNED BY	DRAWING TITLE		DRAWING NO.
		DESIGN OF STAFF QUARTER (G+2) AT TSHENKHARI, NANGLAM			1. ALL MEASUREMENTS IN THE DRAWING ARE IN mm UNLESS AND OTHERWISE MENTIONED				REFER DRAWING		BPC/TD/TMD/NANGKOR/ARCH
					2. THE MEASUREMENTS IN THE DRAWING ARE TO BE READ AND NOT MEASURED		KUNZANG TOBGYE GENERAL MANAGER TD, BPC		SCALEDATE		DWG # 21
		DRAWING STATUS	APPROVAL	APPROVED	3. ANY DISCREPANCY IN THE DRAWING SHALL BE IMMEDIATELY BROUGHT TO THE NOTICE OF THE DESIGNER			SAILERSTHUMAGAI ARCHITECT BA-141 (P)	REF DWG	FEBRUARY, 2022	



	BHUTAN POWER CORPORATION LIMITED TRANSMISSION DEPARTMENT	PROJECT TITLE		REFERENCE NOTES		APPROVED BY	DESIGNED BY	DRAWING TITLE		DRAWING NO.
		DESIGN OF STAFF QUARTER (G+2) AT TSHENKHARI, NANGLAM		1. ALL MEASUREMENTS IN THE DRAWING ARE IN mm UNLESS AND OTHERWISE MENTIONED			 SAITEN HUMAGAI ARCHITECT BA-141 (P)	REFER DRAWING		BPC/TD/TMD/NANGKOR/ARCH
				2. THE MEASUREMENTS IN THE DRAWING ARE TO BE READ AND NOT MEASURED				SCALE	DATE	DWG # 22
		DRAWING STATUS	APPROVAL <input type="checkbox"/>	APPROVED <input type="checkbox"/>	3. ANY DISCREPANCY IN THE DRAWING SHALL BE IMMEDIATELY BROUGHT TO THE NOTICE OF THE DESIGNER		KUNZANG TOBGYE GENERAL MANAGER TD, BPC	REF DWG	FEBRUARY, 2022	



BHUTAN POWER CORPORATION LIMITED

TRANSMISSION DEPARTMENT

PROJECT TITLE

DESIGN OF STAFF QUARTER (G+2) AT TSHENKHARI, NANGLAM

DRAWING STATUS

APPROVAL

APPROVED

REFERENCE NOTES

1. ALL MEASUREMENTS IN THE DRAWING ARE IN mm UNLESS AND OTHERWISE MENTIONED

2. THE MEASUREMENTS IN THE DRAWING ARE TO BE READ AND NOT MEASURED

3. ANY DISCREPANCY IN THE DRAWING SHALL BE IMMEDIATELY BROUGHT TO THE NOTICE OF THE DESIGNER

APPROVED BY

KUNZANG TOBGYE
GENERAL MANAGER
TD. BPC

DESIGNED BY

SAIKESH HUMAGAI
ARCHITECT
BA-141 (P)

DRAWING TITLE

REFER DRAWING

SCALE

	DATE
--	------



REF DWG



FEBRUARY, 2022

DRAWING NO.


BPC/TD/TMD/NANGKOR/ARCH

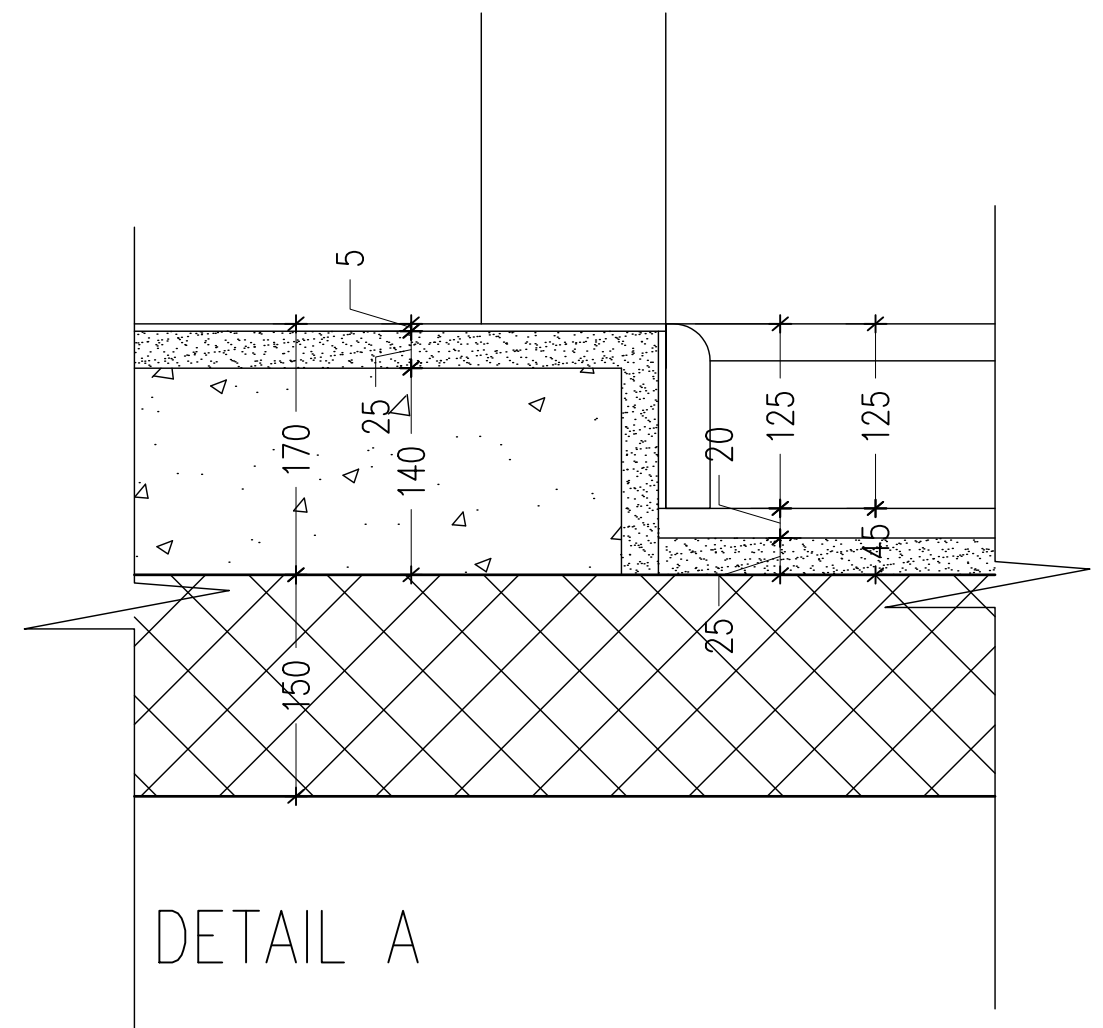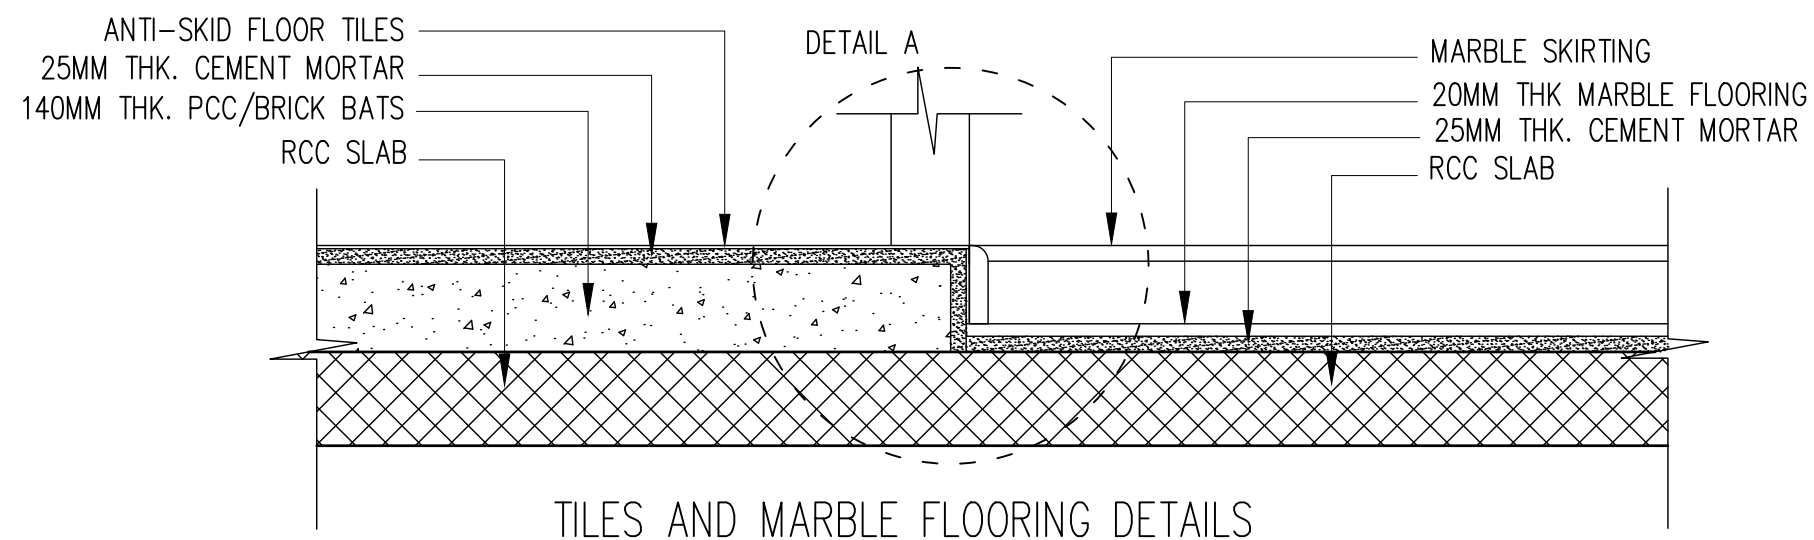

DWG # 23




	BHUTAN POWER CORPORATION LIMITED TRANSMISSION DEPARTMENT	PROJECT TITLE			REFERENCE NOTES		APPROVED BY	DESIGNED BY	DRAWING TITLE		DRAWING NO.
		DESIGN OF STAFF QUARTER (G+2) AT TSHENKHARI, NANGLAM			1. ALL MEASUREMENTS IN THE DRAWING ARE IN mm UNLESS AND OTHERWISE MENTIONED				REFER DRAWING		BPC/TD/TMD/NANGKOR/ARCH
					2. THE MEASUREMENTS IN THE DRAWING ARE TO BE READ AND NOT MEASURED		KUNZANG TOBGYE GENERAL MANAGER TD, BPC		SAALESS HUMAGAI ARCHITECT BA-141 (P)	SCALE	DATE
		DRAWING STATUS	APPROVAL <input type="checkbox"/>	APPROVED <input type="checkbox"/>	3. ANY DISCREPANCY IN THE DRAWING SHALL BE IMMEDIATELY BROUGHT TO THE NOTICE OF THE DESIGNER					REF DWG	FEBRUARY, 2022

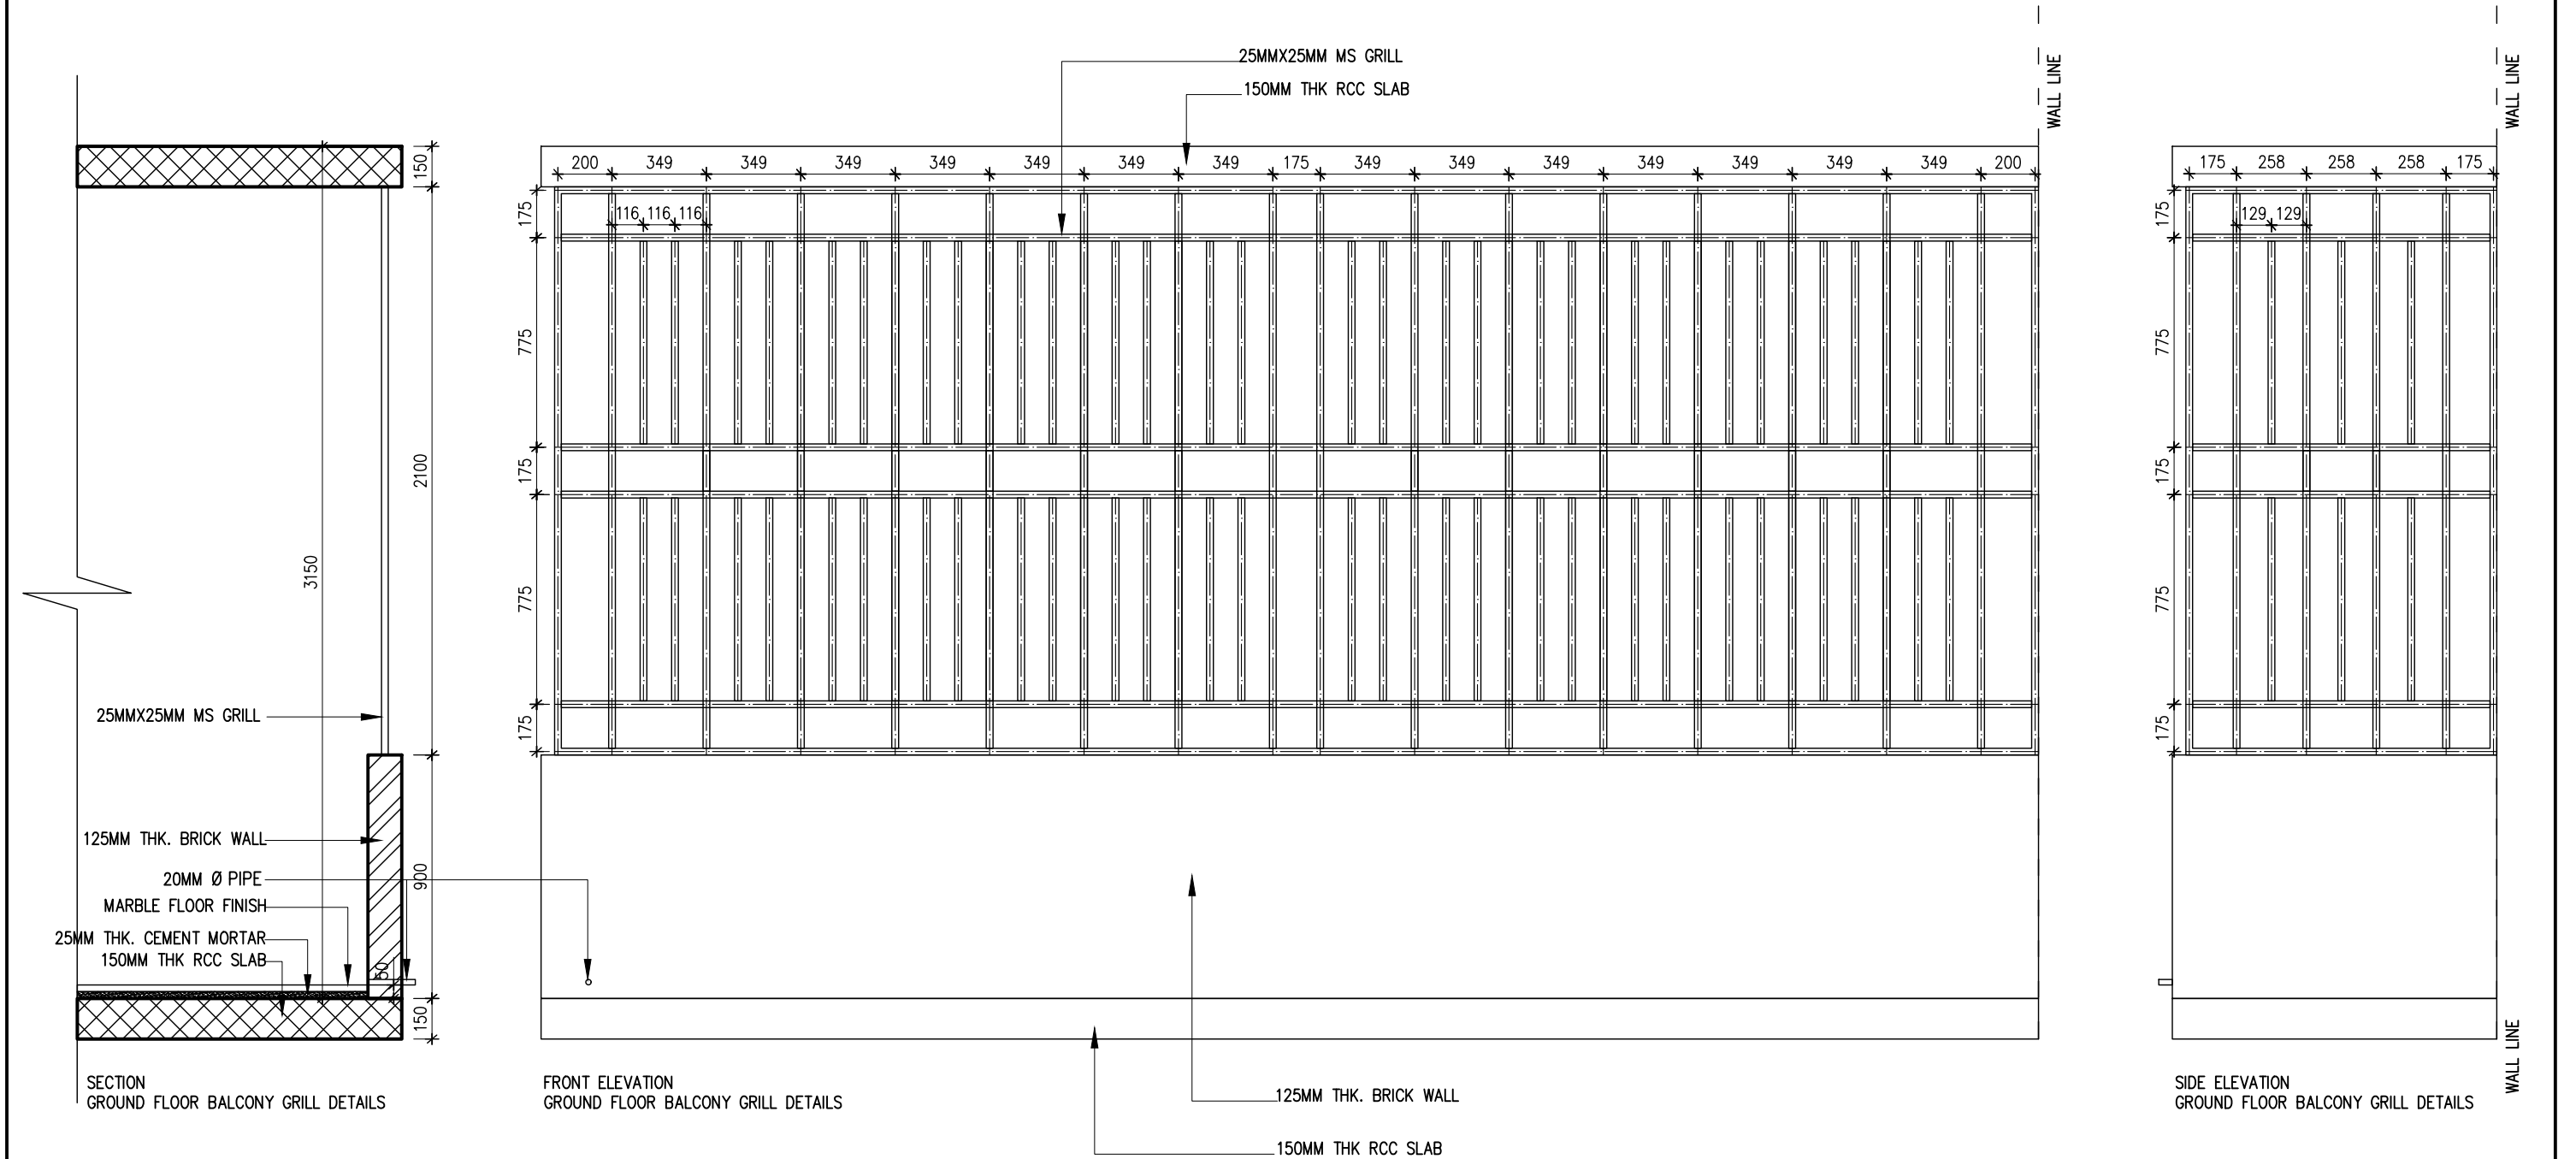





	BHUTAN POWER CORPORATION LIMITED TRANSMISSION DEPARTMENT	PROJECT TITLE		REFERENCE NOTES		APPROVED BY	DESIGNED BY	DRAWING TITLE		DRAWING NO.
		DESIGN OF STAFF QUARTER (G+2) AT TSHENKHARI, NANGLAM		1. ALL MEASUREMENTS IN THE DRAWING ARE IN mm UNLESS AND OTHERWISE MENTIONED				REFER DRAWING		BPC/TD/TMD/NANGKOR/ARCH
				2. THE MEASUREMENTS IN THE DRAWING ARE TO BE READ AND NOT MEASURED		KUNZANG TOBGYE GENERAL MANAGER TD, BPC		SAILESH HUMAGAI ARCHITECT BA-141 (P)	SCALE	DATE
		DRAWING STATUS	APPROVAL <input type="checkbox"/>	APPROVED <input type="checkbox"/>	3. ANY DISCREPANCY IN THE DRAWING SHALL BE IMMEDIATELY BROUGHT TO THE NOTICE OF THE DESIGNER				REF DWG	FEBRUARY, 2022

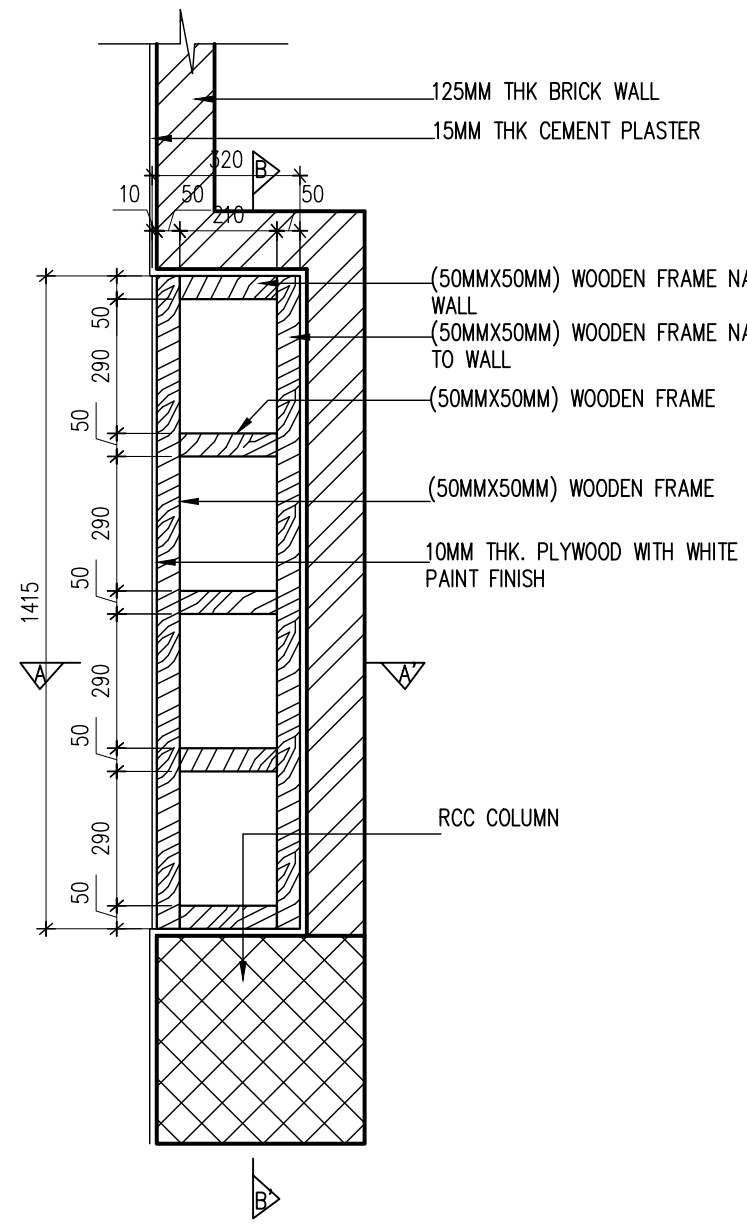

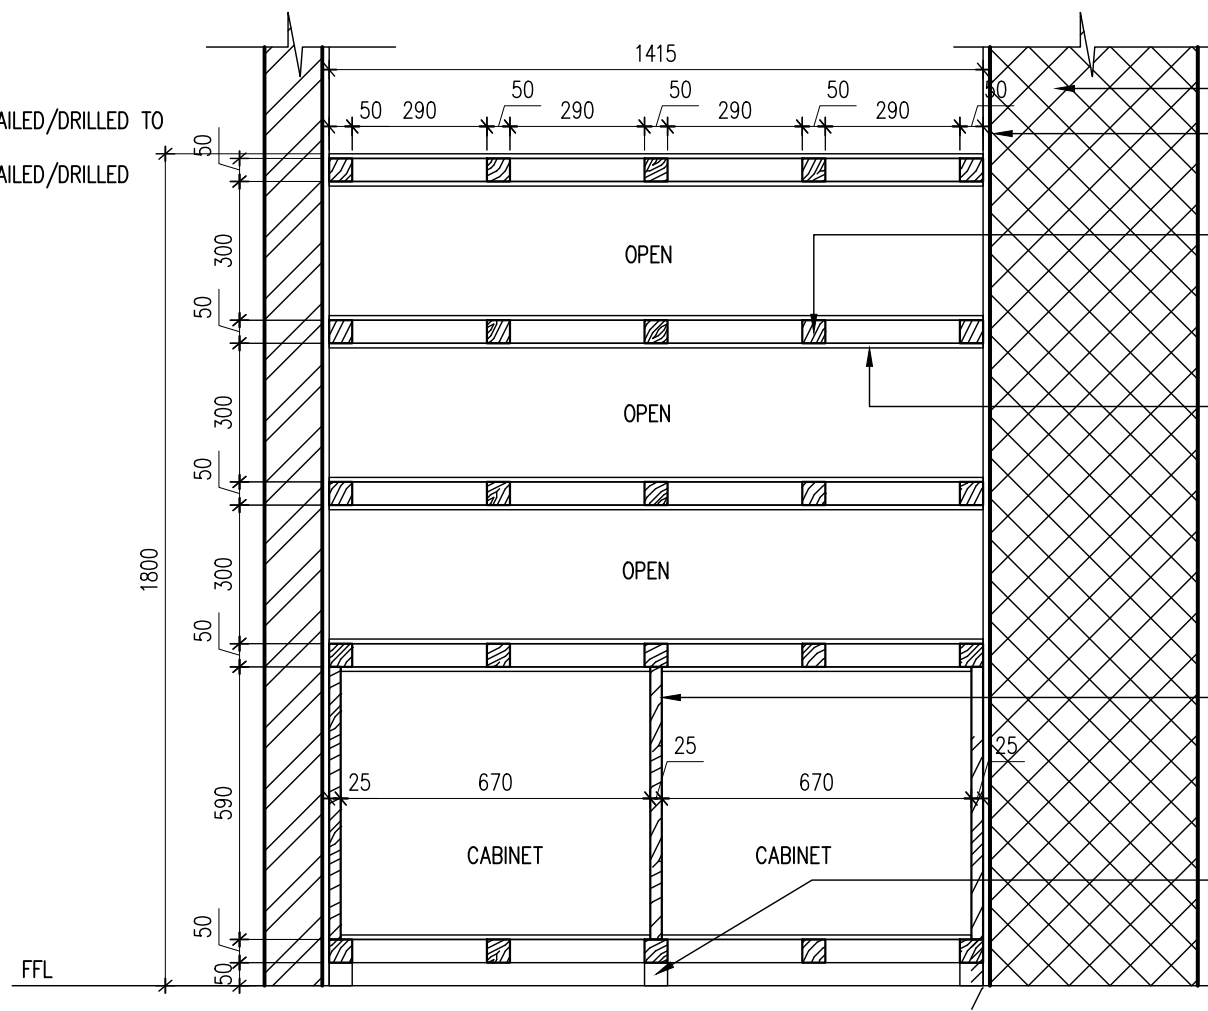

PLAN
SHELF DETAILS – LIVING ROOM

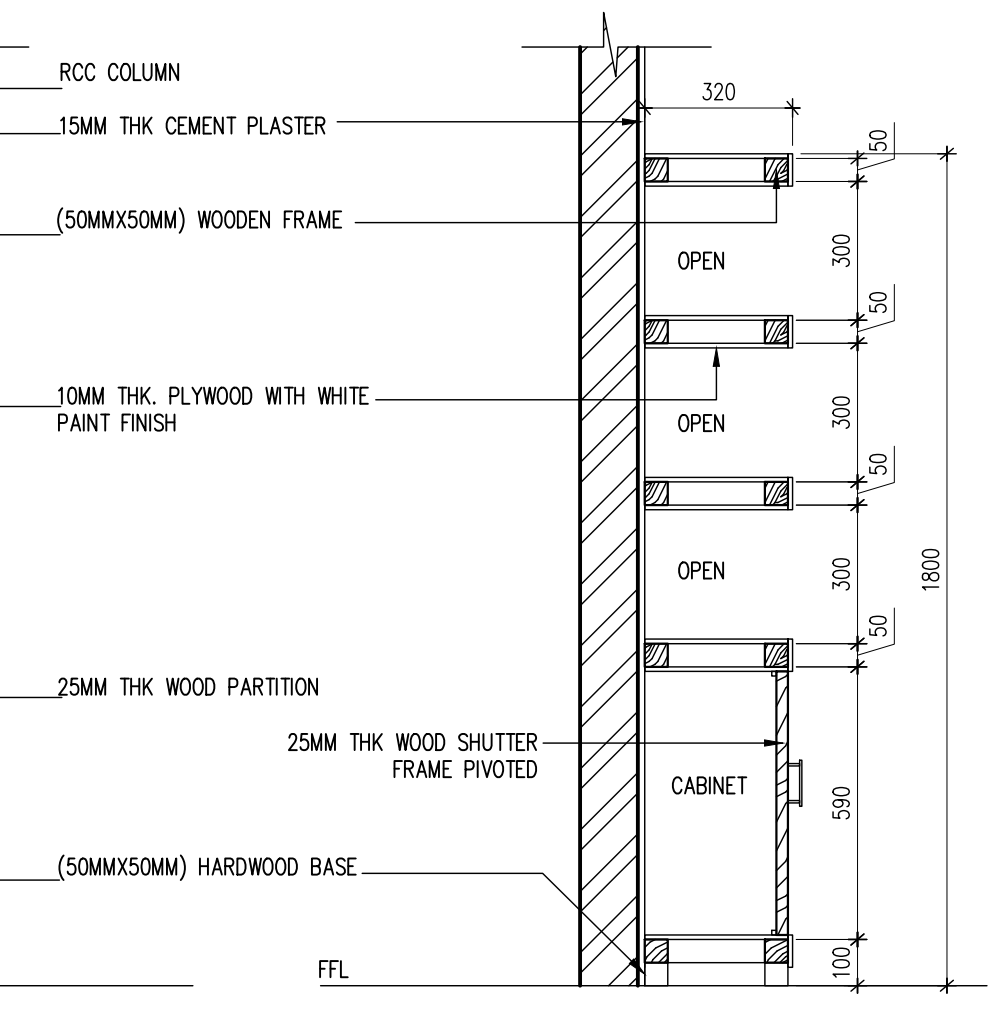


SECTION BB'




SECTION AA'


	BHUTAN POWER CORPORATION LIMITED TRANSMISSION DEPARTMENT	PROJECT TITLE		REFERENCE NOTES		APPROVED BY	DESIGNED BY	DRAWING TITLE		DRAWING NO.
		DESIGN OF STAFF QUARTER (G+2) AT TSHENKHARI, NANGLAM		1. ALL MEASUREMENTS IN THE DRAWING ARE IN mm UNLESS AND OTHERWISE MENTIONED			 SAILER HUMAGAI ARCHITECT BA-141 (P)	REFER DRAWING		BPC/TD/TMD/NANGKOR/ARCH
				2. THE MEASUREMENTS IN THE DRAWING ARE TO BE READ AND NOT MEASURED		KUNZANG TOBGYE GENERAL MANAGER TD, BPC		SCALE	DATE	DWG # 27
		DRAWING STATUS	APPROVAL <input type="checkbox"/>	APPROVED <input type="checkbox"/>	3. ANY DISCREPANCY IN THE DRAWING SHALL BE IMMEDIATELY BROUGHT TO THE NOTICE OF THE DESIGNER			REF DWG	FEBRUARY, 2022	

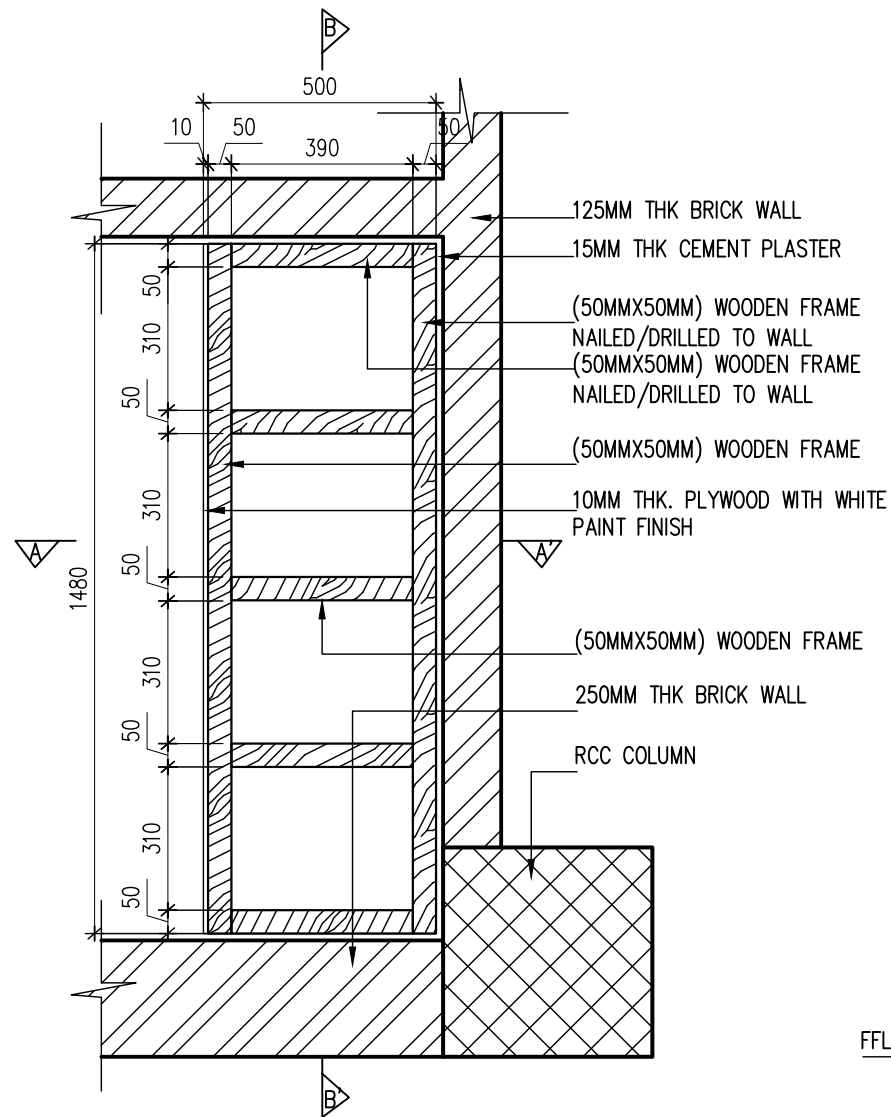

PLAN
SHELF DETAILS – STORE ROOM

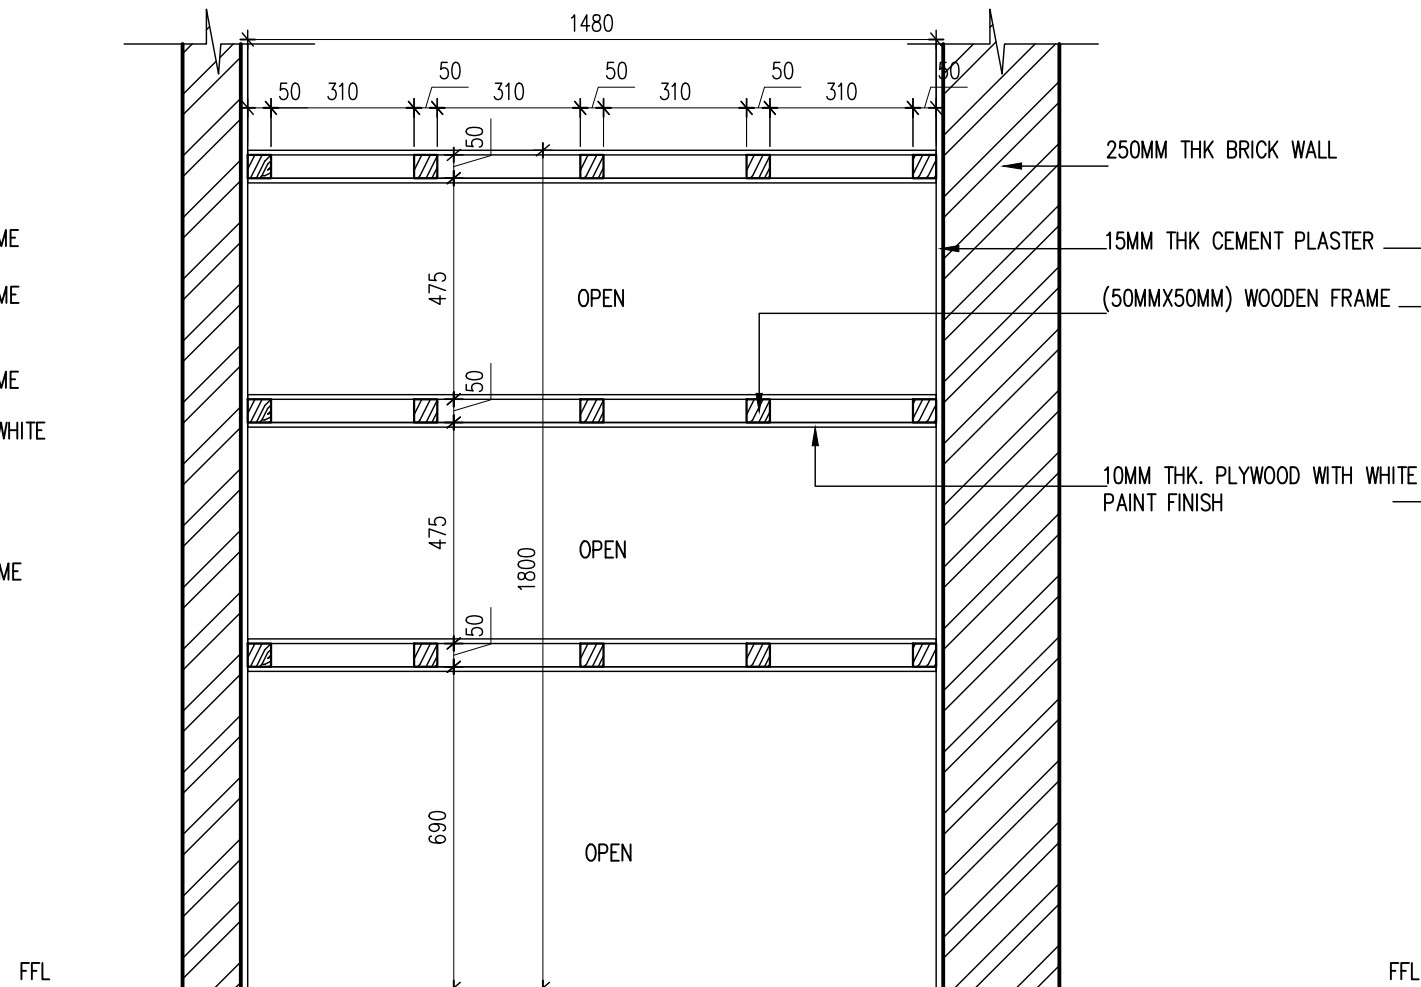

SECTION BB'

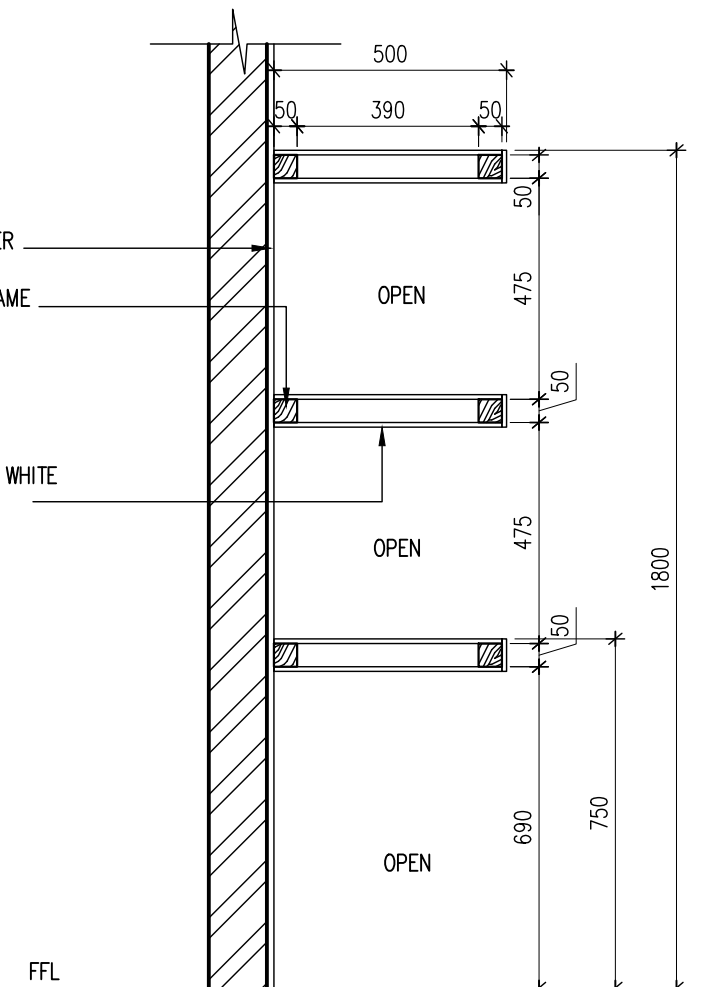

SECTION AA'



BHUTAN POWER CORPORATION LIMITED
TRANSMISSION DEPARTMENT

PROJECT TITLE
**DESIGN OF STAFF QUARTER (G+2) AT
TSHENKHARI, NANGLAM**

DRAWING STATUS APPROVAL ☐ APPROVED ☐

REFERENCE NOTES

1. ALL MEASUREMENTS IN THE DRAWING ARE IN mm UNLESS AND OTHERWISE MENTIONED

2. THE MEASUREMENTS IN THE DRAWING ARE TO BE READ AND NOT MEASURED

3. ANY DISCREPANCY IN THE DRAWING SHALL BE IMMEDIATELY BROUGHT TO THE NOTICE OF THE DESIGNER

APPROVED BY
KUNZANG TOBGYE
GENERAL MANAGER
TD, BPC

DESIGNED BY
SAILESH HUMAGAI
ARCHITECT
BA-141 (P)


DRAWING TITLE
REFER DRAWING

SCALE
REF DWG


DATE
FEBRUARY, 2022

DRAWING NO.
BPC/TD/TMD/NANGKOR/ARCH


DWG # 28

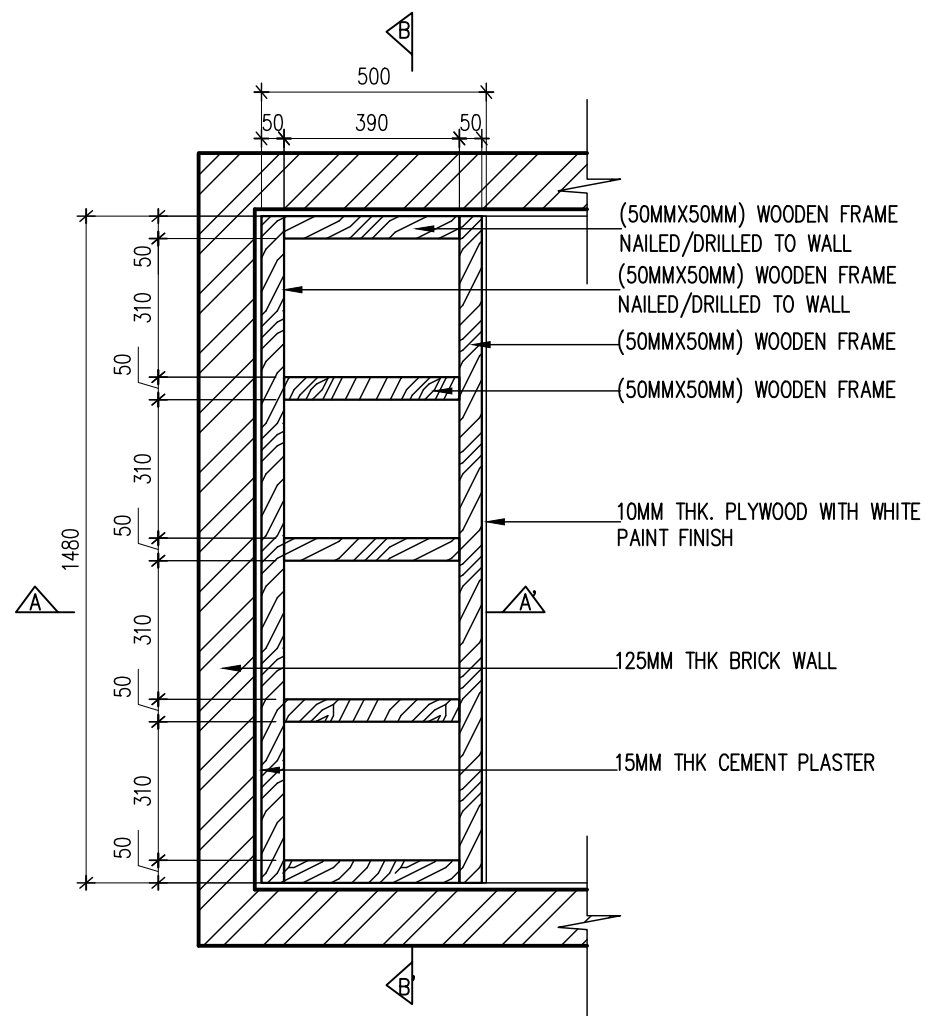

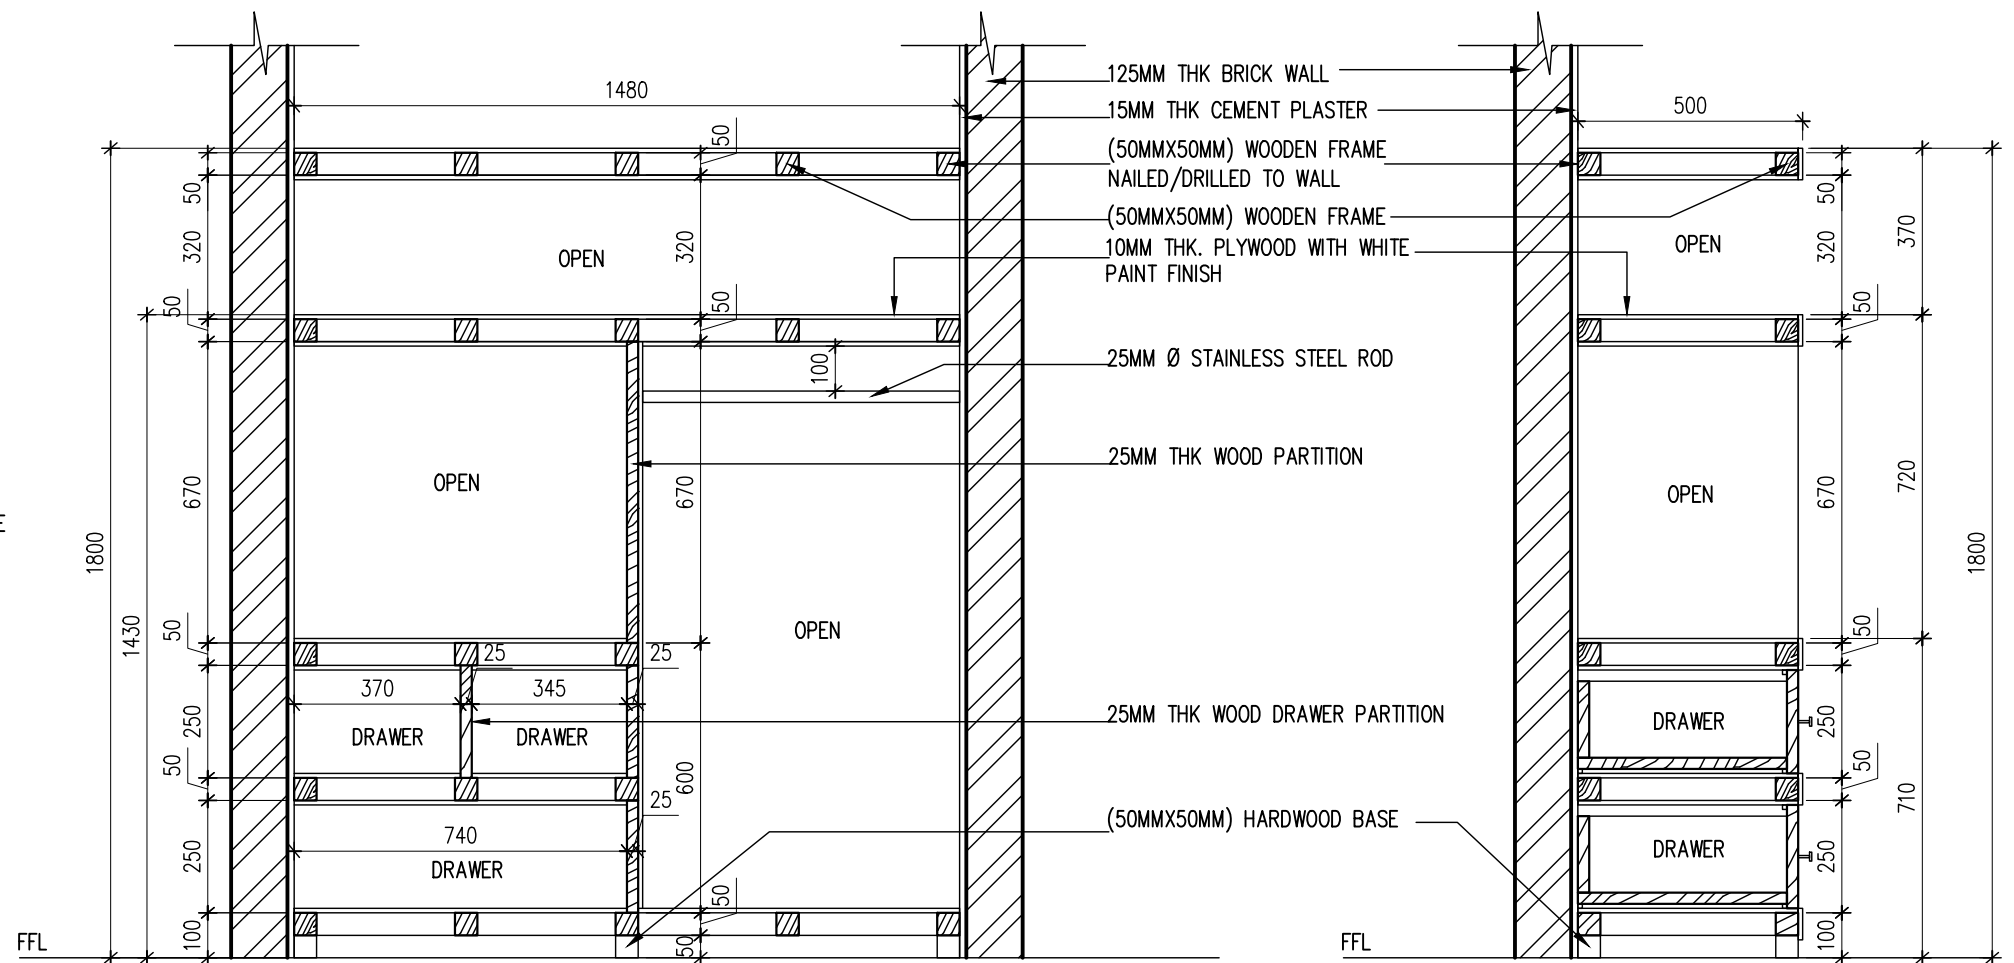

PLAN
SHELVE DETAILS – WALK-IN CLOSET

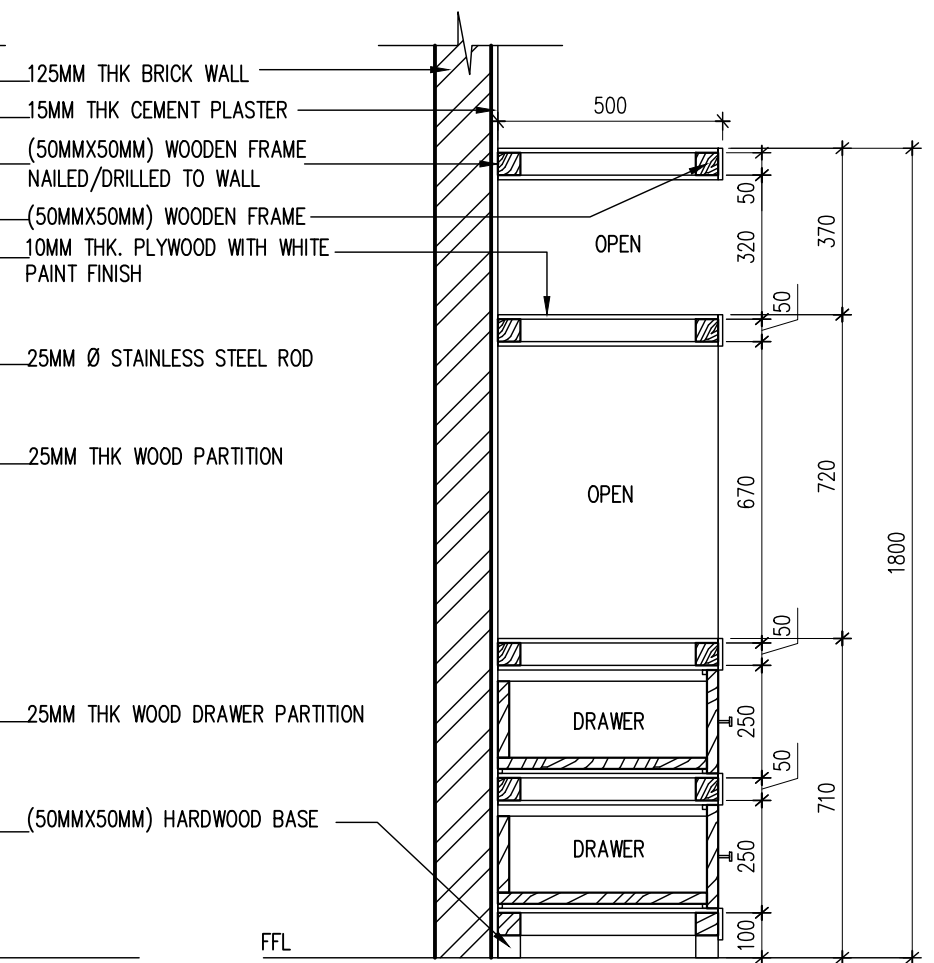


SECTION BB'



SECTION AA'

	BHUTAN POWER CORPORATION LIMITED TRANSMISSION DEPARTMENT	PROJECT TITLE		REFERENCE NOTES		APPROVED BY	DESIGNED BY	DRAWING TITLE		DRAWING NO.
		DESIGN OF STAFF QUARTER (G+2) AT TSHENKHARI, NANGLAM		1. ALL MEASUREMENTS IN THE DRAWING ARE IN mm UNLESS AND OTHERWISE MENTIONED			 SAALESH M. MAGAI ARCHITECT BA-141 (P)	REFER DRAWING		BPC/TD/TMD/NANGKOR/ARCH
				2. THE MEASUREMENTS IN THE DRAWING ARE TO BE READ AND NOT MEASURED		KUNZANG TOBGYE GENERAL MANAGER TD, BPC		SCALE	DATE	DWG # 29
		DRAWING STATUS	APPROVAL <input type="checkbox"/>	APPROVED <input type="checkbox"/>	3. ANY DISCREPANCY IN THE DRAWING SHALL BE IMMEDIATELY BROUGHT TO THE NOTICE OF THE DESIGNER		REF DWG	FEBRUARY, 2022		

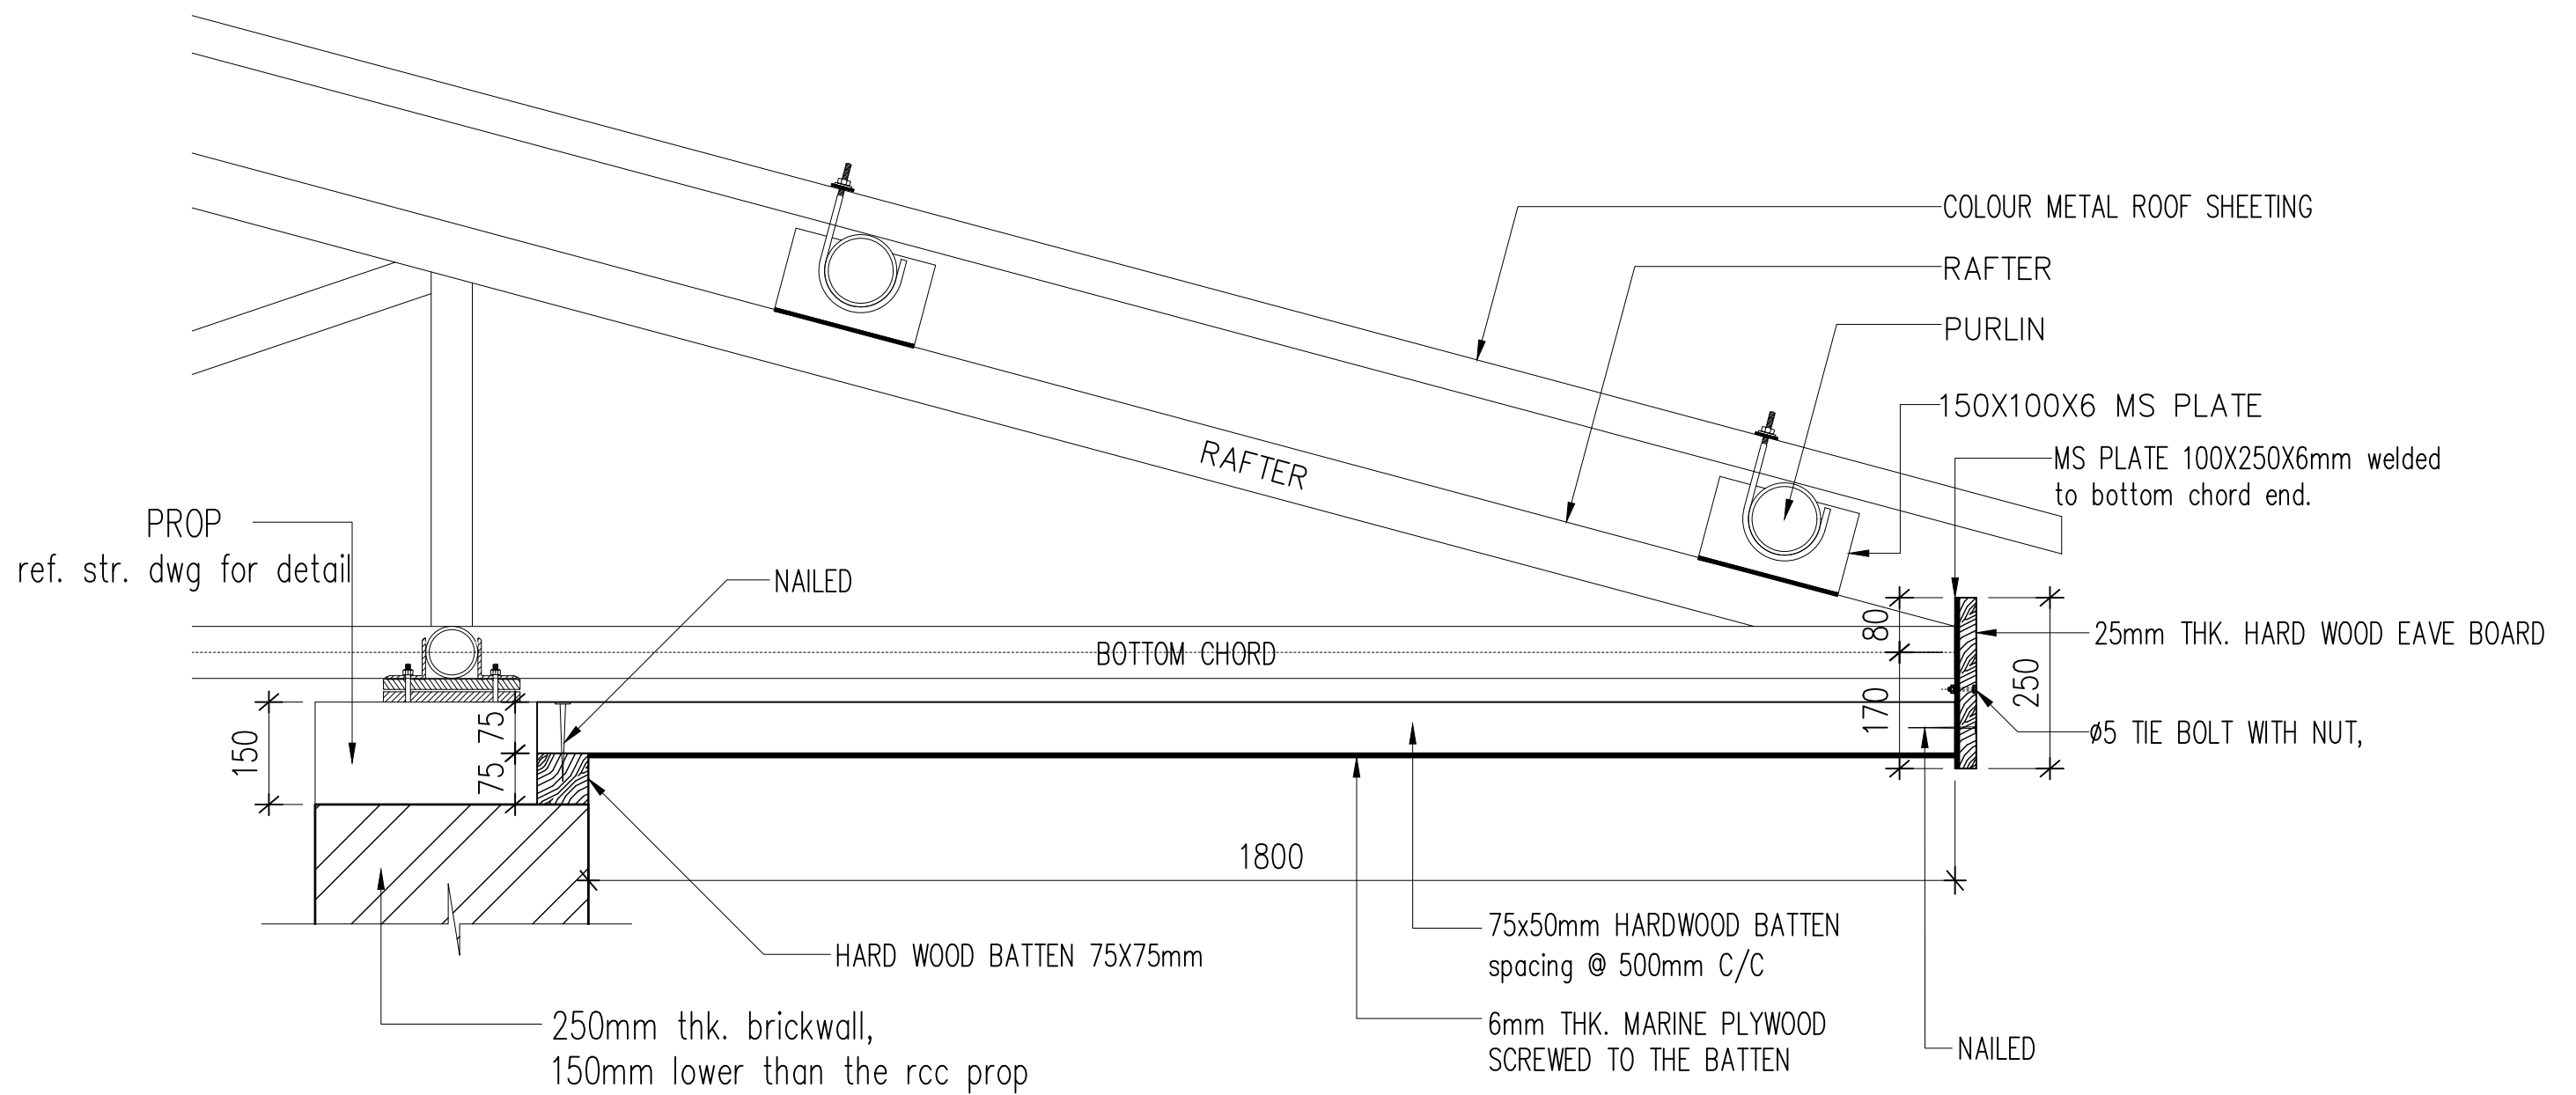

EAVE CEILING DETAILS



BHUTAN POWER CORPORATION LIMITED
TRANSMISSION DEPARTMENT

PROJECT TITLE		
DESIGN OF STAFF QUARTER (G+2) AT TSHENKHARI, NANGLAM		
DRAWING STATUS	APPROVAL <input type="checkbox"/>	APPROVED <input type="checkbox"/>


REFERENCE NOTES
1. ALL MEASUREMENTS IN THE DRAWING ARE IN mm UNLESS AND OTHERWISE MENTIONED
2. THE MEASUREMENTS IN THE DRAWING ARE TO BE READ AND NOT MEASURED
3. ANY DISCREPANCY IN THE DRAWING SHALL BE IMMEDIATELY BROUGHT TO THE NOTICE OF THE DESIGNER

APPROVED BY
KUNZANG TOBGYE GENERAL MANAGER TD, BPC



DESIGNED BY
SAILESH HUMAGAI ARCHITECT BA-141 (P)

DRAWING TITLE	
REFER DRAWING	
SCALE	DATE
REF DWG	FEBRUARY, 2022

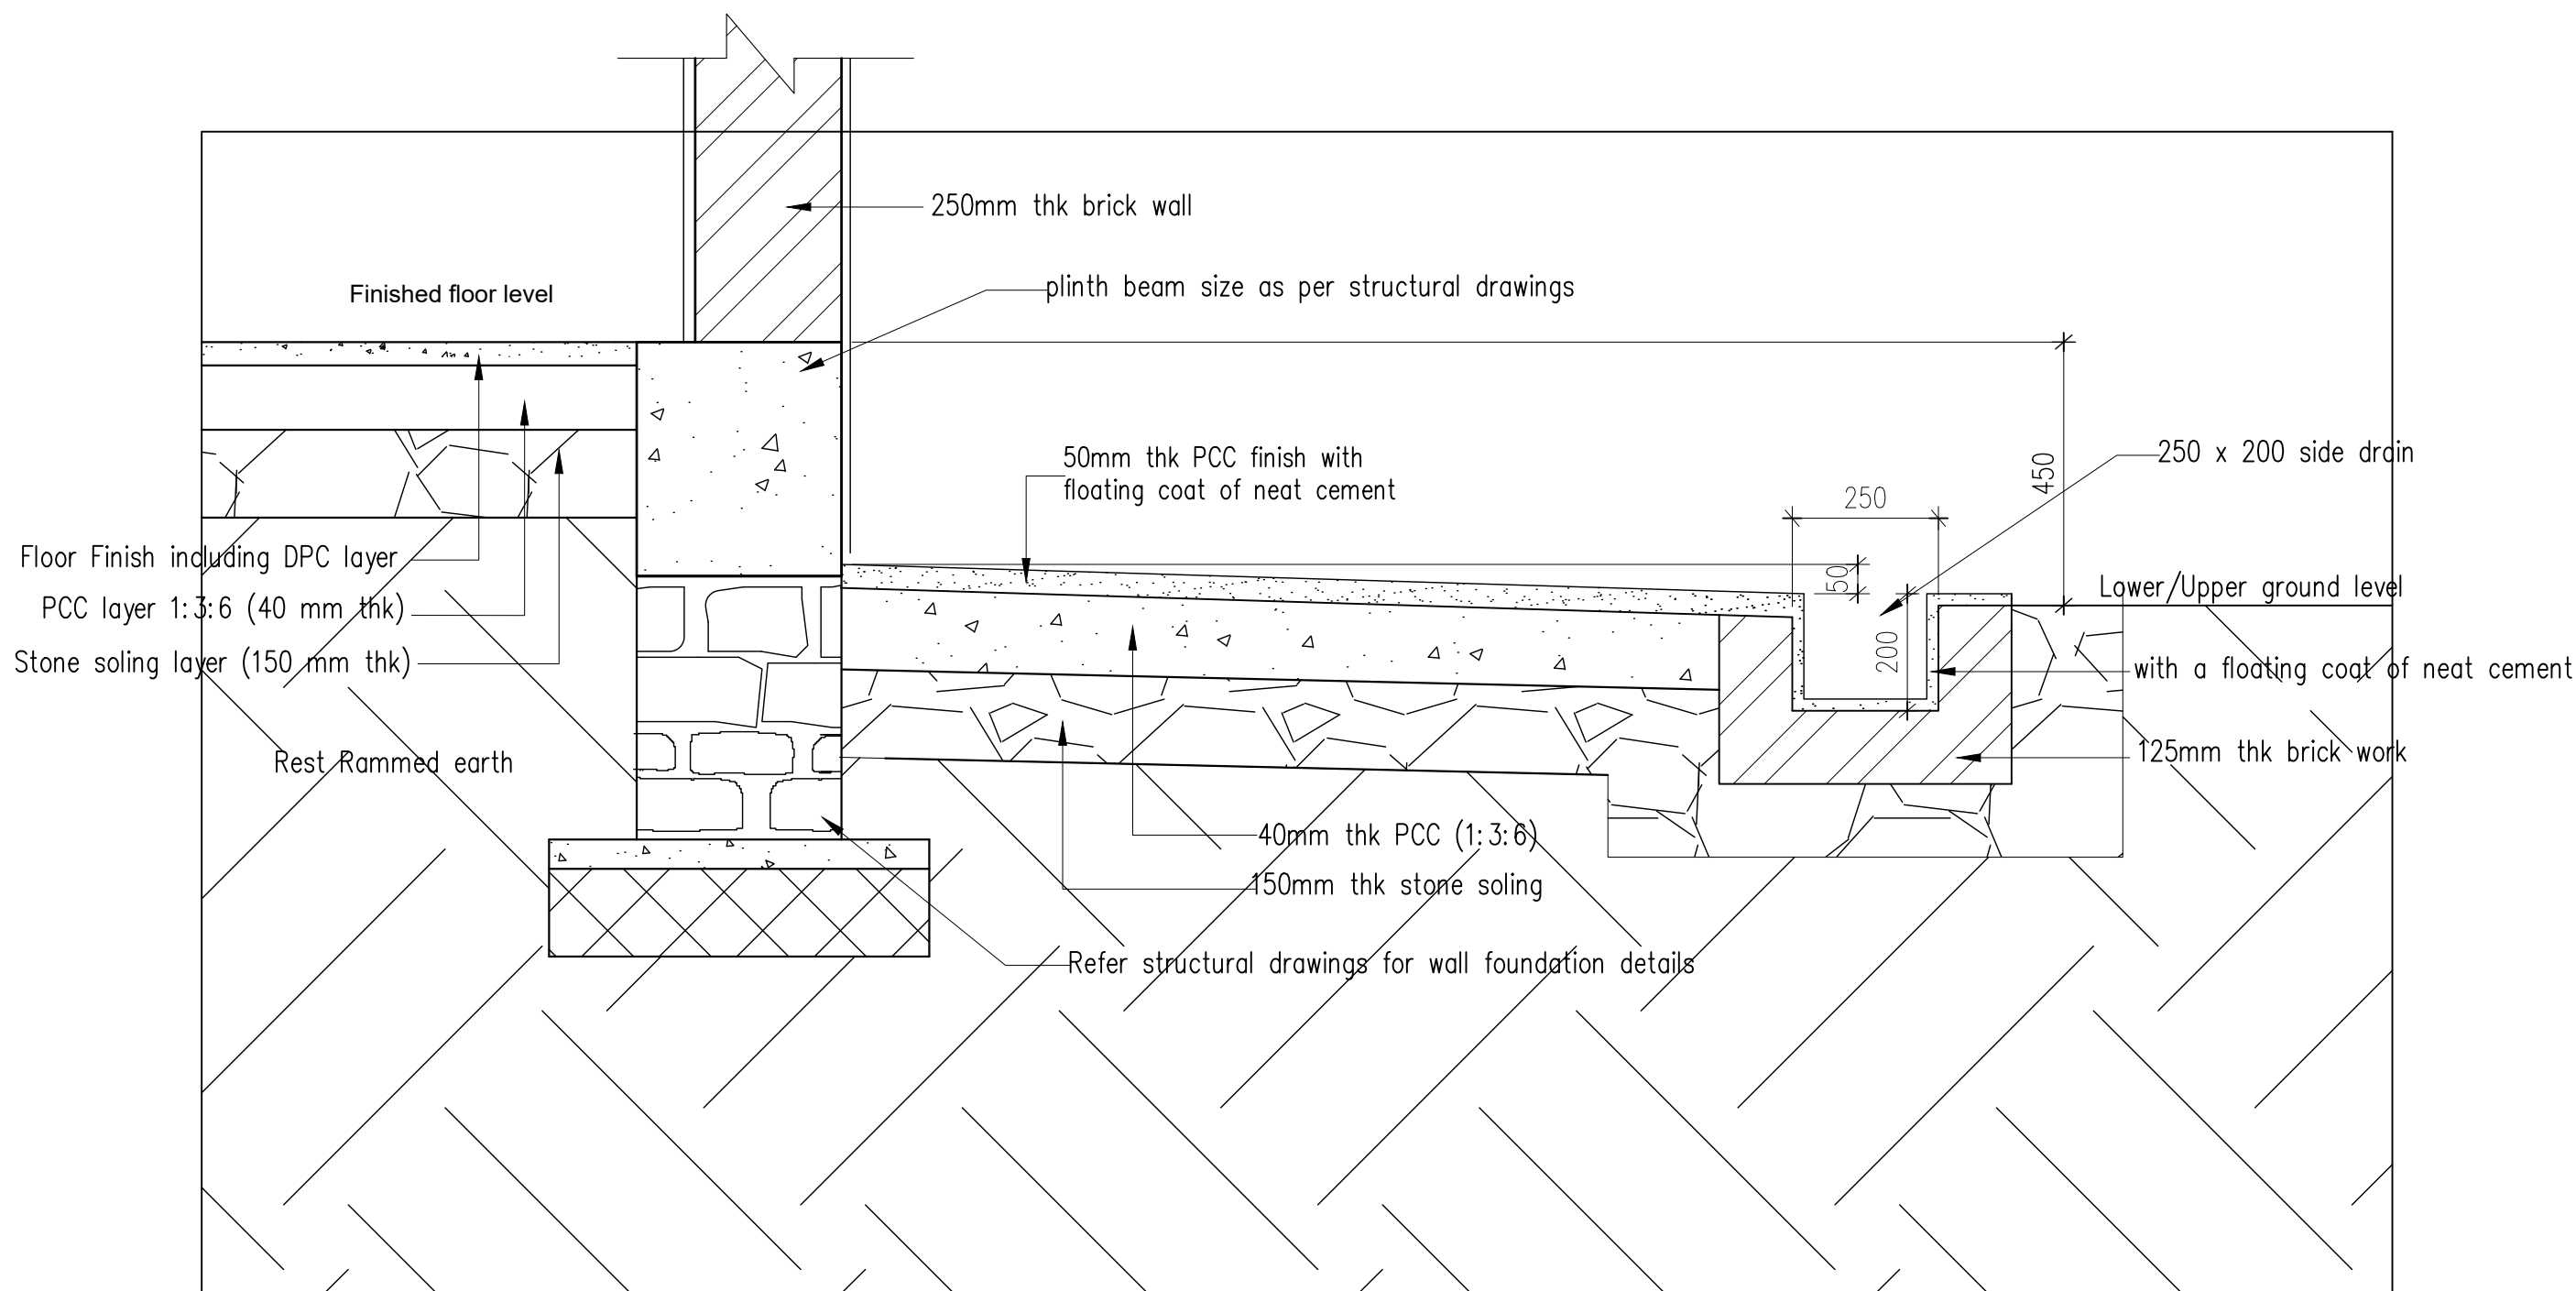DRAWING NO.
BPC/TD/TMD/NANGKOR/ARCH
DWG # 30



PLINTH PROTECTION DETAIL

	BHUTAN POWER CORPORATION LIMITED TRANSMISSION DEPARTMENT	PROJECT TITLE		REFERENCE NOTES		APPROVED BY	DESIGNED BY	DRAWING TITLE		DRAWING NO.
		DESIGN OF STAFF QUARTER (G+2) AT TSHENKHARI, NANGLAM		1. ALL MEASUREMENTS IN THE DRAWING ARE IN mm UNLESS AND OTHERWISE MENTIONED			 SATEESH HUMAGAI ARCHITECT BA-141 (P)	REFER DRAWING		BPC/TD/TMD/NANGKOR/ARCH
				2. THE MEASUREMENTS IN THE DRAWING ARE TO BE READ AND NOT MEASURED		KUNZANG TOBGYE GENERAL MANAGER TD, BPC		SCALE	DATE	DWG # 31
		DRAWING STATUS	APPROVAL <input type="checkbox"/>	APPROVED <input type="checkbox"/>	3. ANY DISCREPANCY IN THE DRAWING SHALL BE IMMEDIATELY BROUGHT TO THE NOTICE OF THE DESIGNER			REF DWG	FEBRUARY, 2022	